

AN OFFICE AND STORAGE FACILITY FOR:

JAMES HANOUSEK

TRADER PLACE

INDIO, CA 92201

PARCEL 1, TENTATIVE PARCEL MAP NO. 31410

ARCHITECT:

CHARLES W. McBRIDE
C12905
C/O DESIGN BUILD STRUCTURES, INC
74-133 EL PASEO, SUITE #11
PALM DESERT, CA 92260
(760) 346-5300

CONTRACTOR:

DESIGN BUILD STRUCTURES, INC.
74-133 EL PASEO, SUITE #11
PALM DESERT, CA 92260
(760) 346-5300

CIVIL:


McGEE SURVEYING, INC.
79-301 COUNTRY CLUB DR. SUITE 102
BERMUDA DUNES, CA 92201
(760) 345-3828

Sheet Index

- T.1 TITLE PAGE
A.1 SITE PLAN/DETAILS
S.1 OFFICE FOUNDATION PLAN/DETAILS
A.2 OFFICE FLOOR PLAN/INTERIOR ELEVATIONS/SCHEDULES
A.3 OFFICE EXTERIOR ELEVATIONS/SECTIONS
A.4 OFFICE ROOF PLAN/REFLECTED CEILING PLAN
A.5 OFFICE ROOF FRAMING PLAN/DETAILS
A.6 OFFICE ELECTRICAL PLAN/DETAILS
A.7 OFFICE MECHANICAL PLAN/PLUMBING PLAN/DETAILS
S.2 STORAGE FOUNDATION PLAN/DETAILS
A.8 STORAGE FLOOR PLAN/INTERIOR ELEVATIONS
A.9 STORAGE EXTERIOR ELEVATIONS/SECTION
A.10 STORAGE ELECTRICAL/MECHANICAL/PLUMBING PLANS
P.1 PLANTING PLAN
I.1 IRRIGATION PLAN
I.2 IRRIGATION DETAILS

ACCOMPANYING PLANS:
Structural calculations by Robert Hoffman
Structural calculations and drawings by Butler Manufacturing Co.
Energy calculations by Joan Hacker
Truss calculations by Trussworks
Geotechnical Investigation by Sladden Engineering
Precise grading plan by McGee Surveying, Inc.

BUILDING CODES	California Building Code 2001 Uniform Building Code 1997
OCCUPANCY GROUPS	(Table 3-A) B and S-2
DESCRIPTION OF OCCUPANCY	(Table 3-A) Office and low hazard storage
FIRE RESISTANCE OF EXTERIOR WALLS	(Table 5-A) Exterior walls - bearing: 1 hour<20' Exterior walls - nonbearing: 1 hour<20'
OPENINGS IN EXTERIOR WALLS	(Table 5-A) Exterior walls - protected<10' none<5'
CONSTRUCTION TYPES	(Chapter 6) II-N at 5,000 sq. ft. metal building V-N at 1000 sq. ft. office building
OCCUPANT LOADS	(Table 10-A) Office = 1000/100 = 10 Storage = 5000/300 = 17
REQUIRED EXITS	(Table 10-A) 1 at metal building 2 at office
SPRINKLER SYSTEMS	(Chapter 9) not required
BUILDING HEIGHTS	1 story
SEISMIC ZONE	4
Nv	1.8
Na	1.5
WIND SPEED	80
EXPOSURE	C
LOADING	20/12 w/3 collateral
REQUIRED SEPARATION IN BUILDING O	MIXED OCCUPANCY (Table 3-B) Not required 302.1.2.2

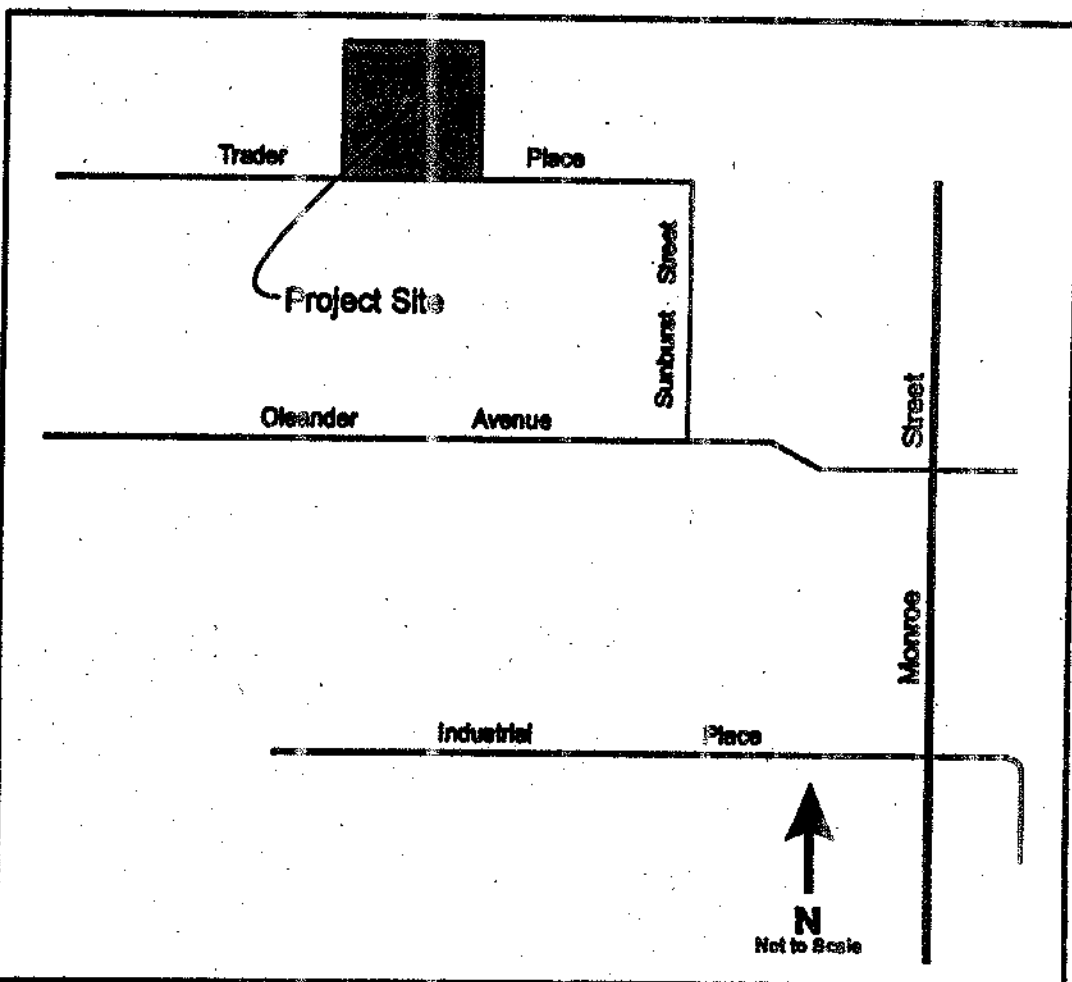


VICINITY MAP

PROJECT DATA


PROJECT TEAM

SHEET INDEX

91770-TRADER PLACE

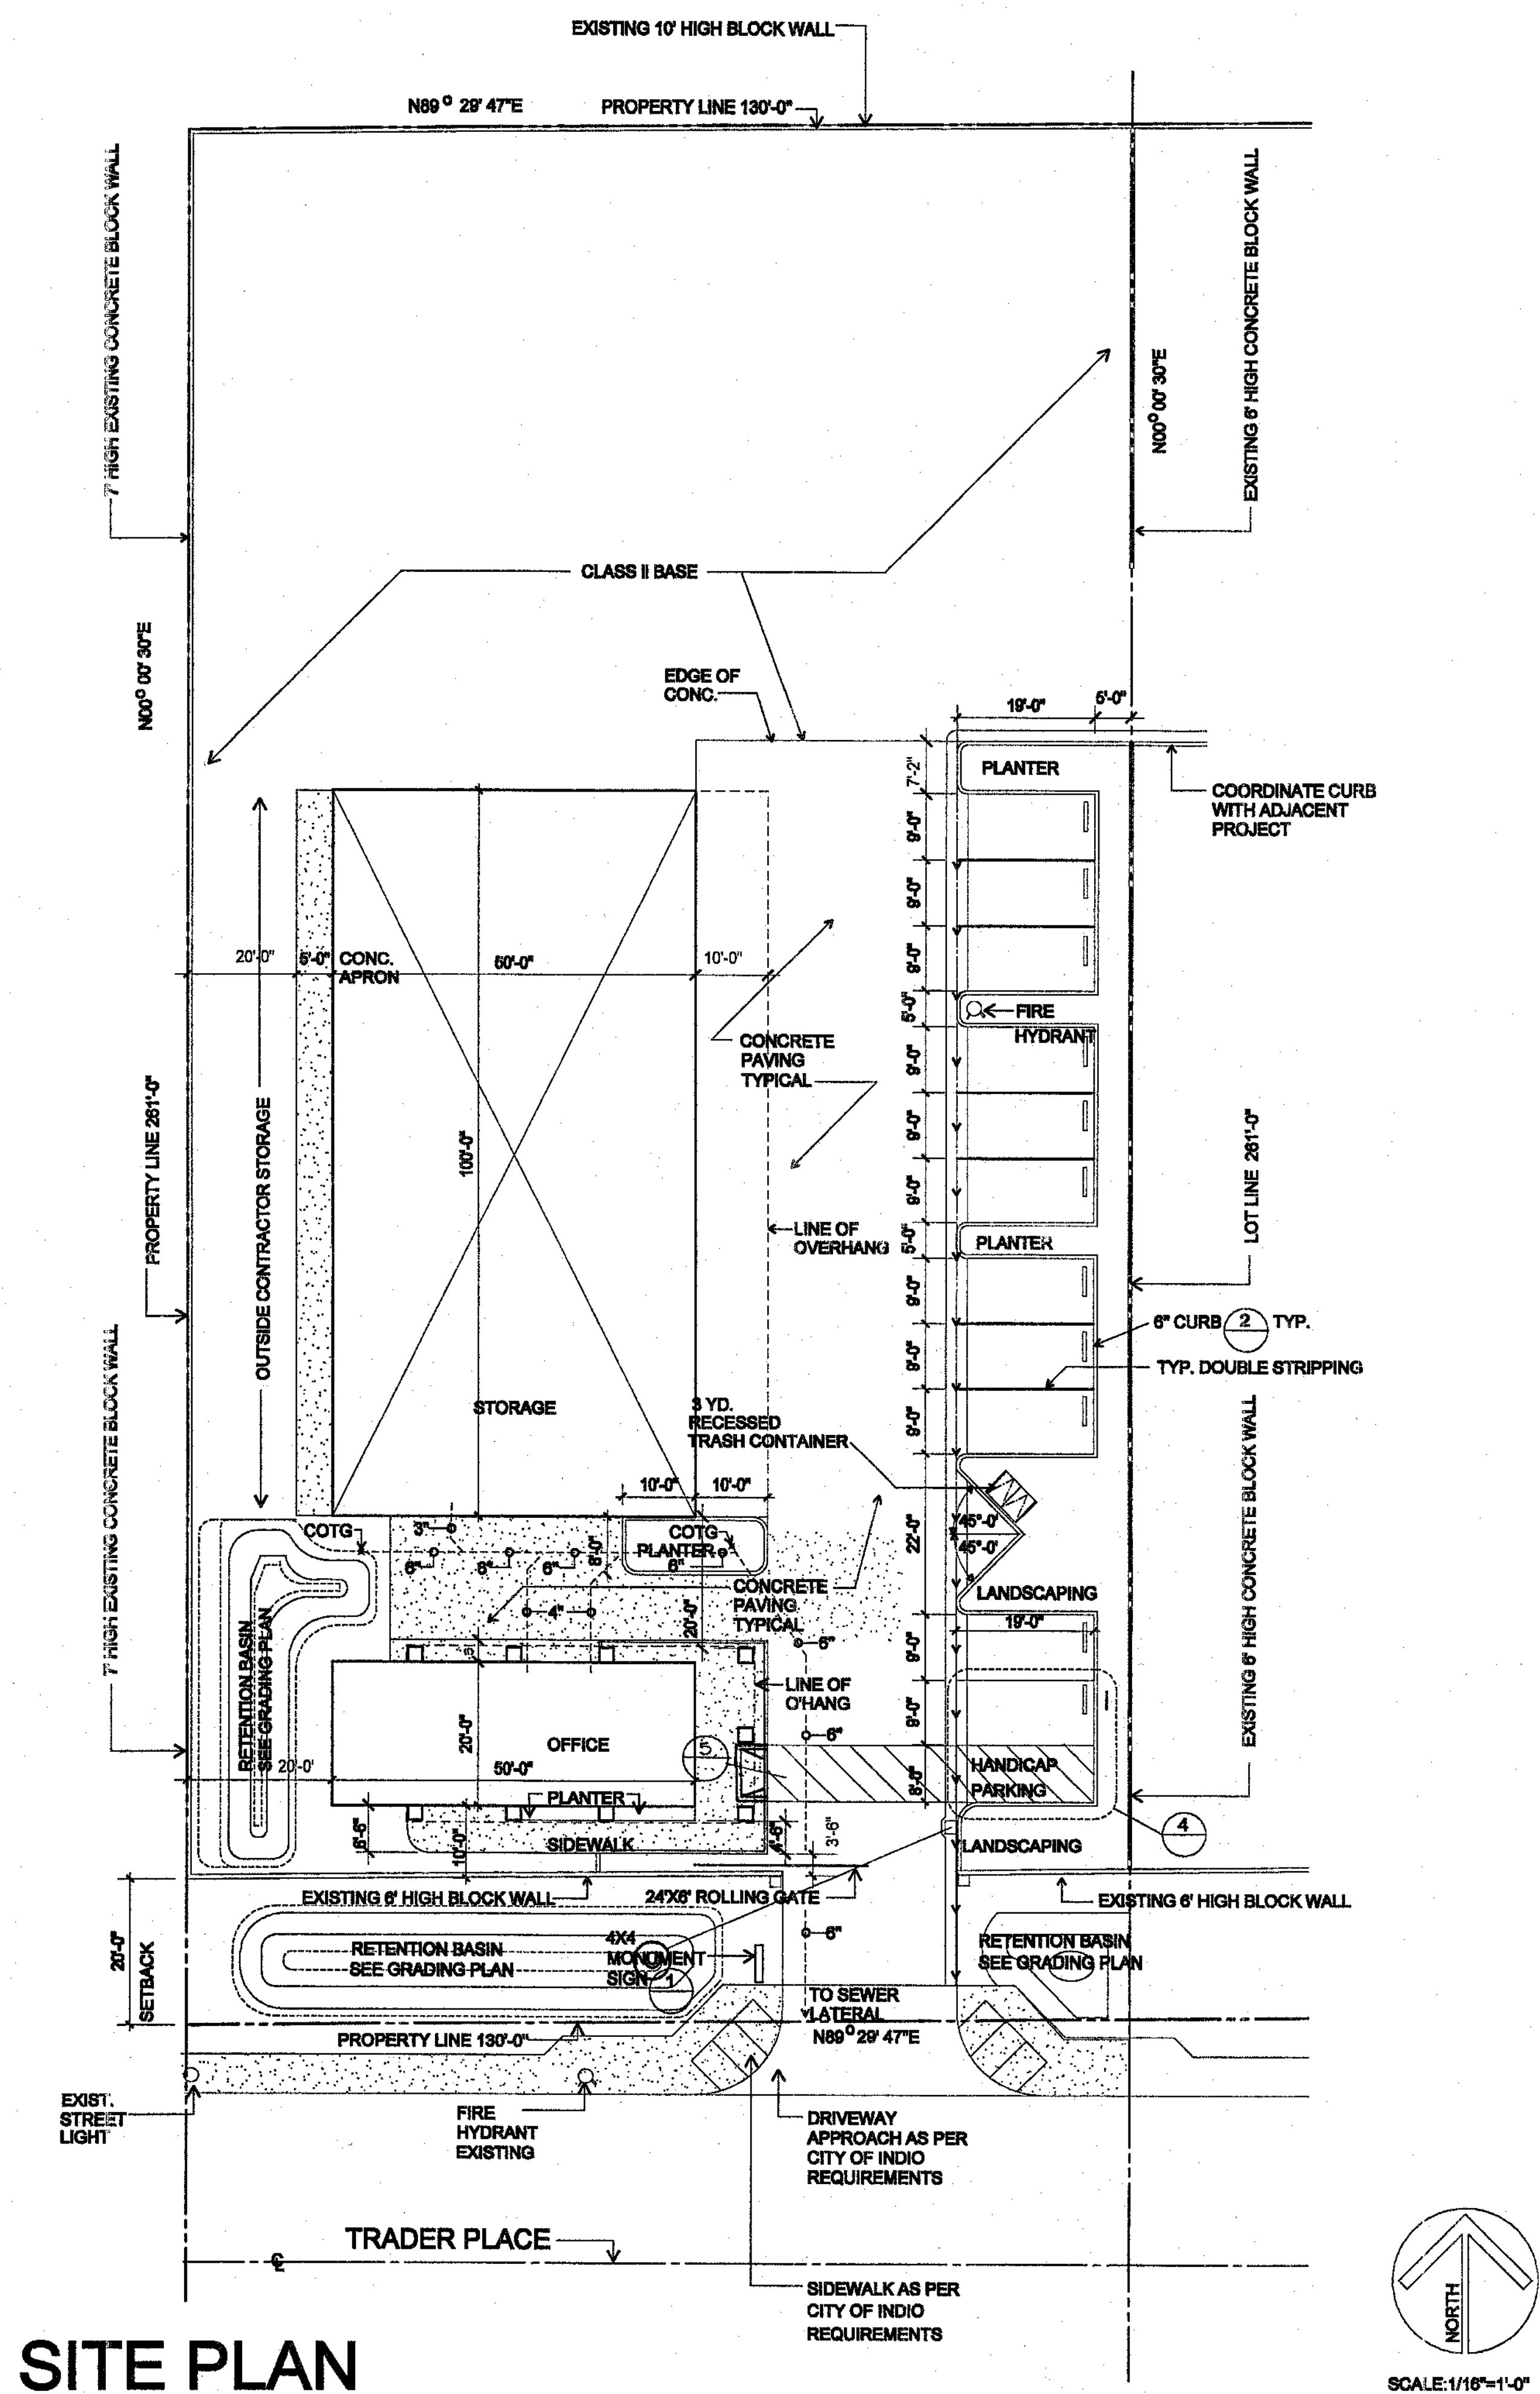COACHELLA VALLEY STORMWATER CHANNEL


SITE PLAN

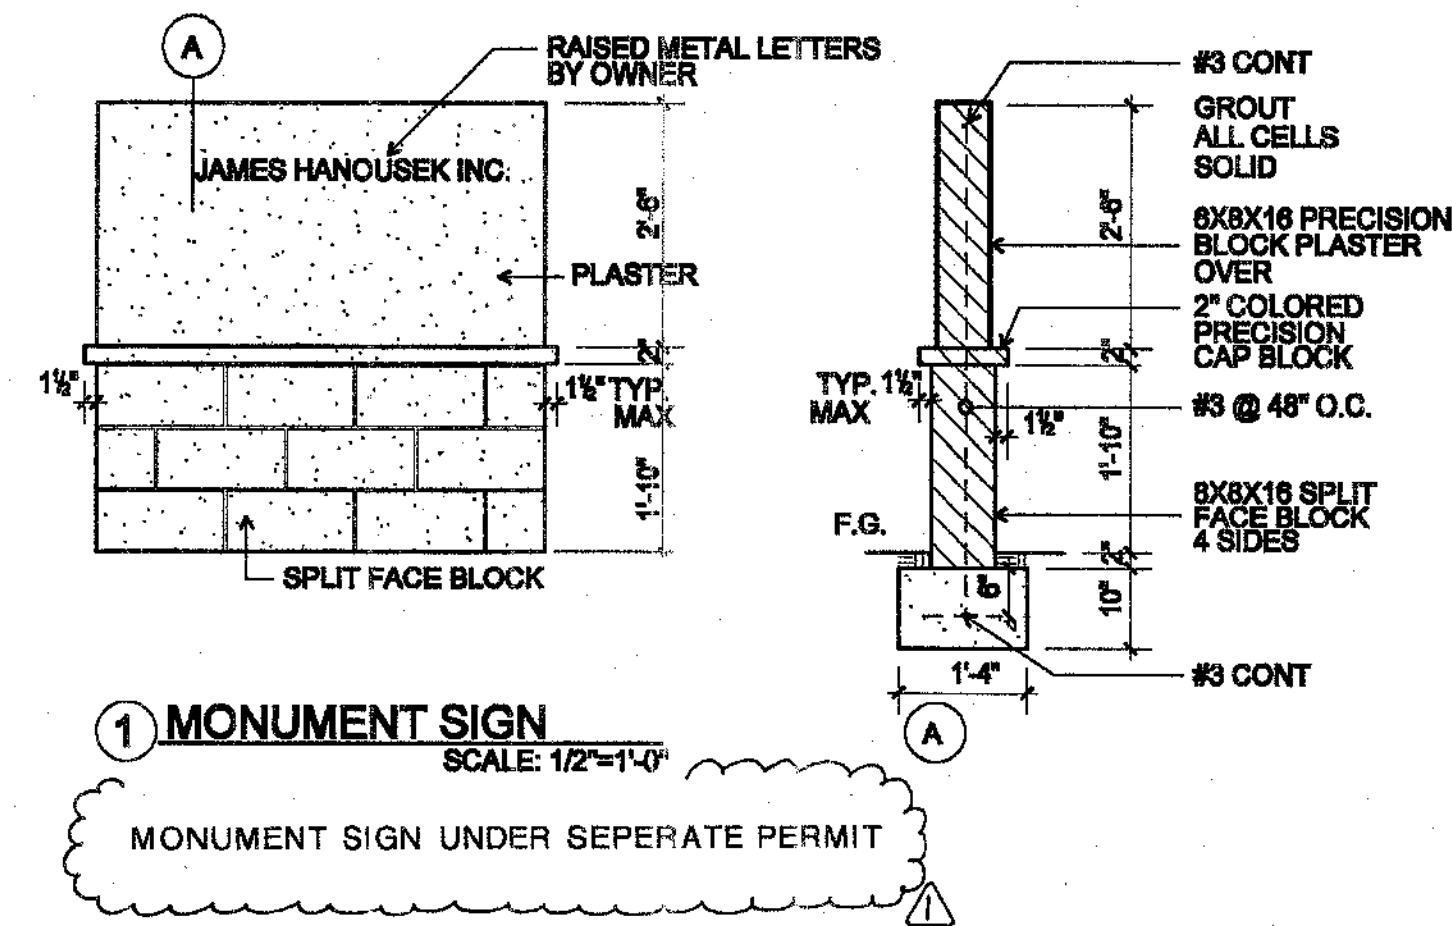

① MONUMENT SIGN


SCALE: 1/2"=1'-0"

MONUMENT SIGN UNDER SEPERATE PERMIT

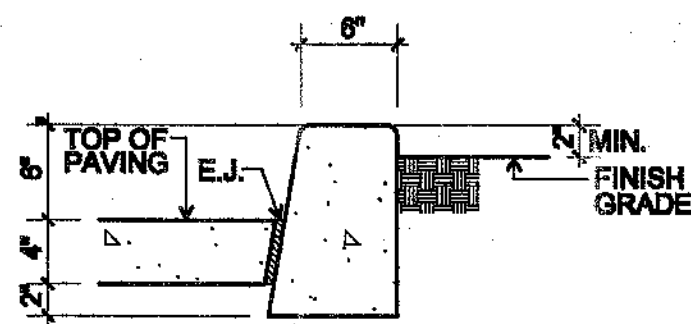


2 CONCRETE CURB

SCALE: 1" = 1'-0"

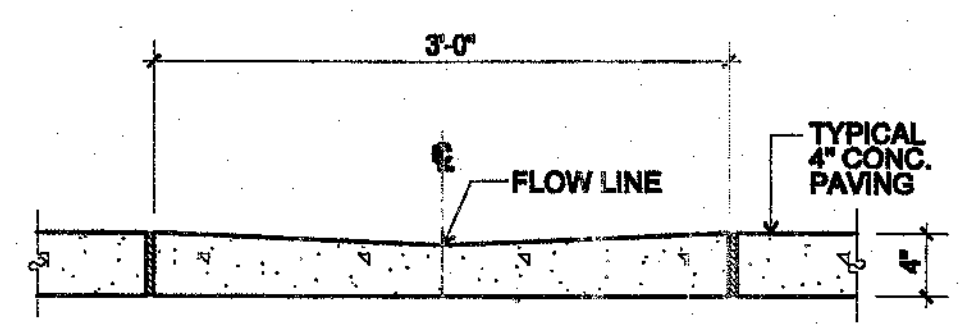


3 RIBBON GUTTER

SCALE: 1"=1'-0"

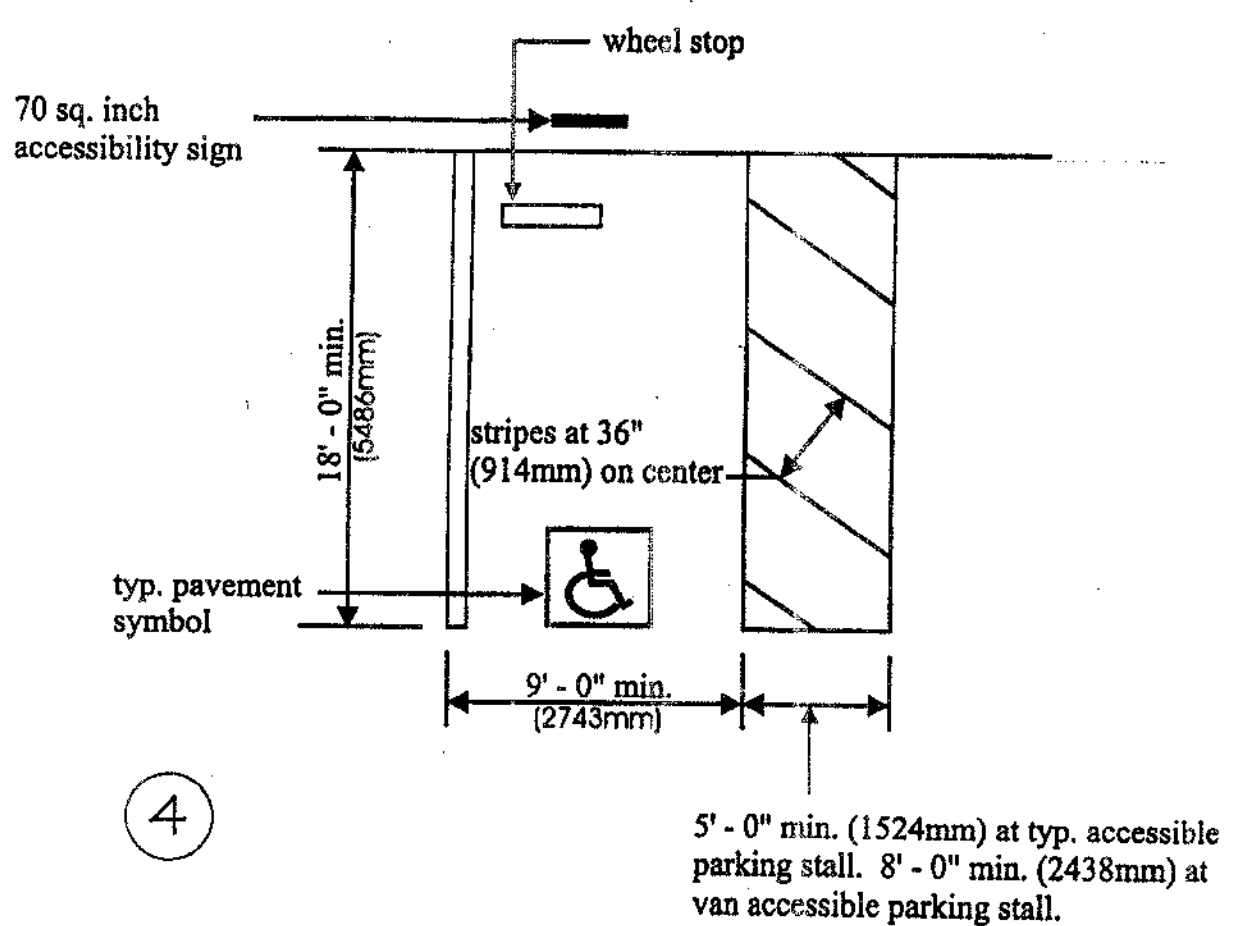

④

5' - 0" min. (1524mm) at typ. accessible parking stall. 8' - 0" min. (2438mm) at van accessible parking stall.

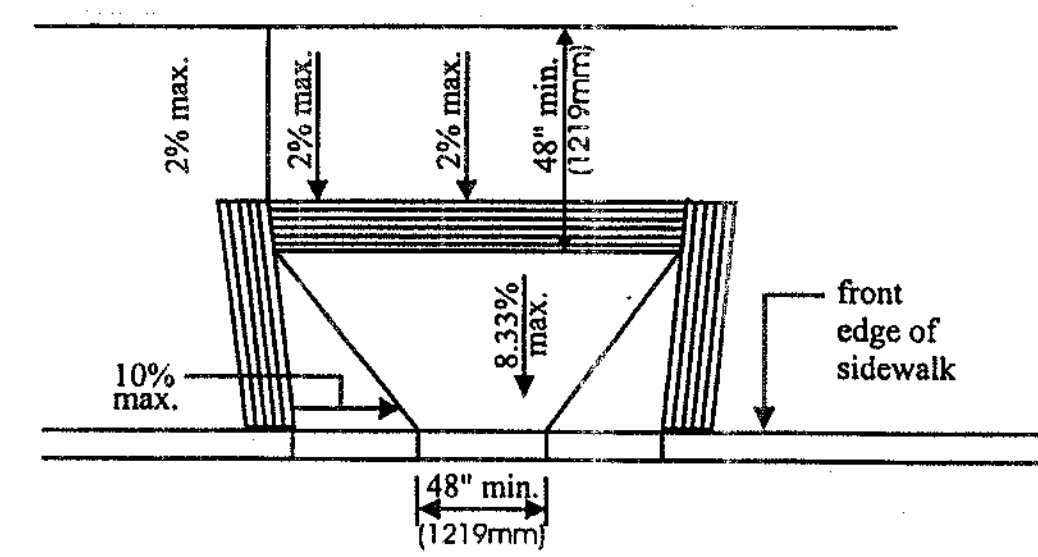

5

Each parking space reserved for persons with disabilities shall be identified by a reflectorized sign permanently posted immediately adjacent to and visible from each stall or space, consisting of a profile view of a wheelchair with occupant in white on dark blue background.

The sign shall not be smaller than 70 square inches (4516mm²) in area and, when in a path of travel, shall be posted at a minimum height of 80 inches (2032mm) from the bottom of the sign to the parking space finished grade.

Signs may also be entered on the wall at the interior end of the parking space at a minimum height of 36 inches (914mm) from the parking space finished grade, ground or sidewalk.

Spaces complying with this shall have an additional sign stating "Van-Accessible" mounted below the symbol of accessibility.

An additional sign shall also be posted in a conspicuous place at each entrance to off-street parking facilities, or immediately adjacent to and visible from each stall or space.

The sign shall not be less than 17 inches by 22 inches (432mm by 559mm) in size with lettering not less than 1-inch (25.4mm) in height, which clearly and conspicuously states the following:

"Unauthorized vehicles parked in designated accessible spaces not displaying distinguishing placards or license plates issued for persons with disabilities may be towed away at owner's expense.

Towed vehicles may be reclaimed at _____ or by telephoning _____

Blank spaces are to be filled in with appropriate information as a permanent part of the sign.

In addition to the above requirements, the surface of each accessible parking space or stall shall have a surface identification duplicating either of the following schemes:


1. By outlining or painting the stall or space in blue and outlining on the ground in the stall or space in white or suitable contrasting color a profile view depicting a wheelchair with occupant;
or
2. By outlining : profile view of a wheelchair with occupant in white on blue background.

The profile view shall be located so that it is visible to a traffic enforcement officer when a vehicle is properly parked in the space and shall be 36 inches high by 36 inches wide (914mm by 914mm).


Ann Office and Storage Facility for:

James Hanousek
Trader Place
Indio, California

Architect:
Charles W. McBride
74-133 El Paseo, Suite 11
Palm Desert, CA 92260
(760)346-5300
(760)346-7981 Fax
License # C12905

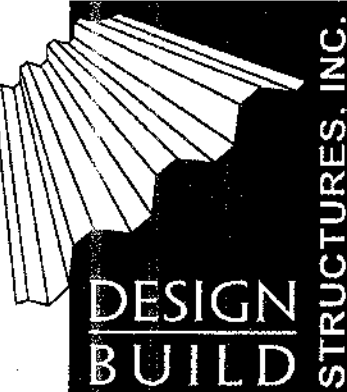





Title: Construction Documents
Date: January 15, 2004
Revised:

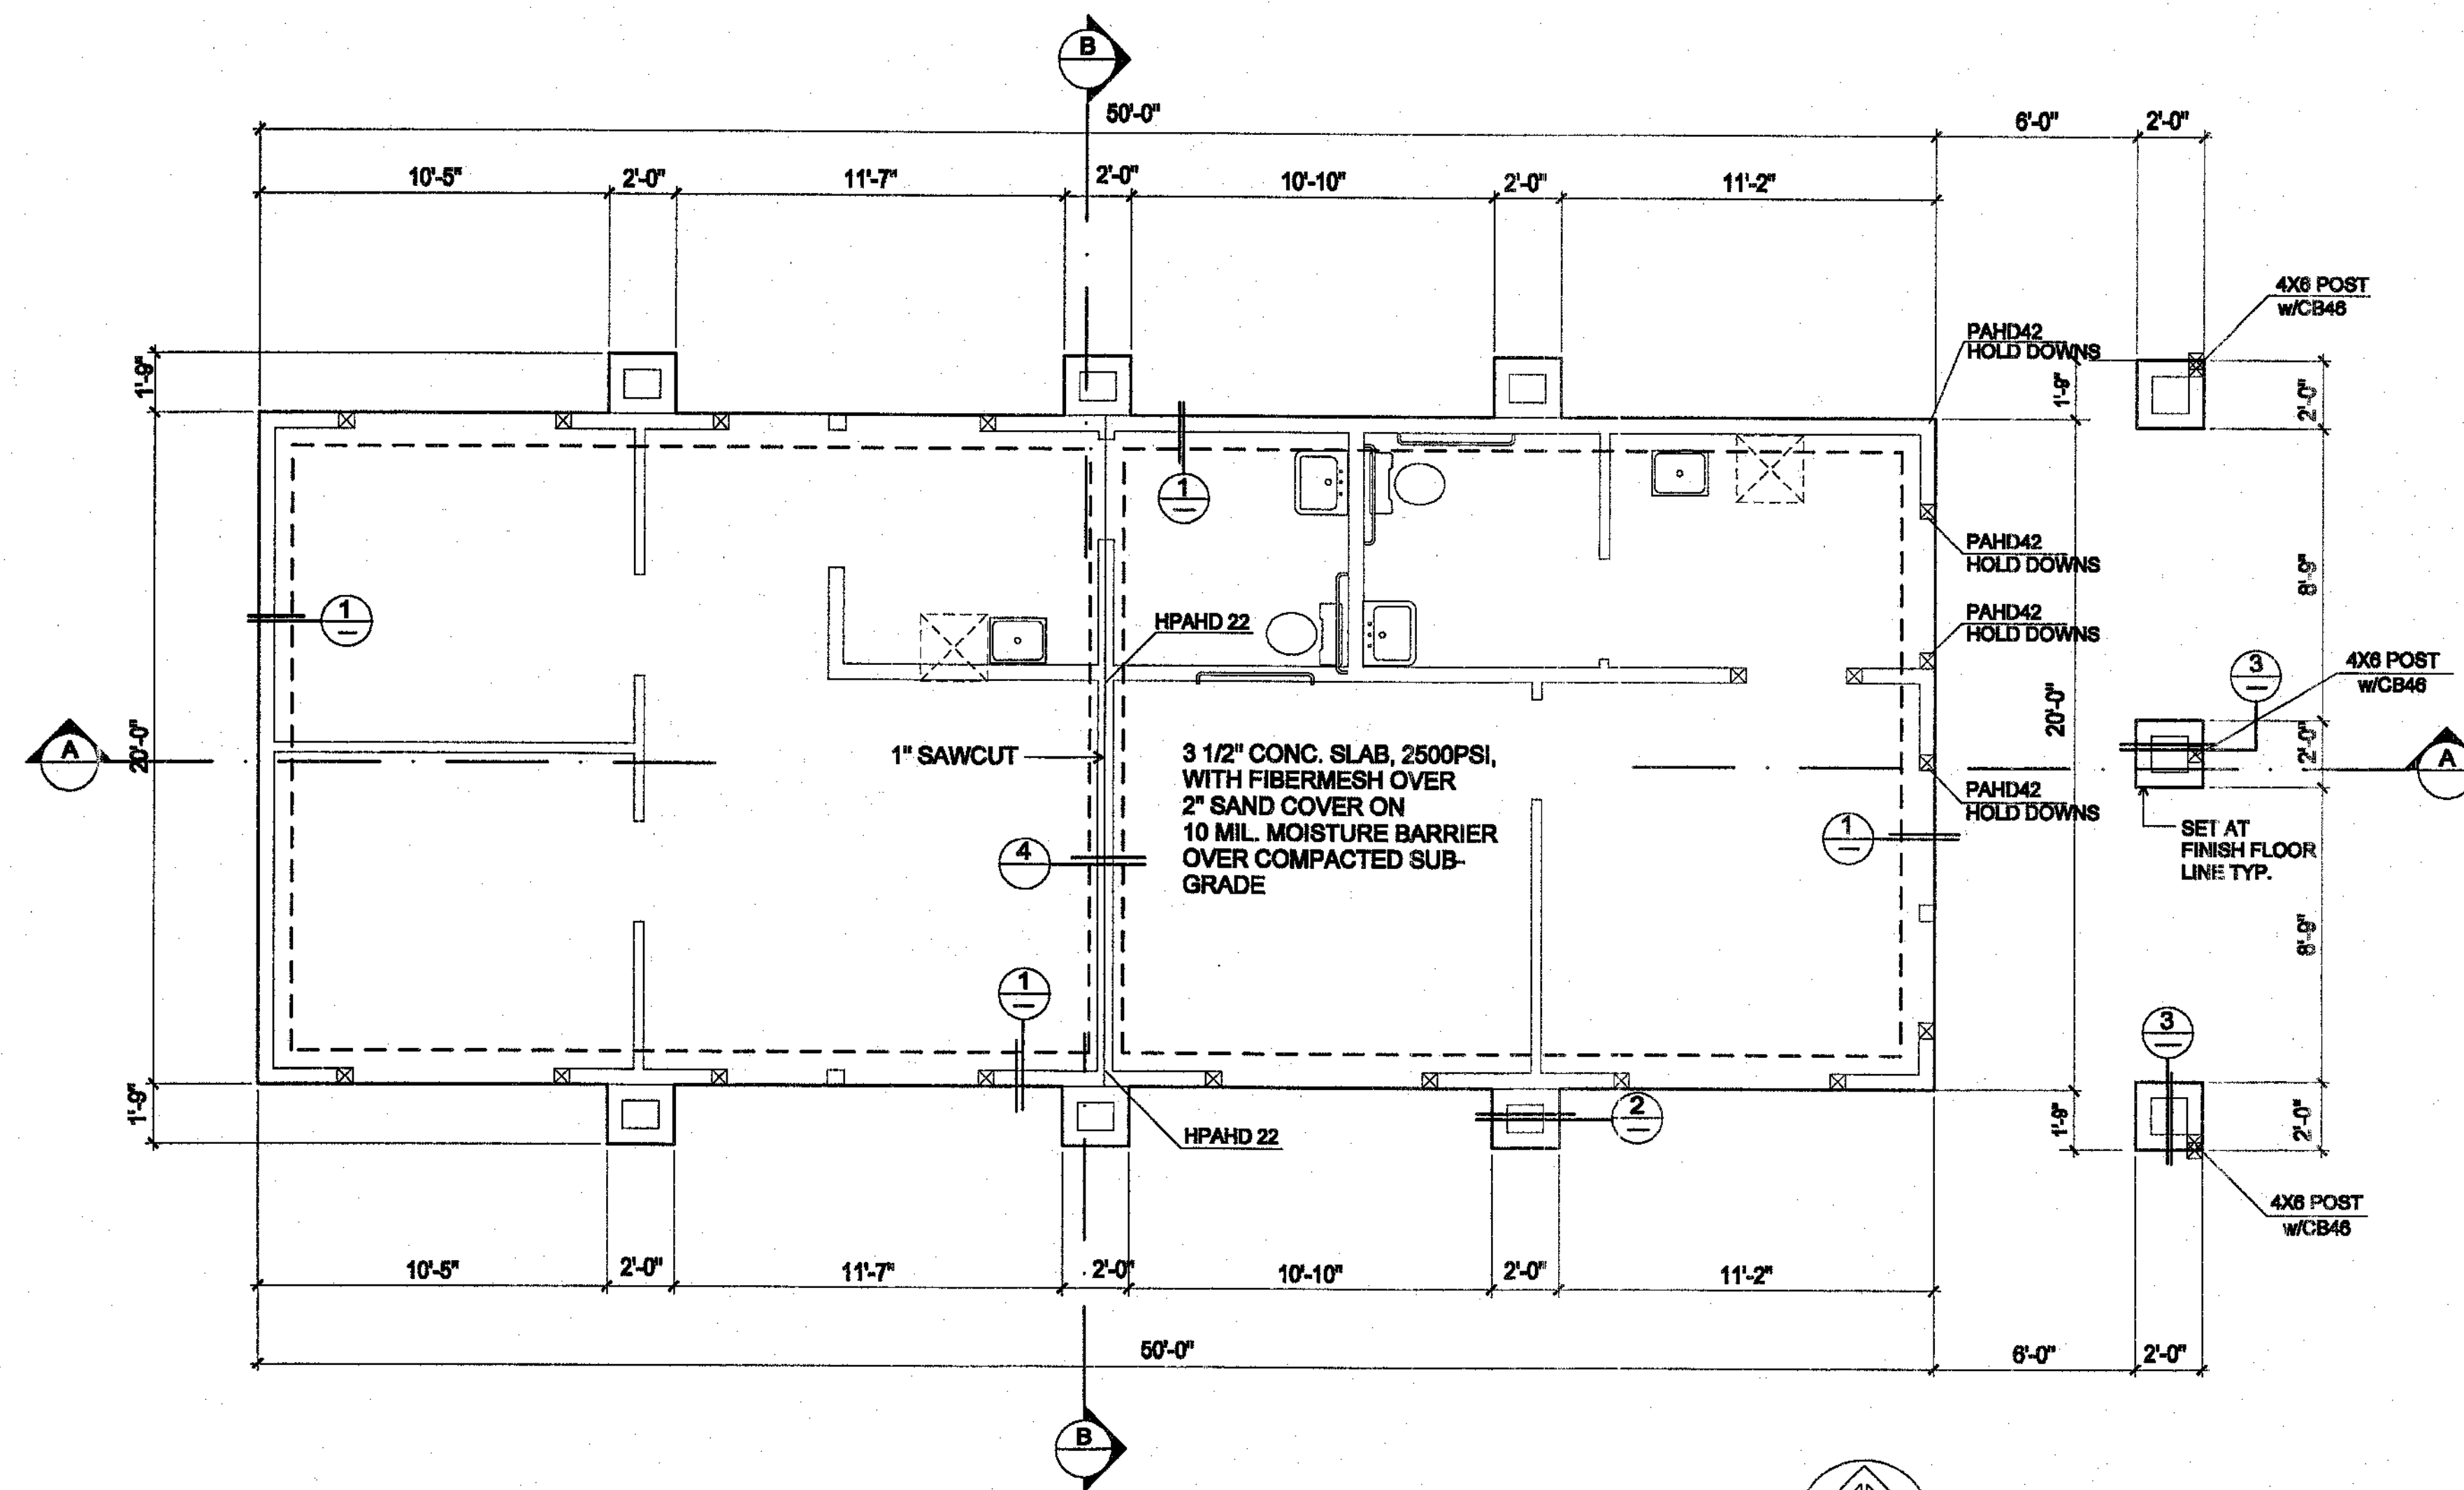

FOUNDATION PLAN 50X20 BLDG.


ALL REINFORCEMENT STEEL #4 AND LARGER SHALL BE 24,000PSI, GRADE 60

SCALE: 1/4" = 1'-0"

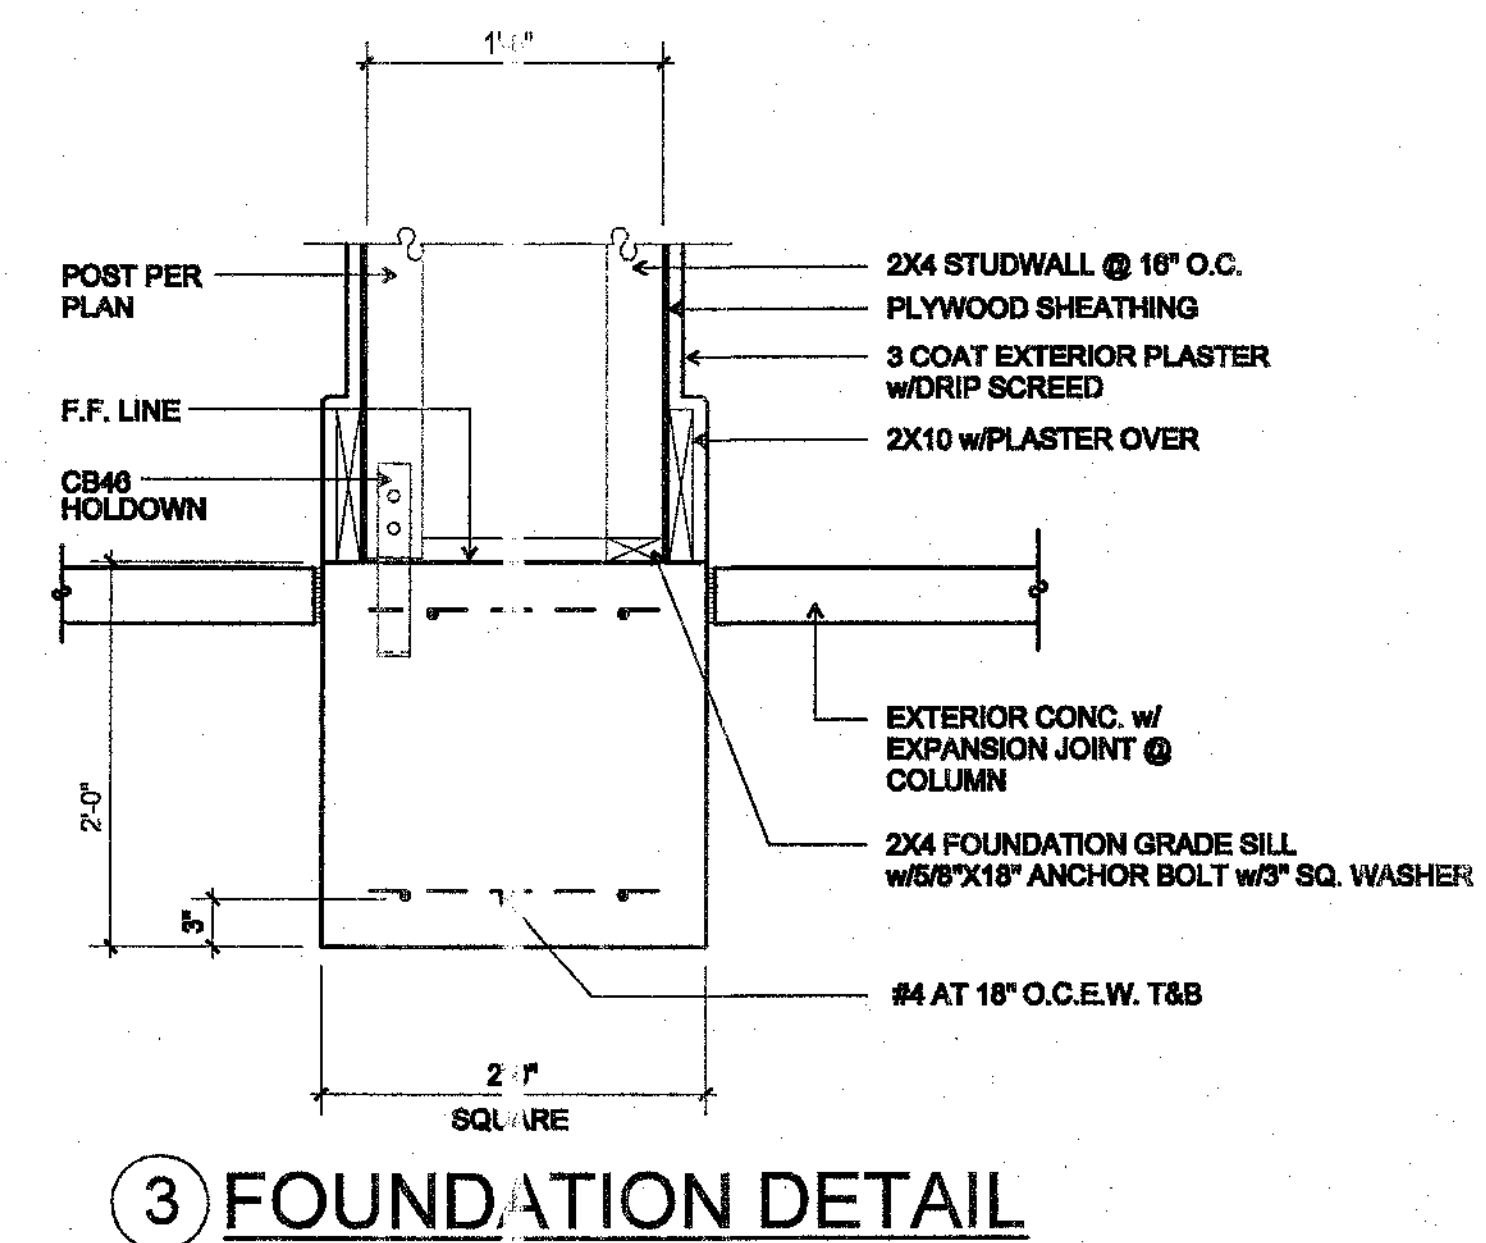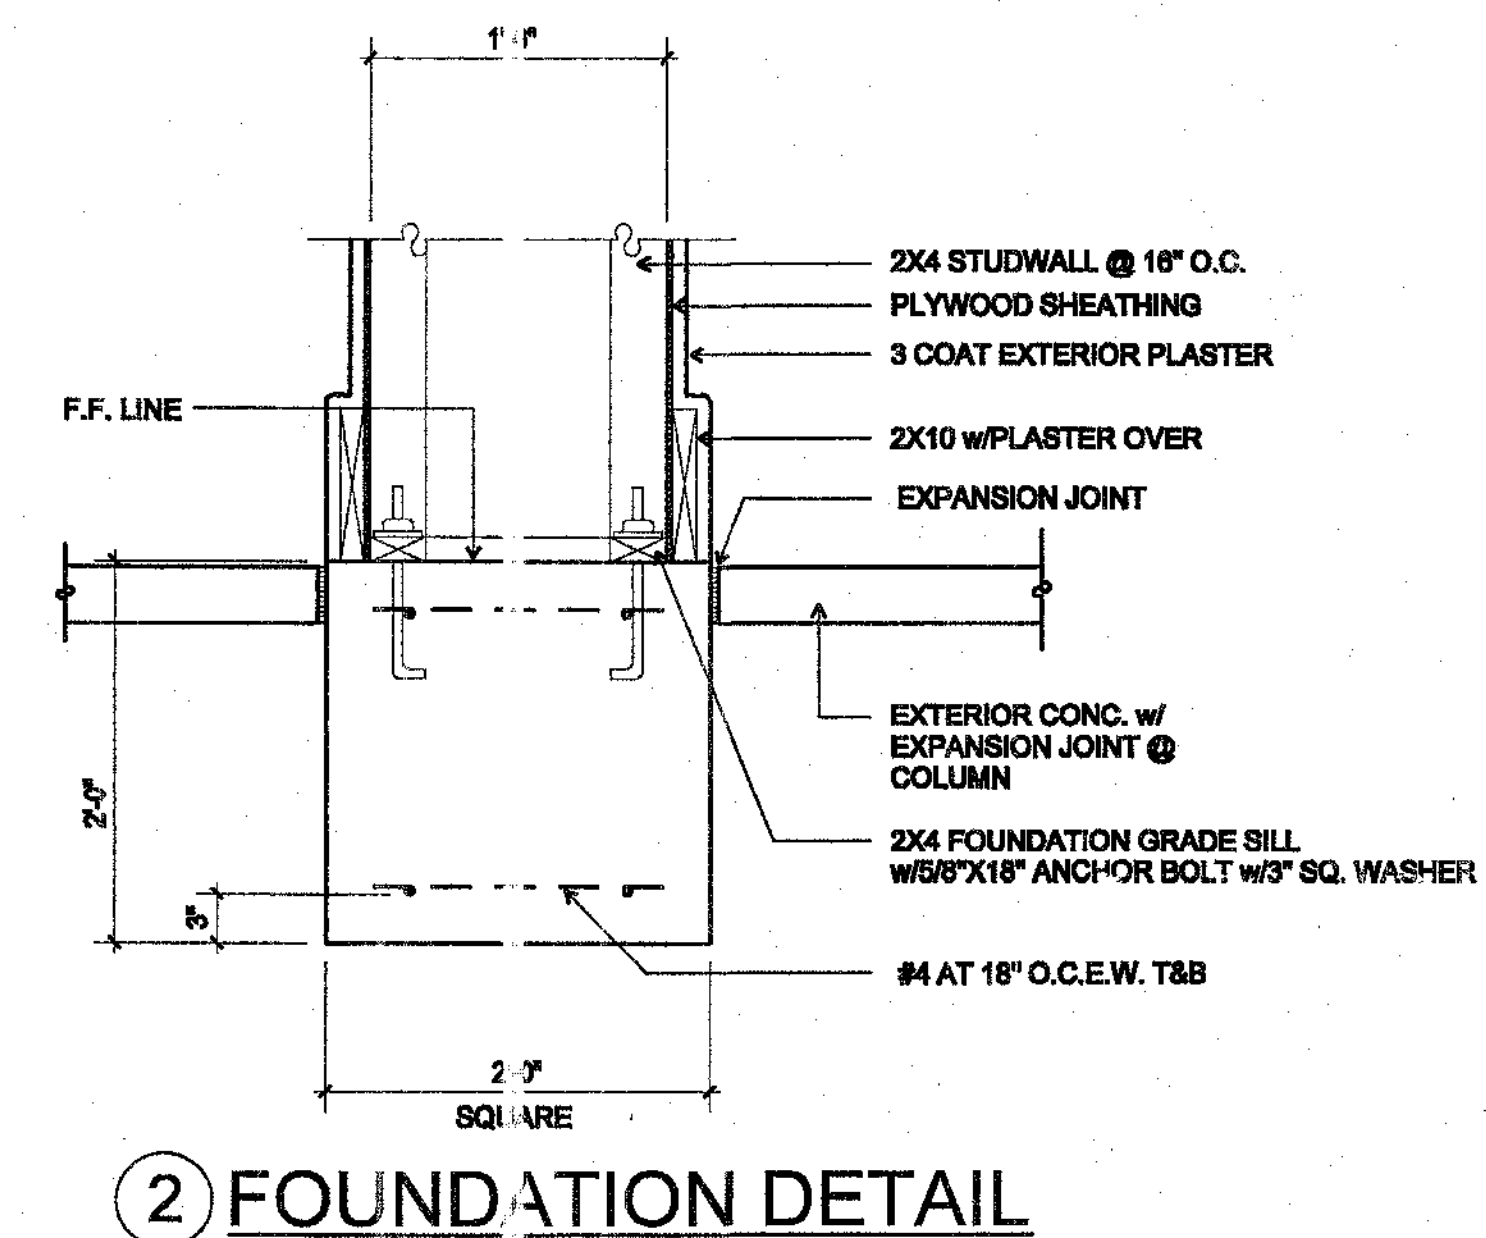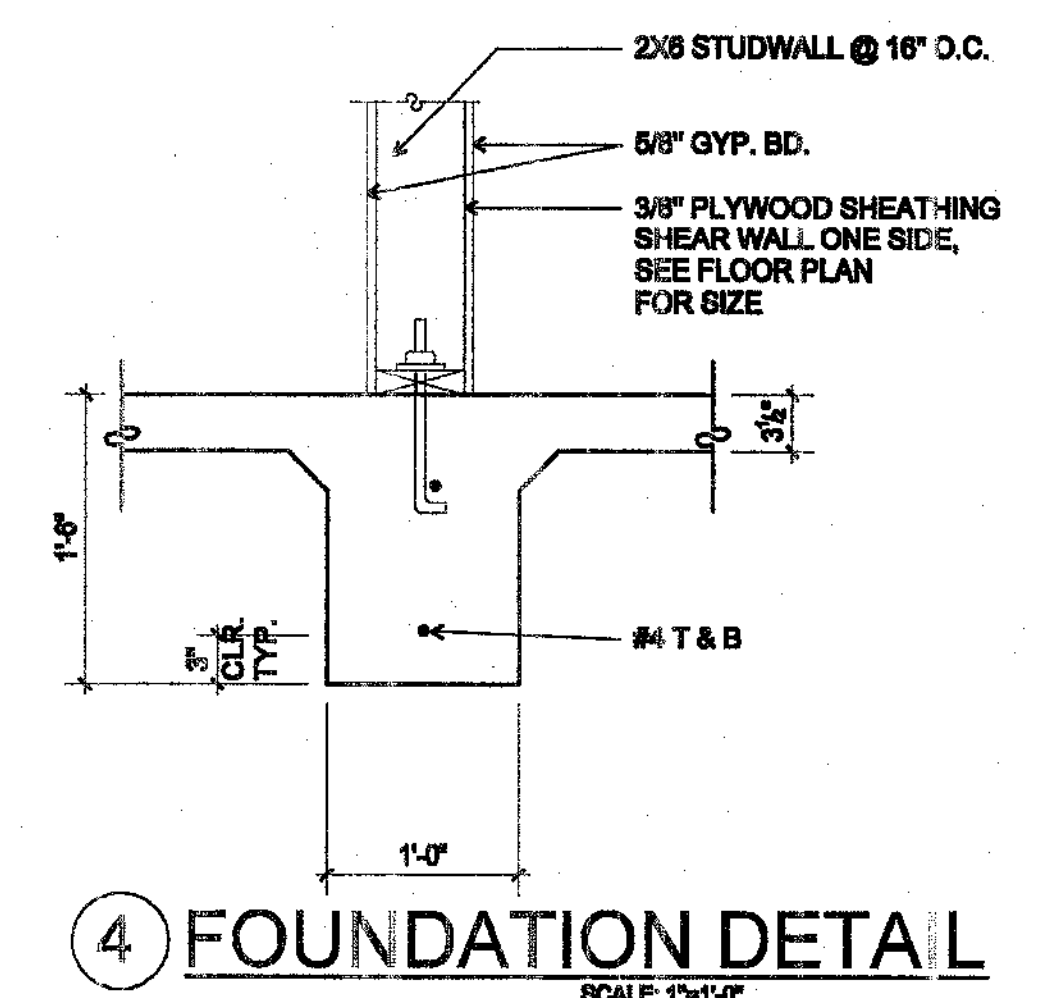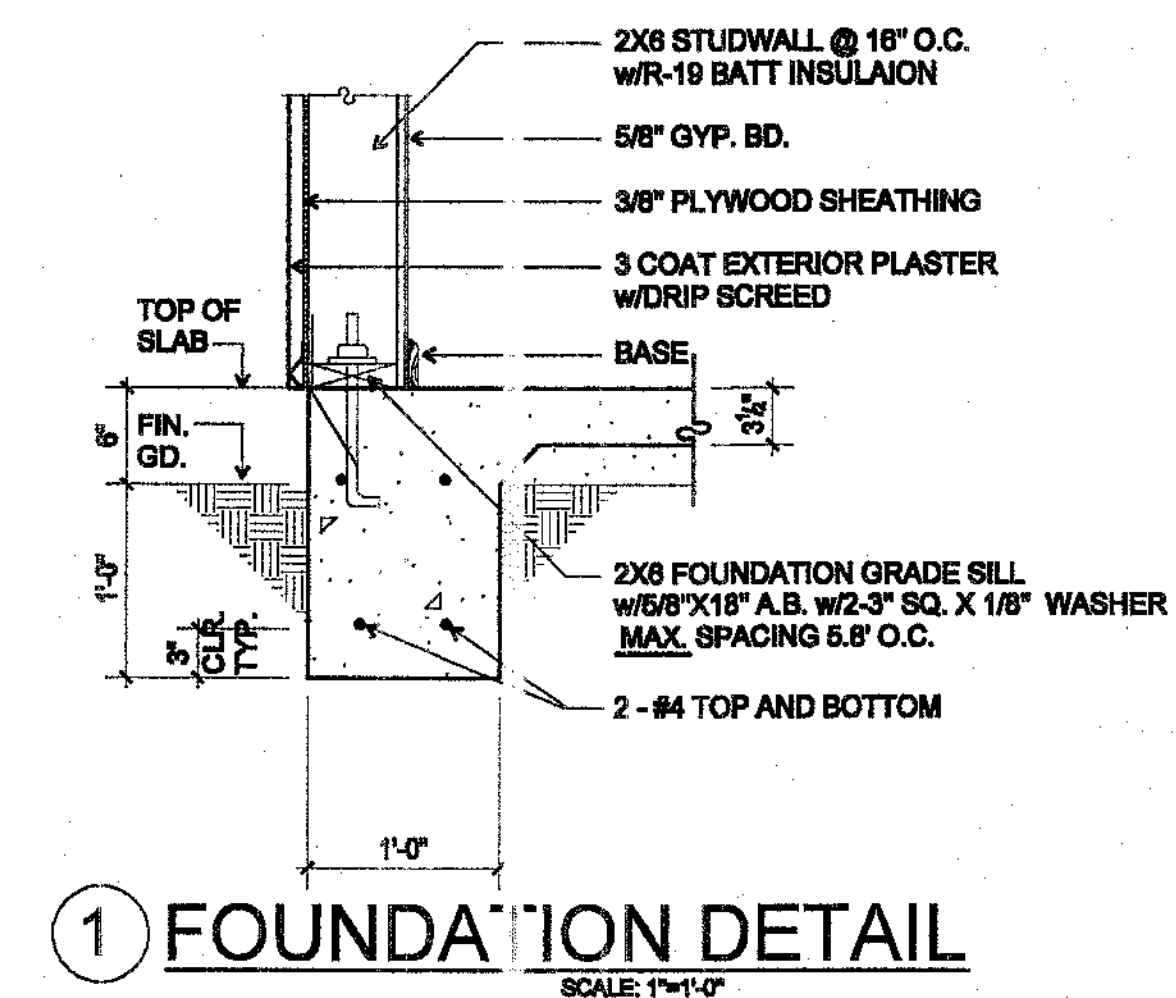


An Office and Storage Facility for:
James Hanousek
Trader Place
Indio, California

Architect:
Charles W. McBride
74-133 El Paseo, Suite 11
Palm Desert, CA 92260
(760)346-5300
(760)346-7981 Fax
License # C12905

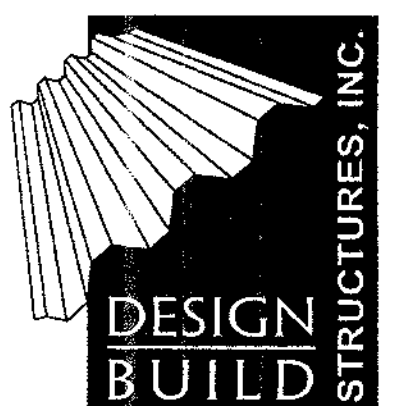

Title: Construction Documents
Date: January 15, 2004
Revised:

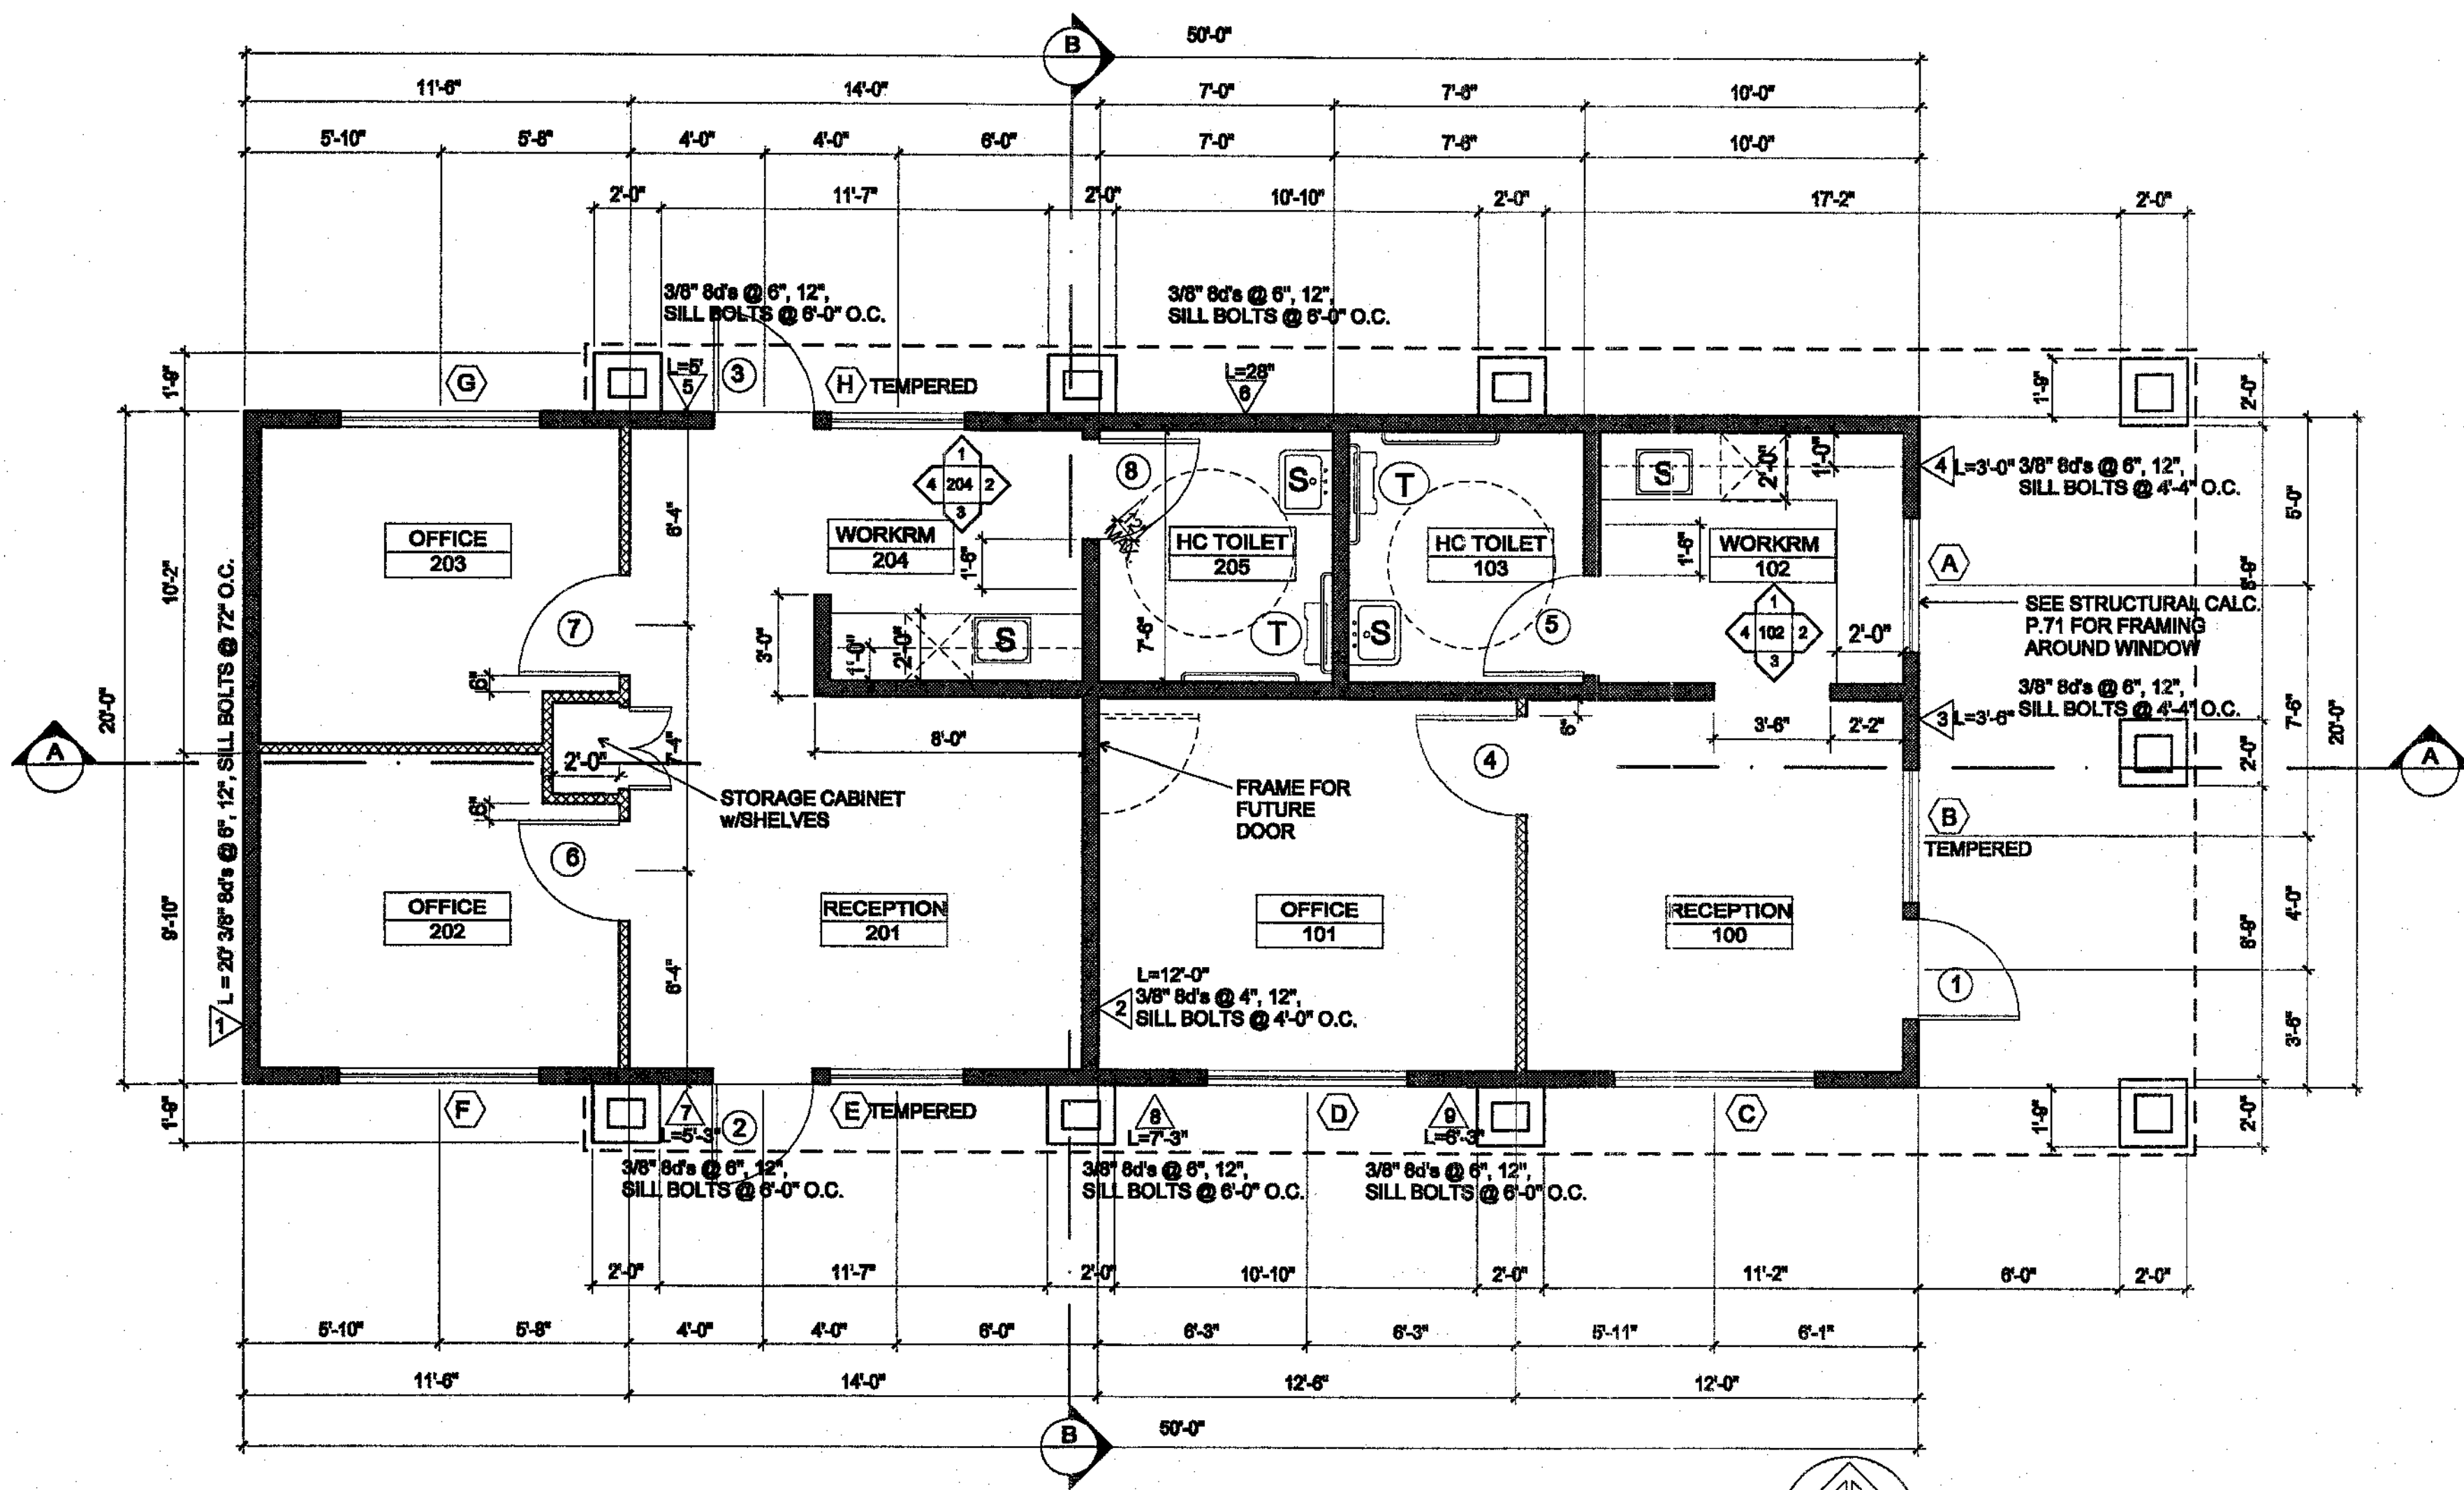

Window Schedule					
Window	Size	Frame	Sliding with Screen	Glazing	Tint
A	4030	Aluminum	Yes	Dual	Grey
B	4040	Aluminum	Yes	Dual	Grey
C	6040	Aluminum	Yes	Dual	Grey
D	6040	Aluminum	Yes	Dual	Grey
E	4040	Aluminum	Yes	Dual	Grey
F	6040	Aluminum	Yes	Dual	Grey
G	6040	Aluminum	Yes	Dual	Grey
H	4040	Aluminum	Yes	Dual	Grey

SEE PLAN FOR TEMPERED

- Toilet Accessories**
- Per handicap toilet room
- (1) 36" stainless steel grab bar
 - (1) 42" stainless steel grab bar
 - (1) toilet paper dispenser
 - (1) paper towel dispenser
 - (1) toilet seat cover dispenser
 - (1) soap dispenser
 - (1) 24 x 36 mirror
 - (1) unisex door signage


Room Finish Schedule								
Room Number	Height	Ceiling Material	Floor Material	Wall 1	Wall 2	Wall 3	Wall 4	Base
100	8'	Gypsum board	Vinyl	Gypsum board	Gypsum board	Gypsum board	Gypsum board	Vinyl
101	8'	Gypsum board	Carpet	Gypsum board	Gypsum board	Gypsum board	Gypsum board	Vinyl
102	8'	Gypsum board	Vinyl	Gypsum board	Gypsum board	Gypsum board	Gypsum board	Vinyl
103	8'	Gypsum board	Vinyl	Green bd./ FRP	Green bd./ FRP	Green bd./ FRP	Green bd./ FRP	Vinyl
201	8'	Gypsum board	Vinyl	Gypsum board	Gypsum board	Gypsum board	Gypsum board	Vinyl
202	8'	Gypsum board	Carpet	Gypsum board	Gypsum board	Gypsum board	Gypsum board	Vinyl
203	8'	Gypsum board	Carpet	Gypsum board	Gypsum board	Gypsum board	Gypsum board	Vinyl
204	8'	Gypsum board	Vinyl	Gypsum board	Gypsum board	Gypsum board	Gypsum board	Vinyl
205	8'	Gypsum board	Vinyl	Green bd./ FRP	Green bd./ FRP	Green bd./ FRP	Green bd./ FRP	Vinyl

Door Schedule										
Number	Type	Door Size	Core	Frame	Hinges	Weatherstrip	Threshold	Sweep	Lockset	Signage
Door 1	Wood	3068 x 1 1/4	Solid	Wood	1 1/2 pair, ball bearing, NRP, paint grade	surface mounted, bulb-type, jamba and head	handicap	Yes	Schlage D53PD, lever type	Schlage, double cylinder
2	Wood	3068 x 1 1/4	Solid	Wood	1 1/2 pair, ball bearing, NRP, paint grade	surface mounted, bulb-type, jamba and head	handicap	Yes	Schlage D53PD, lever type	Schlage, double cylinder
3	Wood	3068 x 1 1/4	Solid	Wood	1 1/2 pair, ball bearing, NRP, paint grade	surface mounted, bulb-type, jamba and head	handicap	Yes	Schlage D53PD, lever type	Schlage, double cylinder
4	Wood	3068 x 1 1/4	Solid	Metal	1 1/2 pair, paint grade	No	No	No	Schlage passage, lever type	No
5	Wood	3068 x 1 1/4	Solid	Metal	1 1/2 pair, paint grade	No	No	No	Schlage bath, lever type	No
6	Wood	3068 x 1 1/4	Solid	Metal	1 1/2 pair, paint grade	No	No	No	Schlage passage, lever type	No
7	Wood	3068 x 1 1/4	Solid	Metal	1 1/2 pair, paint grade	No	No	No	Schlage passage, lever type	No
8	Wood	3068 x 1 1/4	Solid	Metal	1 1/2 pair, paint grade	No	No	No	Schlage bath, lever type	No


FLOOR PLAN 50X20 BLDG.

- WALL LEGEND**
- 2X6 STUDS AT 16" O.C. w/R-19 INSULATION
 - 2X4 STUDS AT 16" O.C.
 - 2X4 STUDS AT 16" O.C. w/R-11 SOUND INSULATION (OPTIONAL 2X6 WALLS)
 - SHEARWALL, PLYWOOD OR OSB STRUCTURAL PANELS


SCALE: 1/4" = 1'-0"

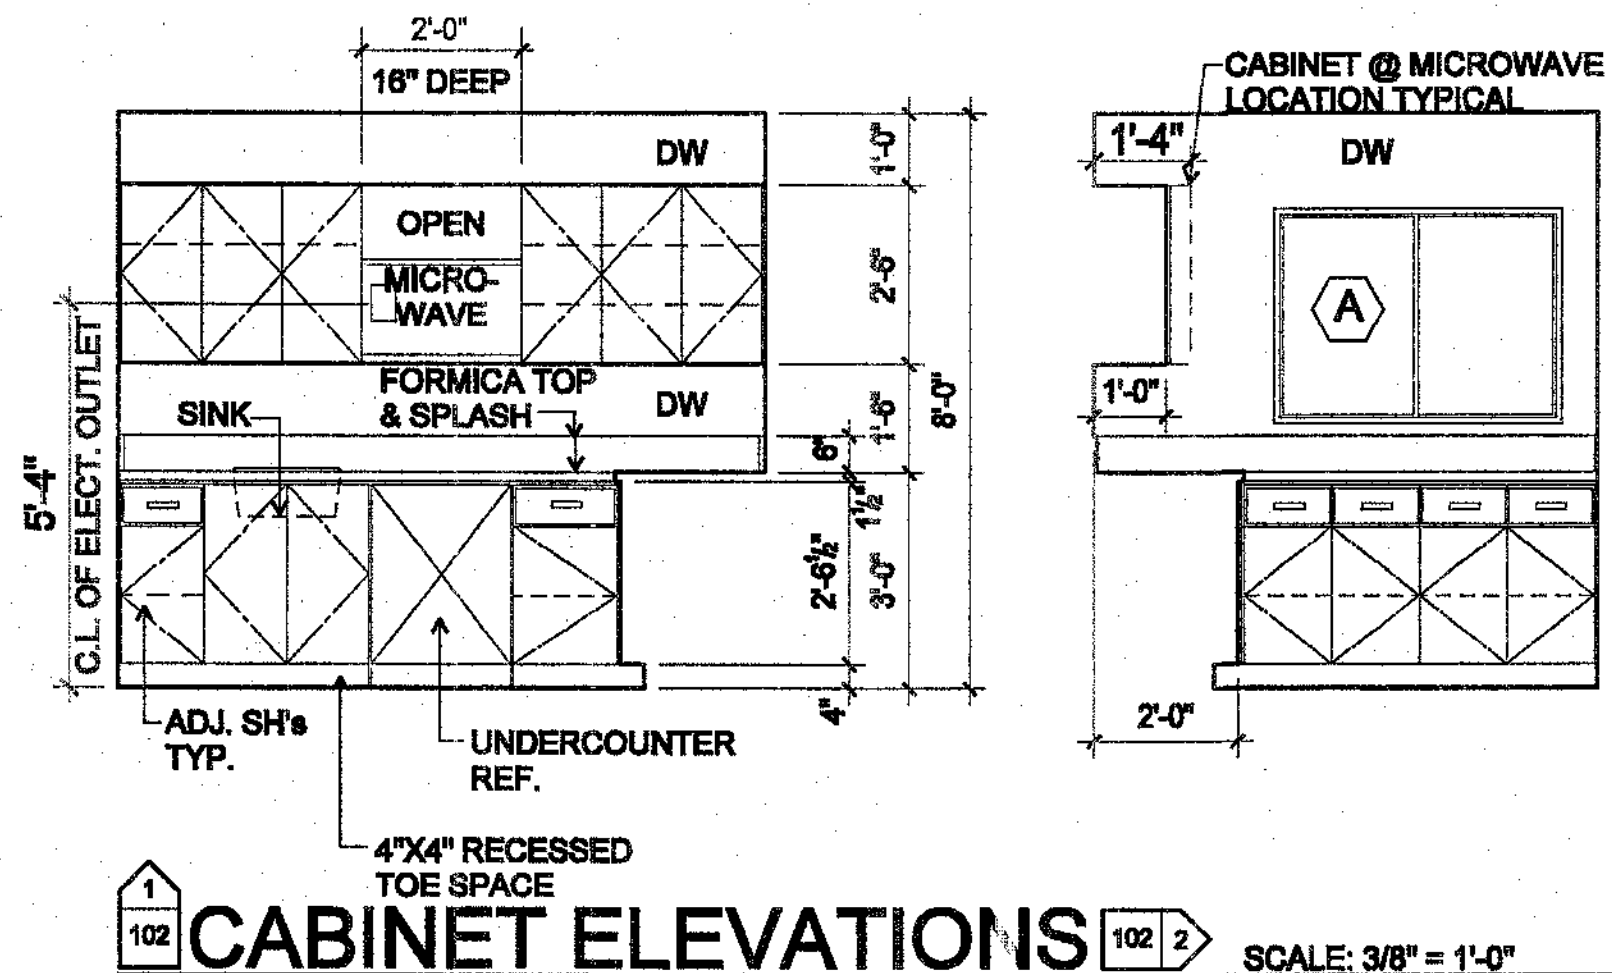


CABINET ELEVATIONS SCALE: 3/8" = 1'-0"

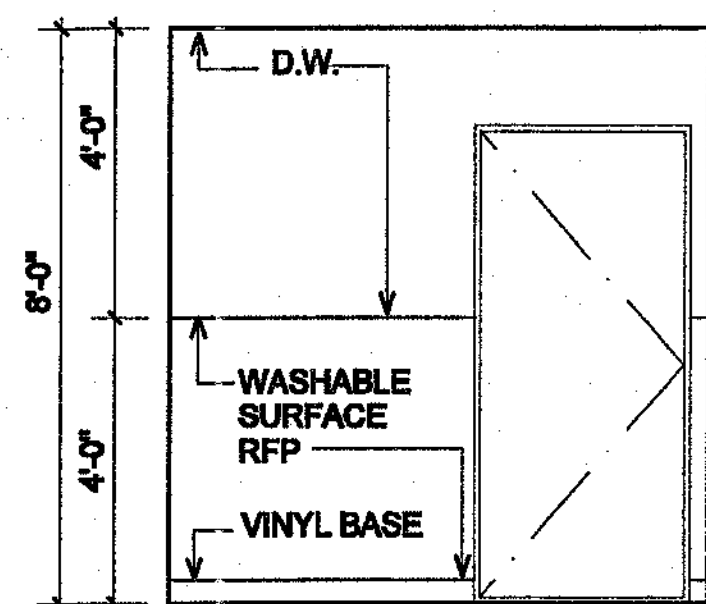


HANDICAP TOILET SCALE: 3/8" = 1'-0"

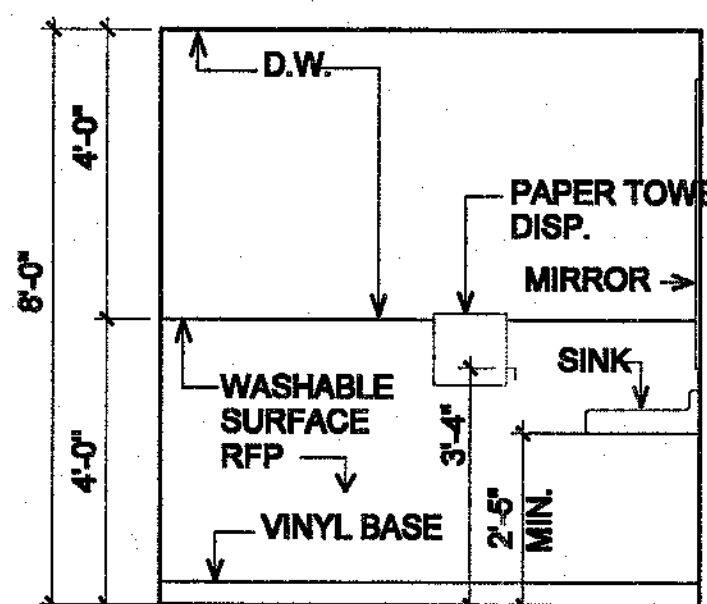


HANDICAP TOILET SCALE: 3/8" = 1'-0"

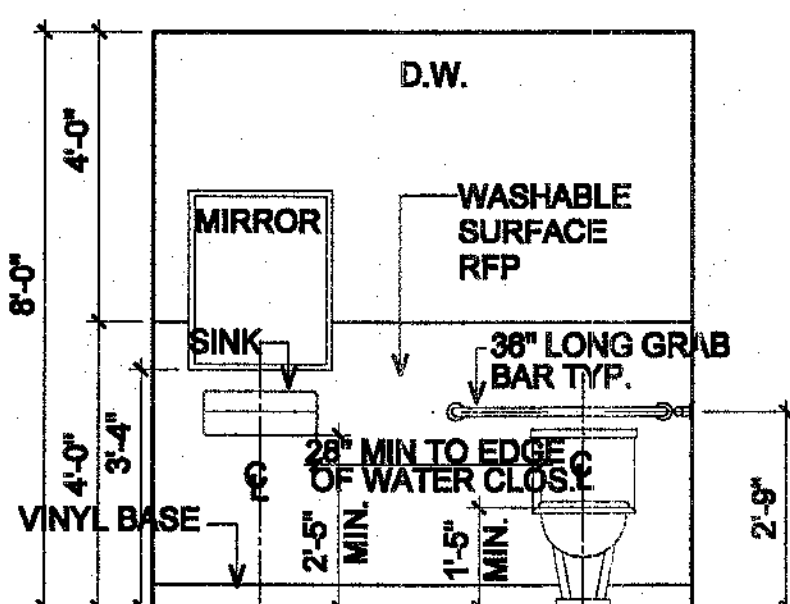

HANDICAP TOILET SCALE: 3/8" = 1'-0"

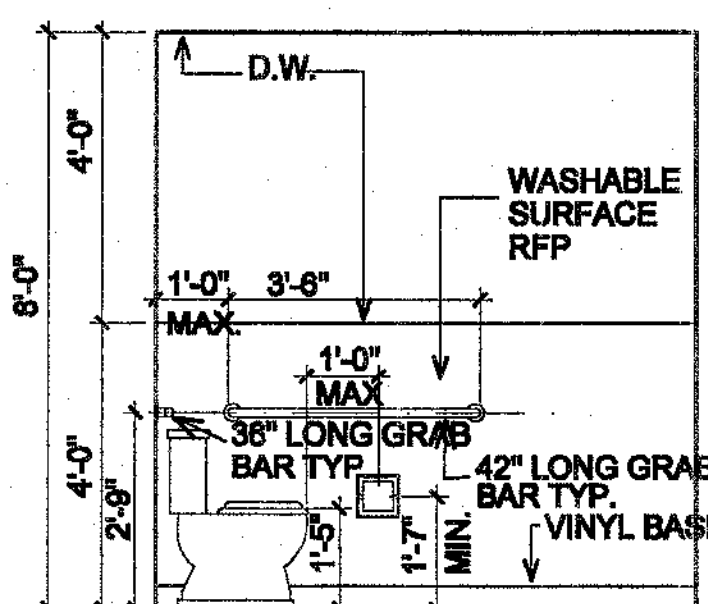

HANDICAP TOILET SCALE: 3/8" = 1'-0"

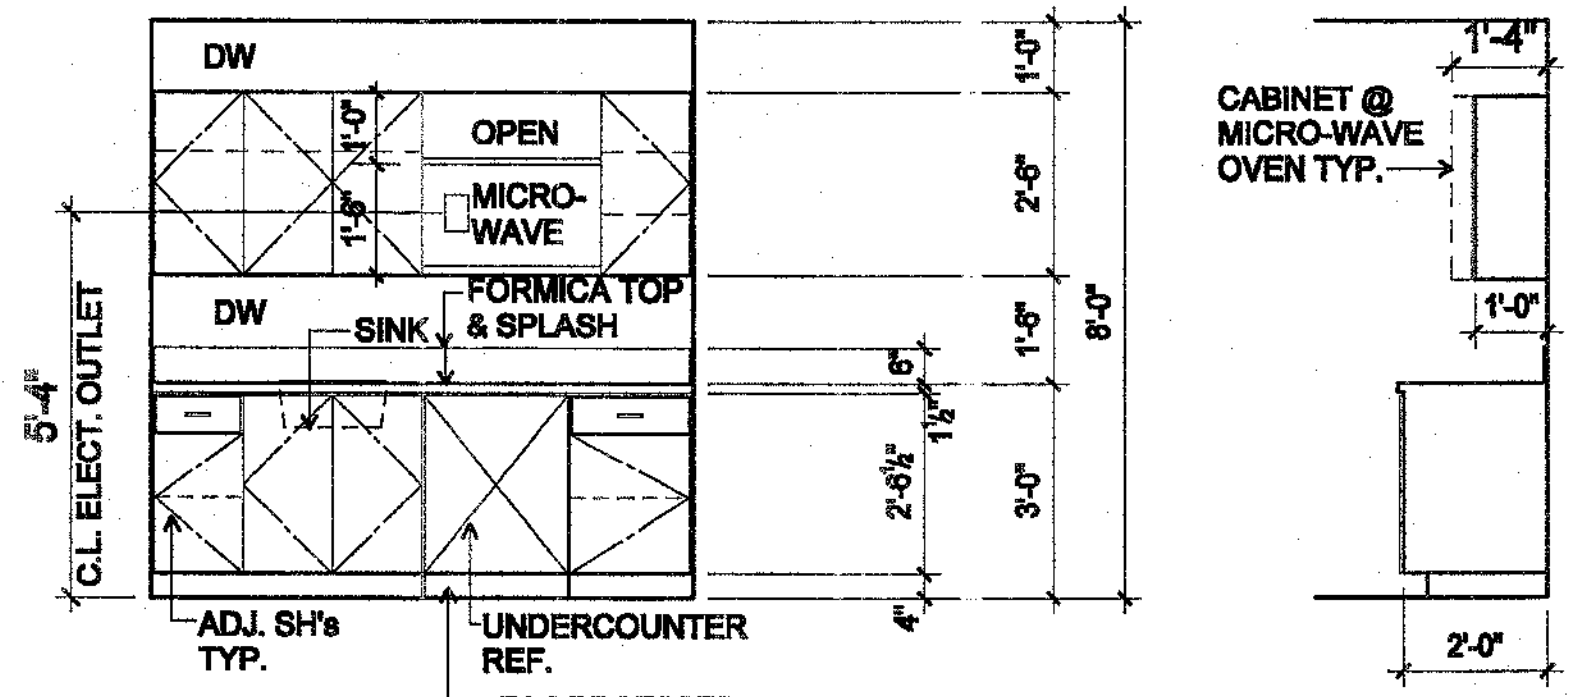

CABINET ELEVATIONS SCALE: 3/8" = 1'-0"


An Office and Storage Facility for:
James Hanousek
Trader Place
Indio, California

Architect:
Charles W. McBride
74-133 El Paseo, Suite 11
Palm Desert, CA 92260
(760)346-5300
(760)346-7981 Fax
License # C12905

DESIGN BUILD STRUCTURES, INC.


Title: Construction Documents
Date: January 15, 2004
Revised:

A.2

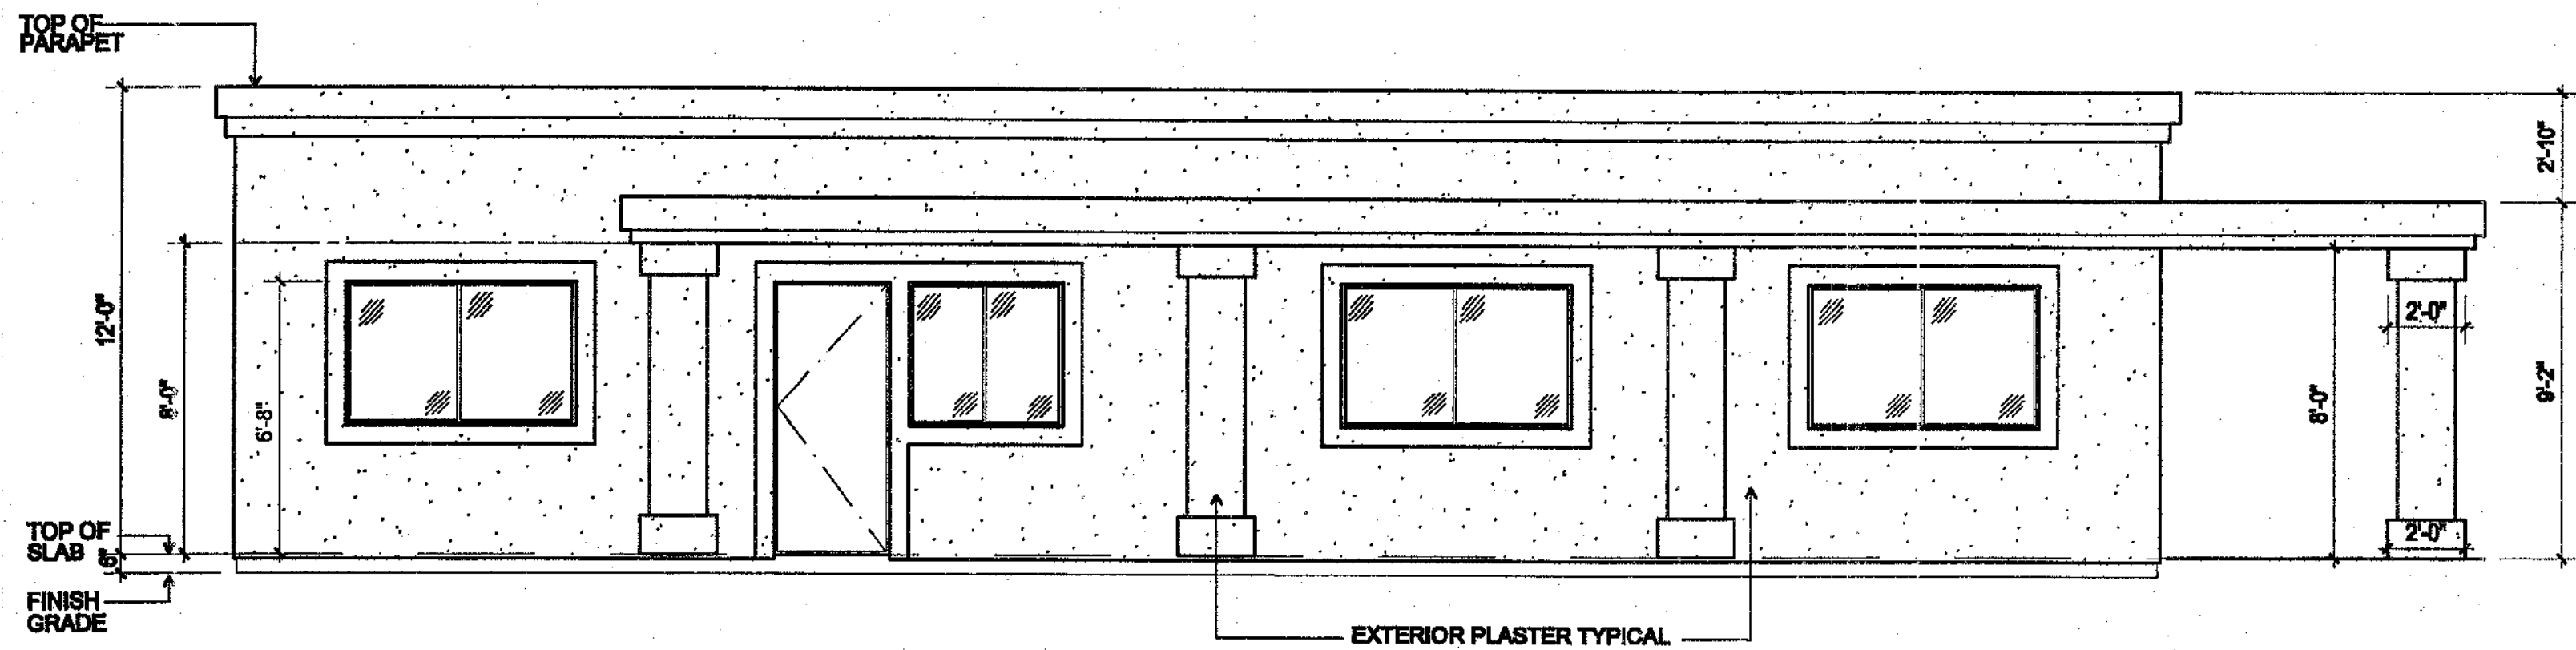


SOUTH ELEVATION

SCALE: 1/4" = 1'-0"

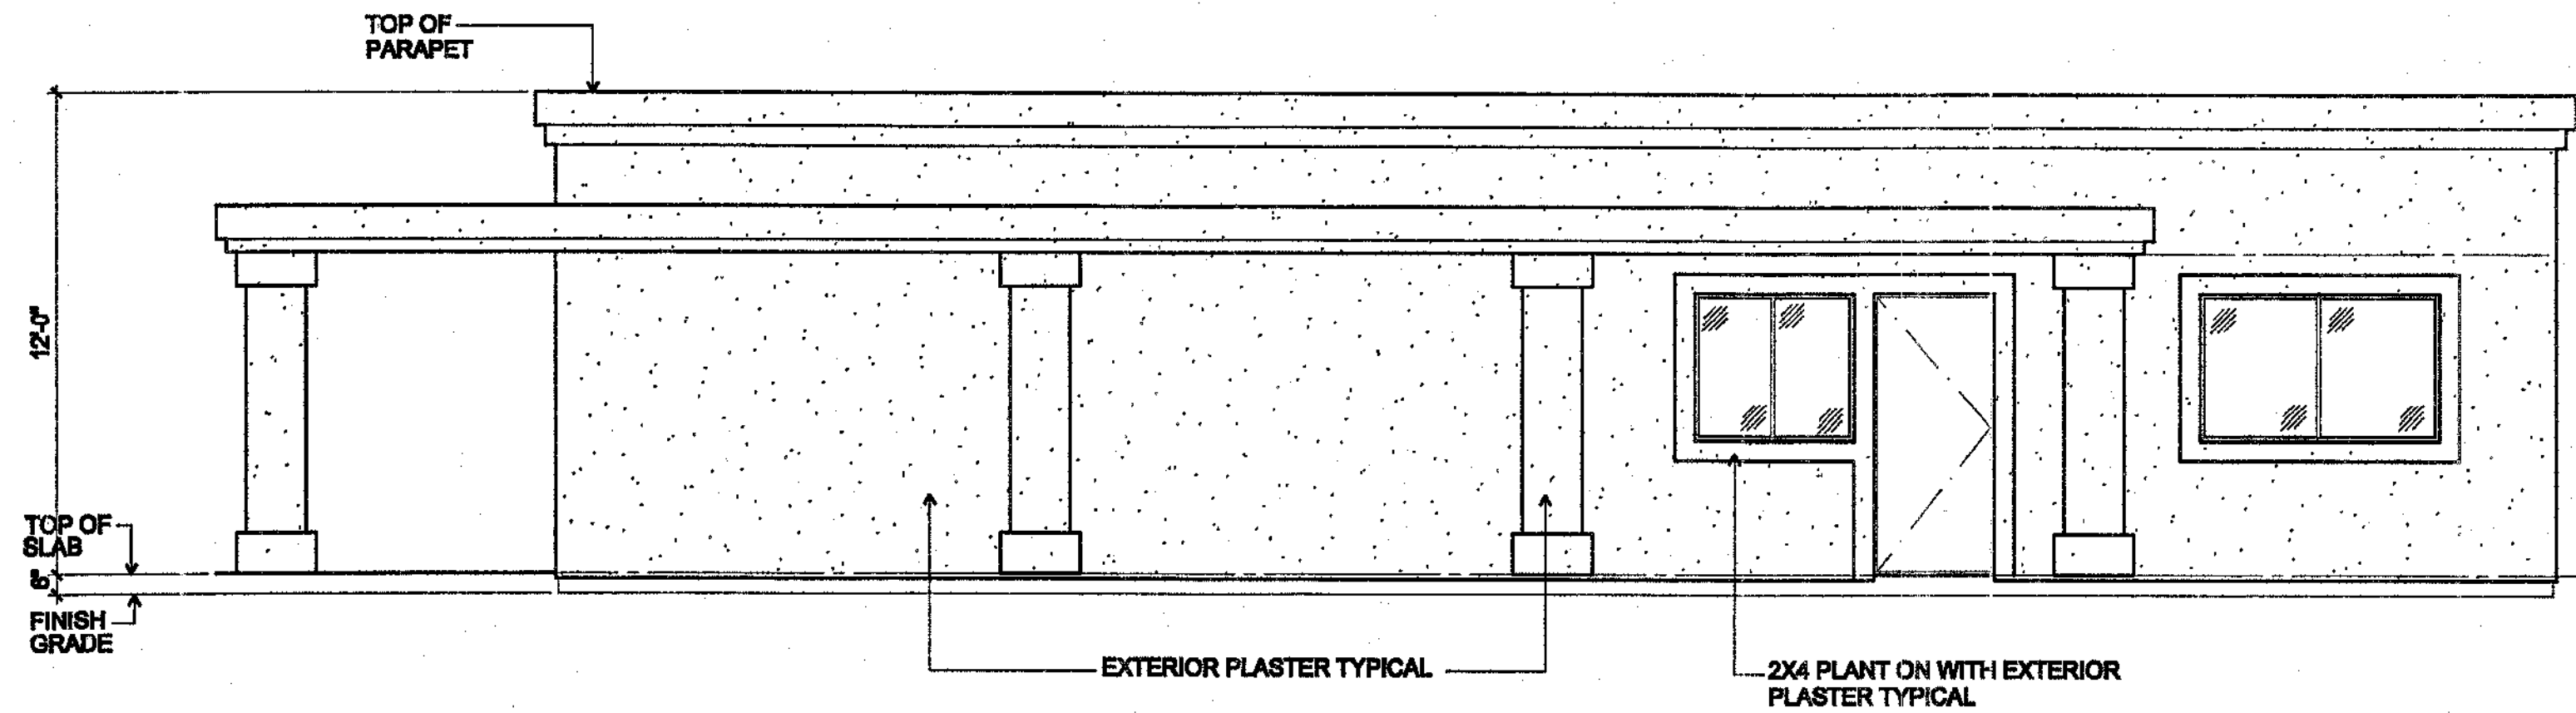


NORTH ELEVATION

SCALE: 1/4" = 1'-0"

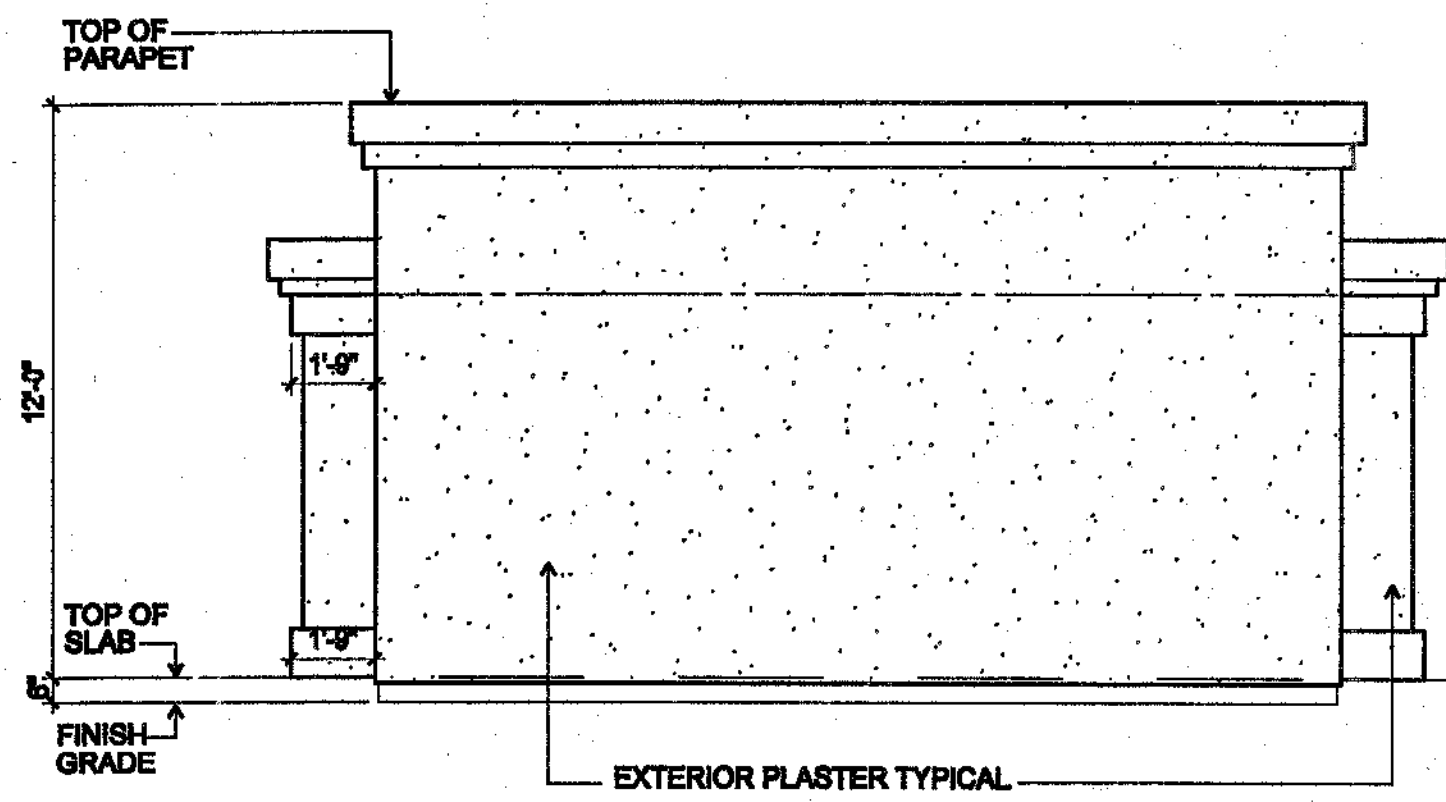


WEST ELEVATION

SCALE: 1/4" = 1'-0"

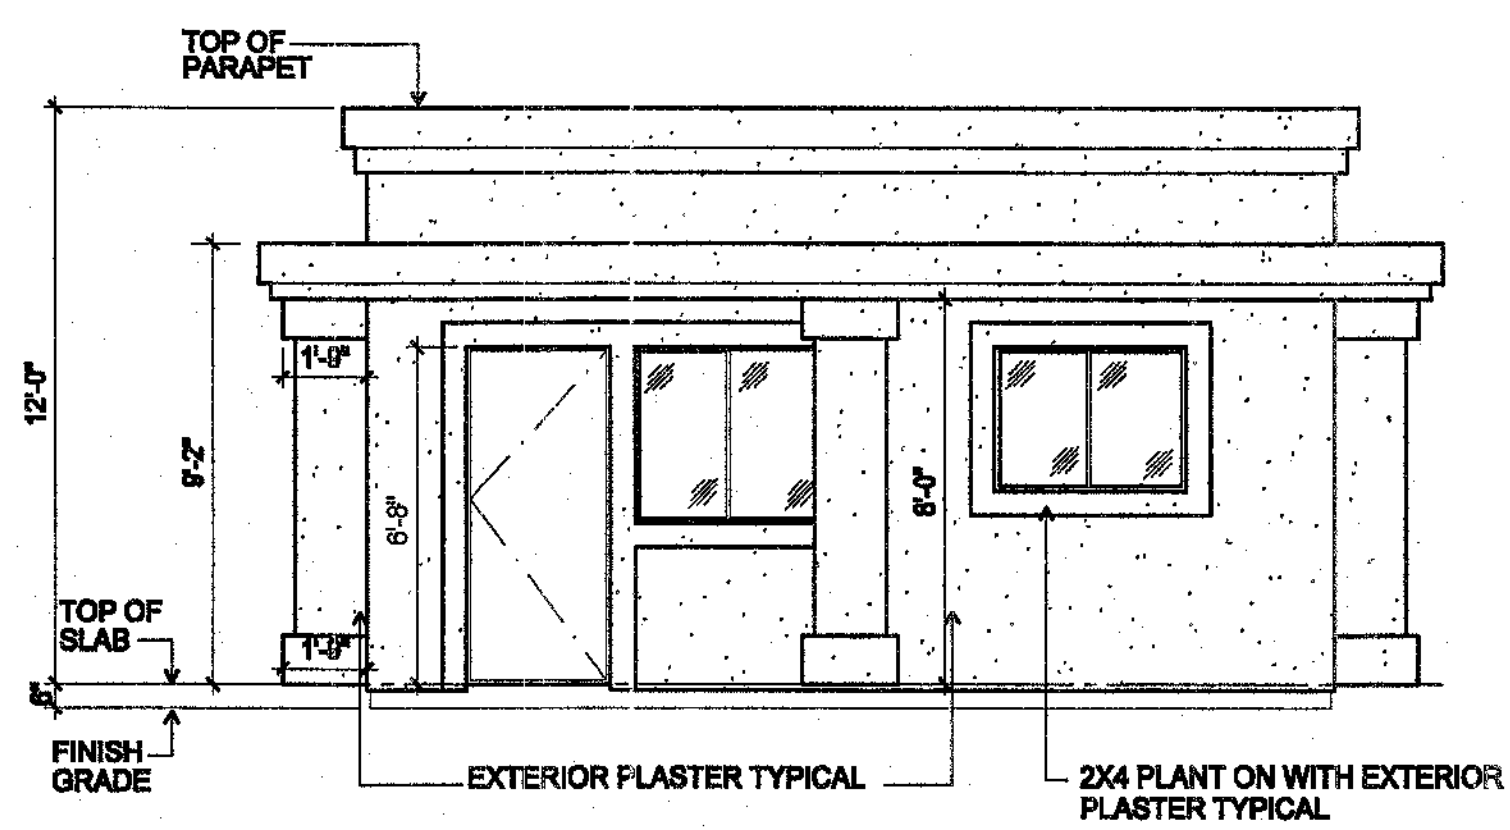


EAST ELEVATION

SCALE: 1/4" = 1'-0"

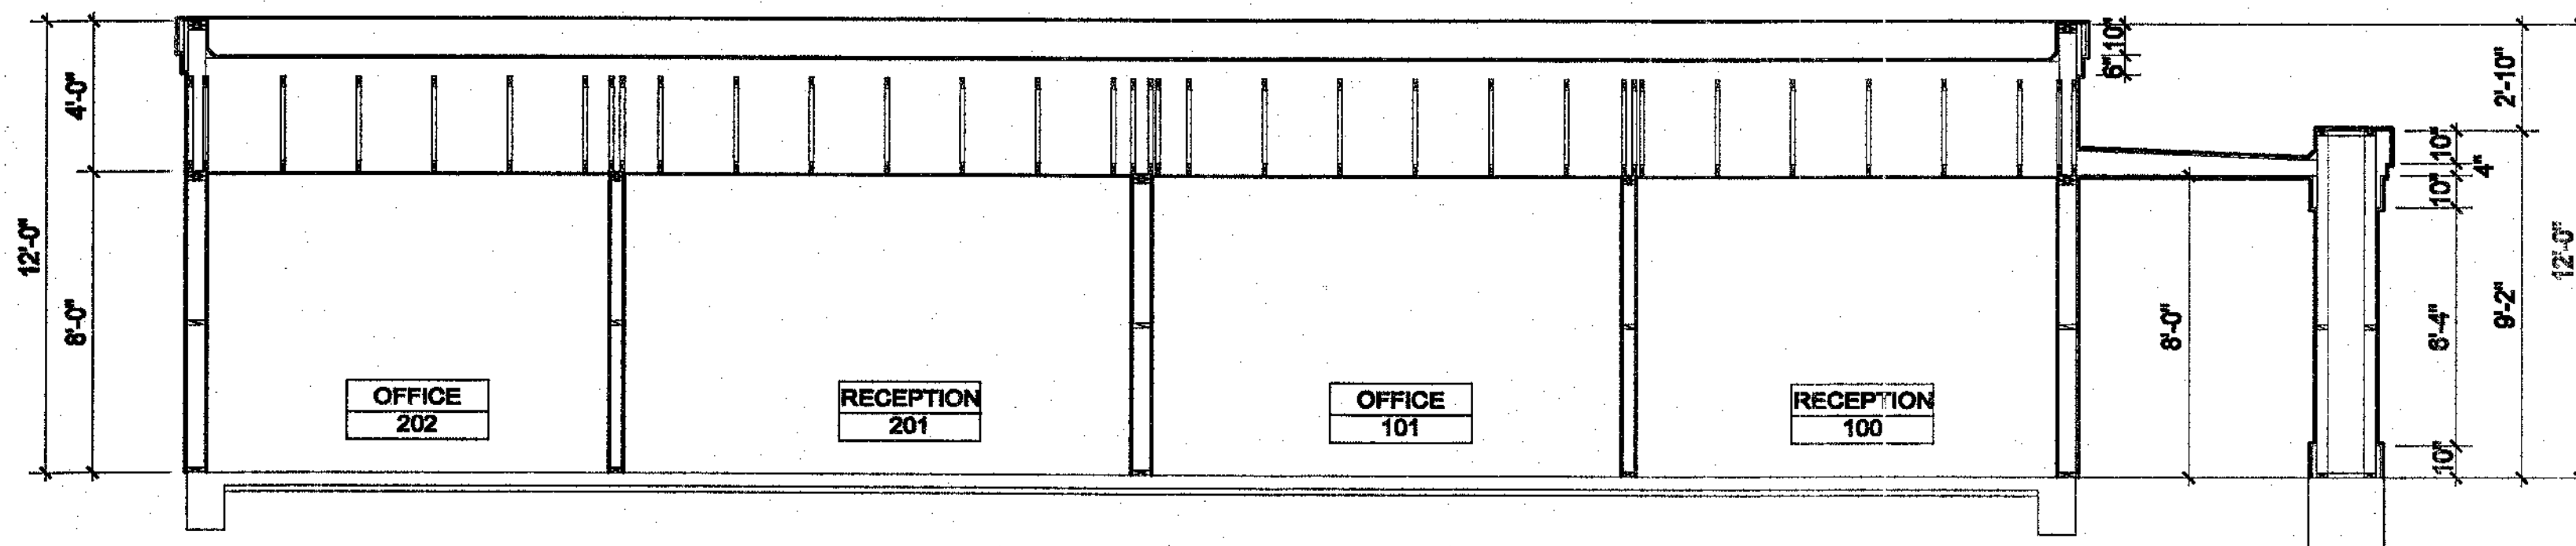

SECTION A-A

SCALE: 1/4" = 1'-0"

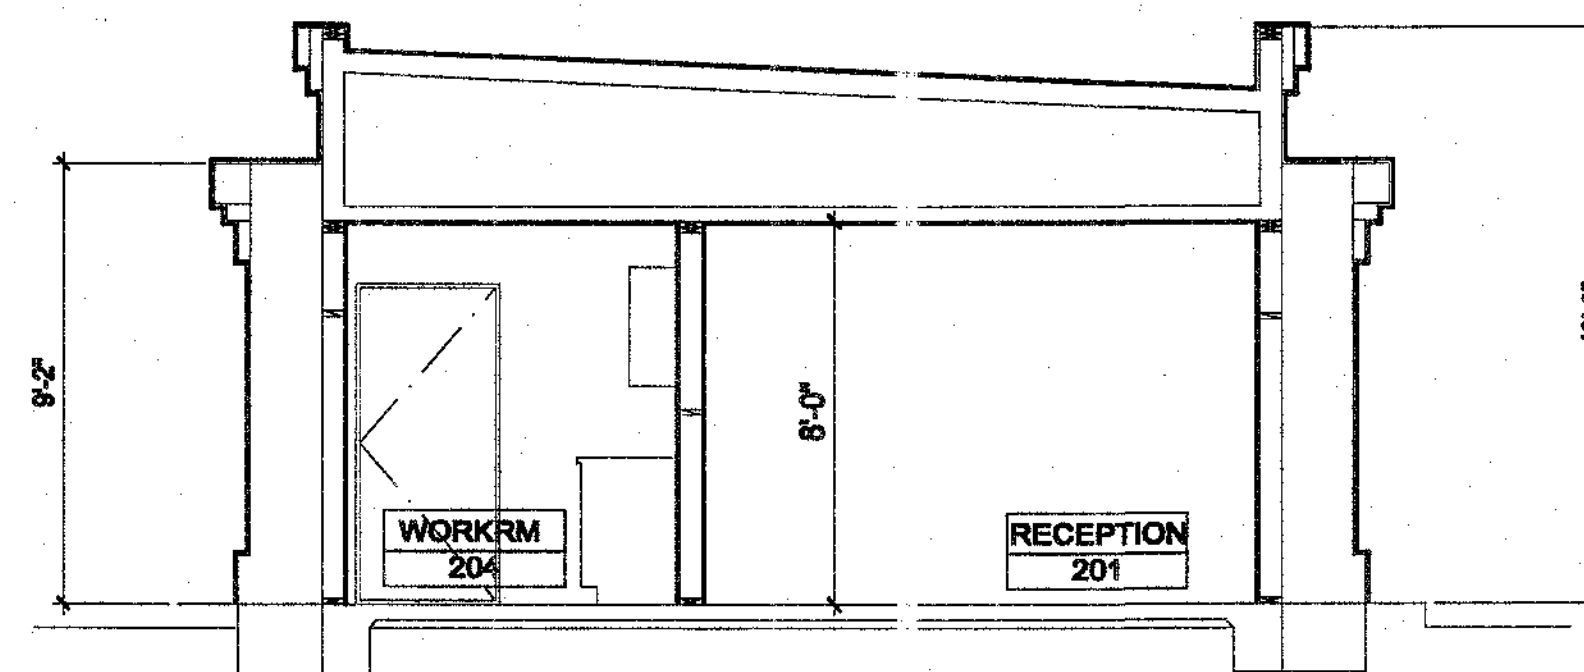


SECTION B-B


SCALE: 1/4" = 1'-0"

An Office and Storage Facility for:
James Hanousek
Trader Place
Indio, California

Architect:
Charles W. McBride
74-133 El Paseo, Suite 11
Palm Desert, CA 92260
(760)346-5300
(760)346-7981 Fax
License # C12905

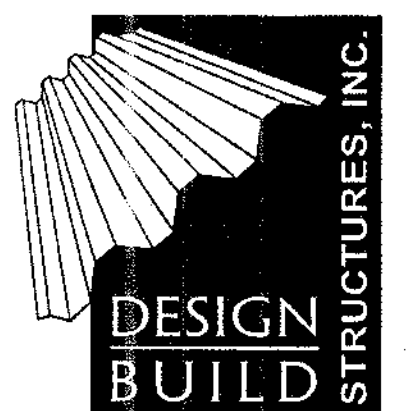


Title: Construction Documents
Date: January 15, 2004
Revised:

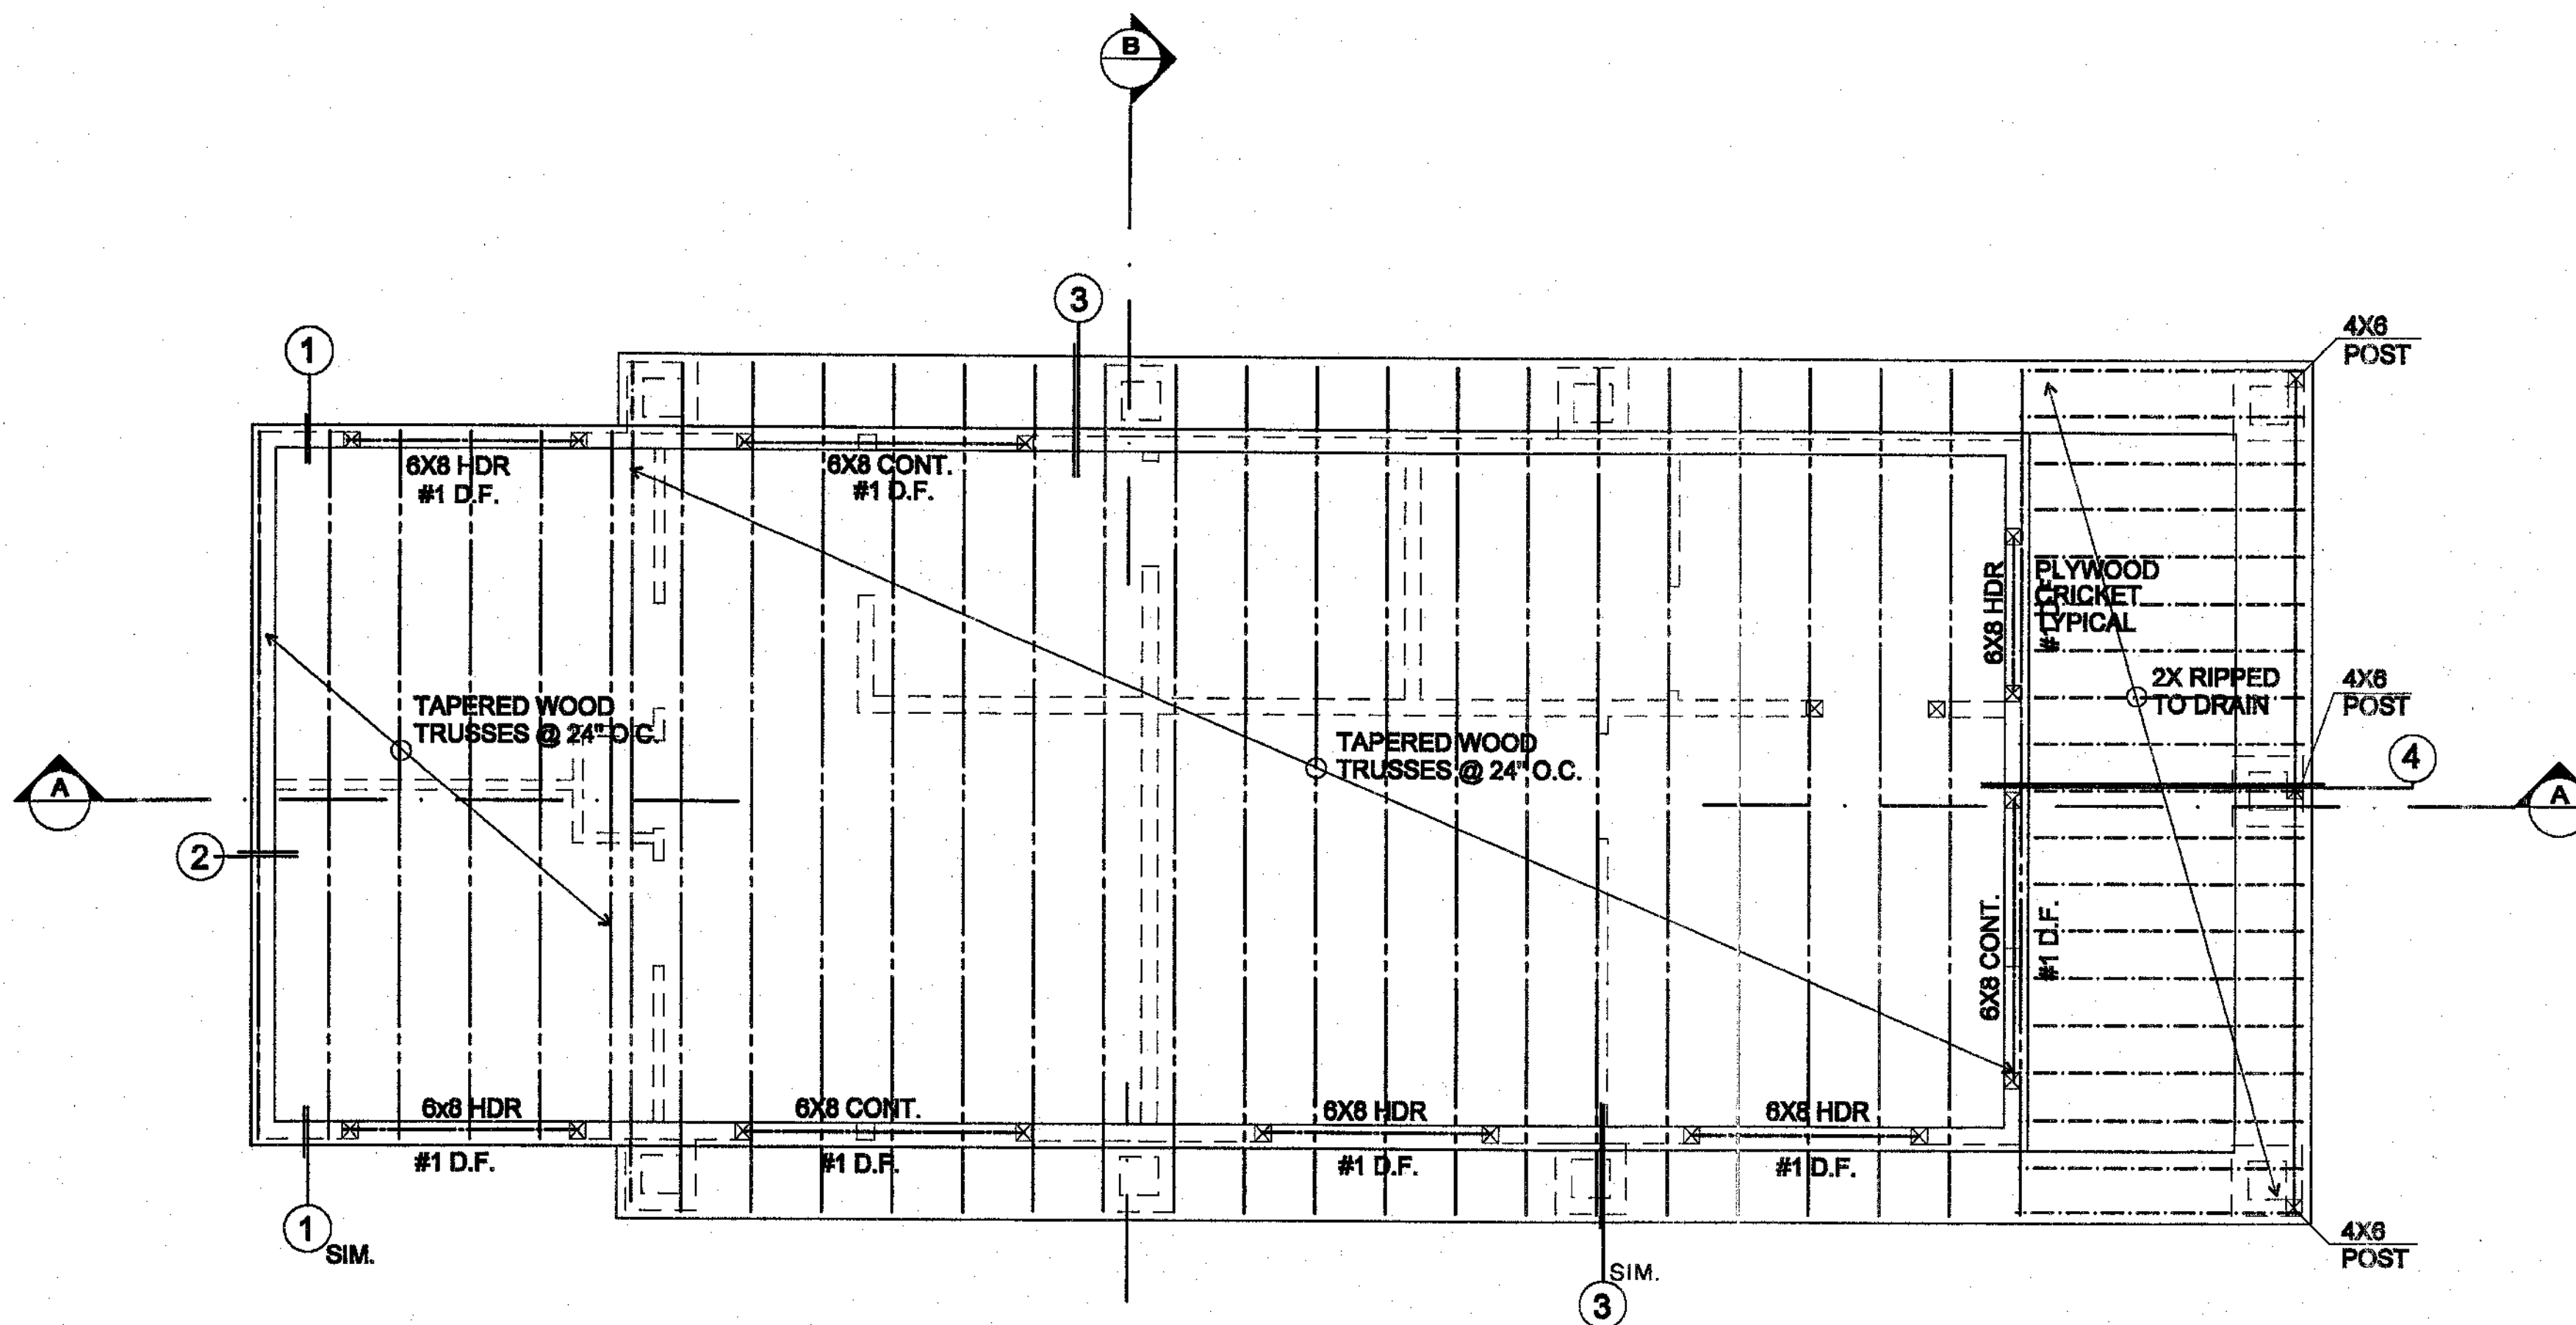


ROOF FRAMING PLAN 50X20 BLDG.

NOTE: POSTS FOR HEADERS MAY BE DOUBLE STUDS
SEE FLOOR PLAN FOR SHEAR WALLS
SPLICE TOP PLATES DIRECTLY OVER STUDS,
SEE STRUCTURAL CALCS. P.41

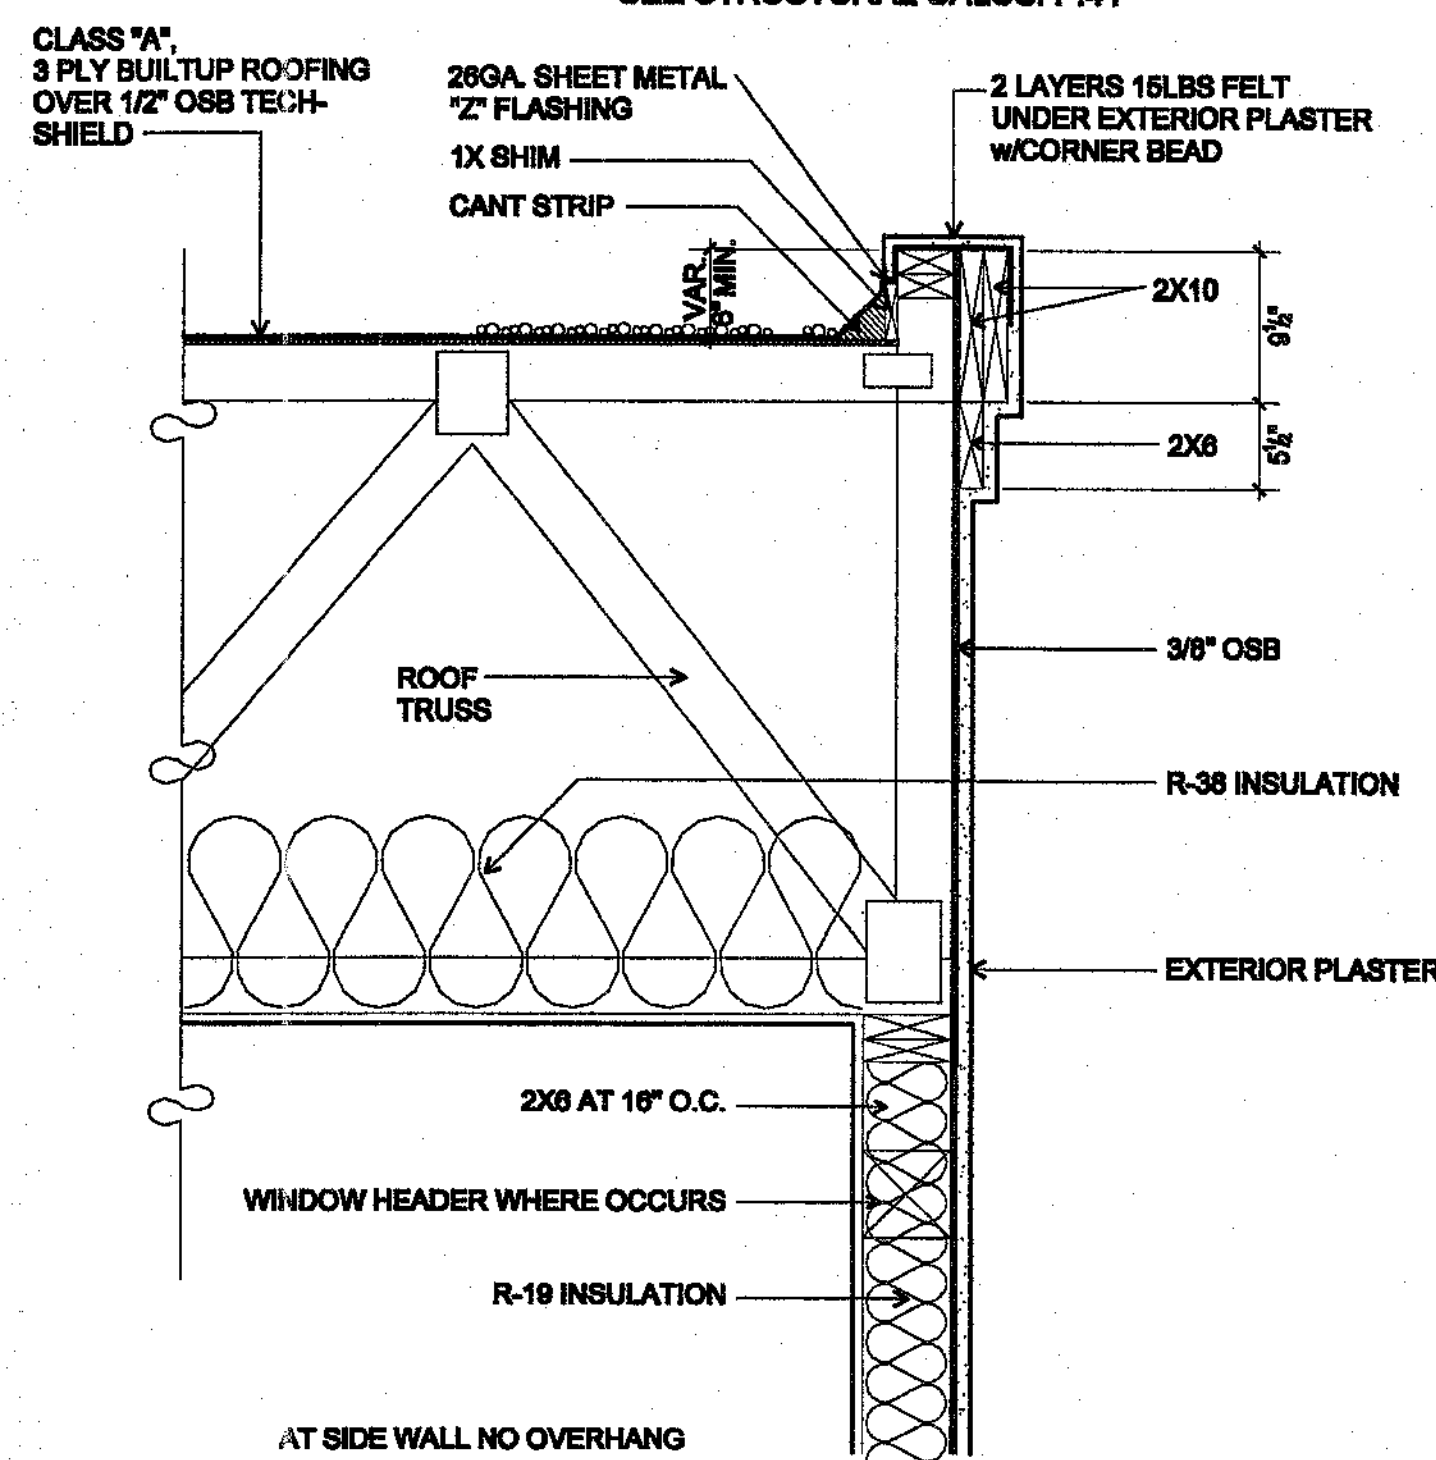

1 ROOF DETAIL


SCALE: 1" = 1'-0"

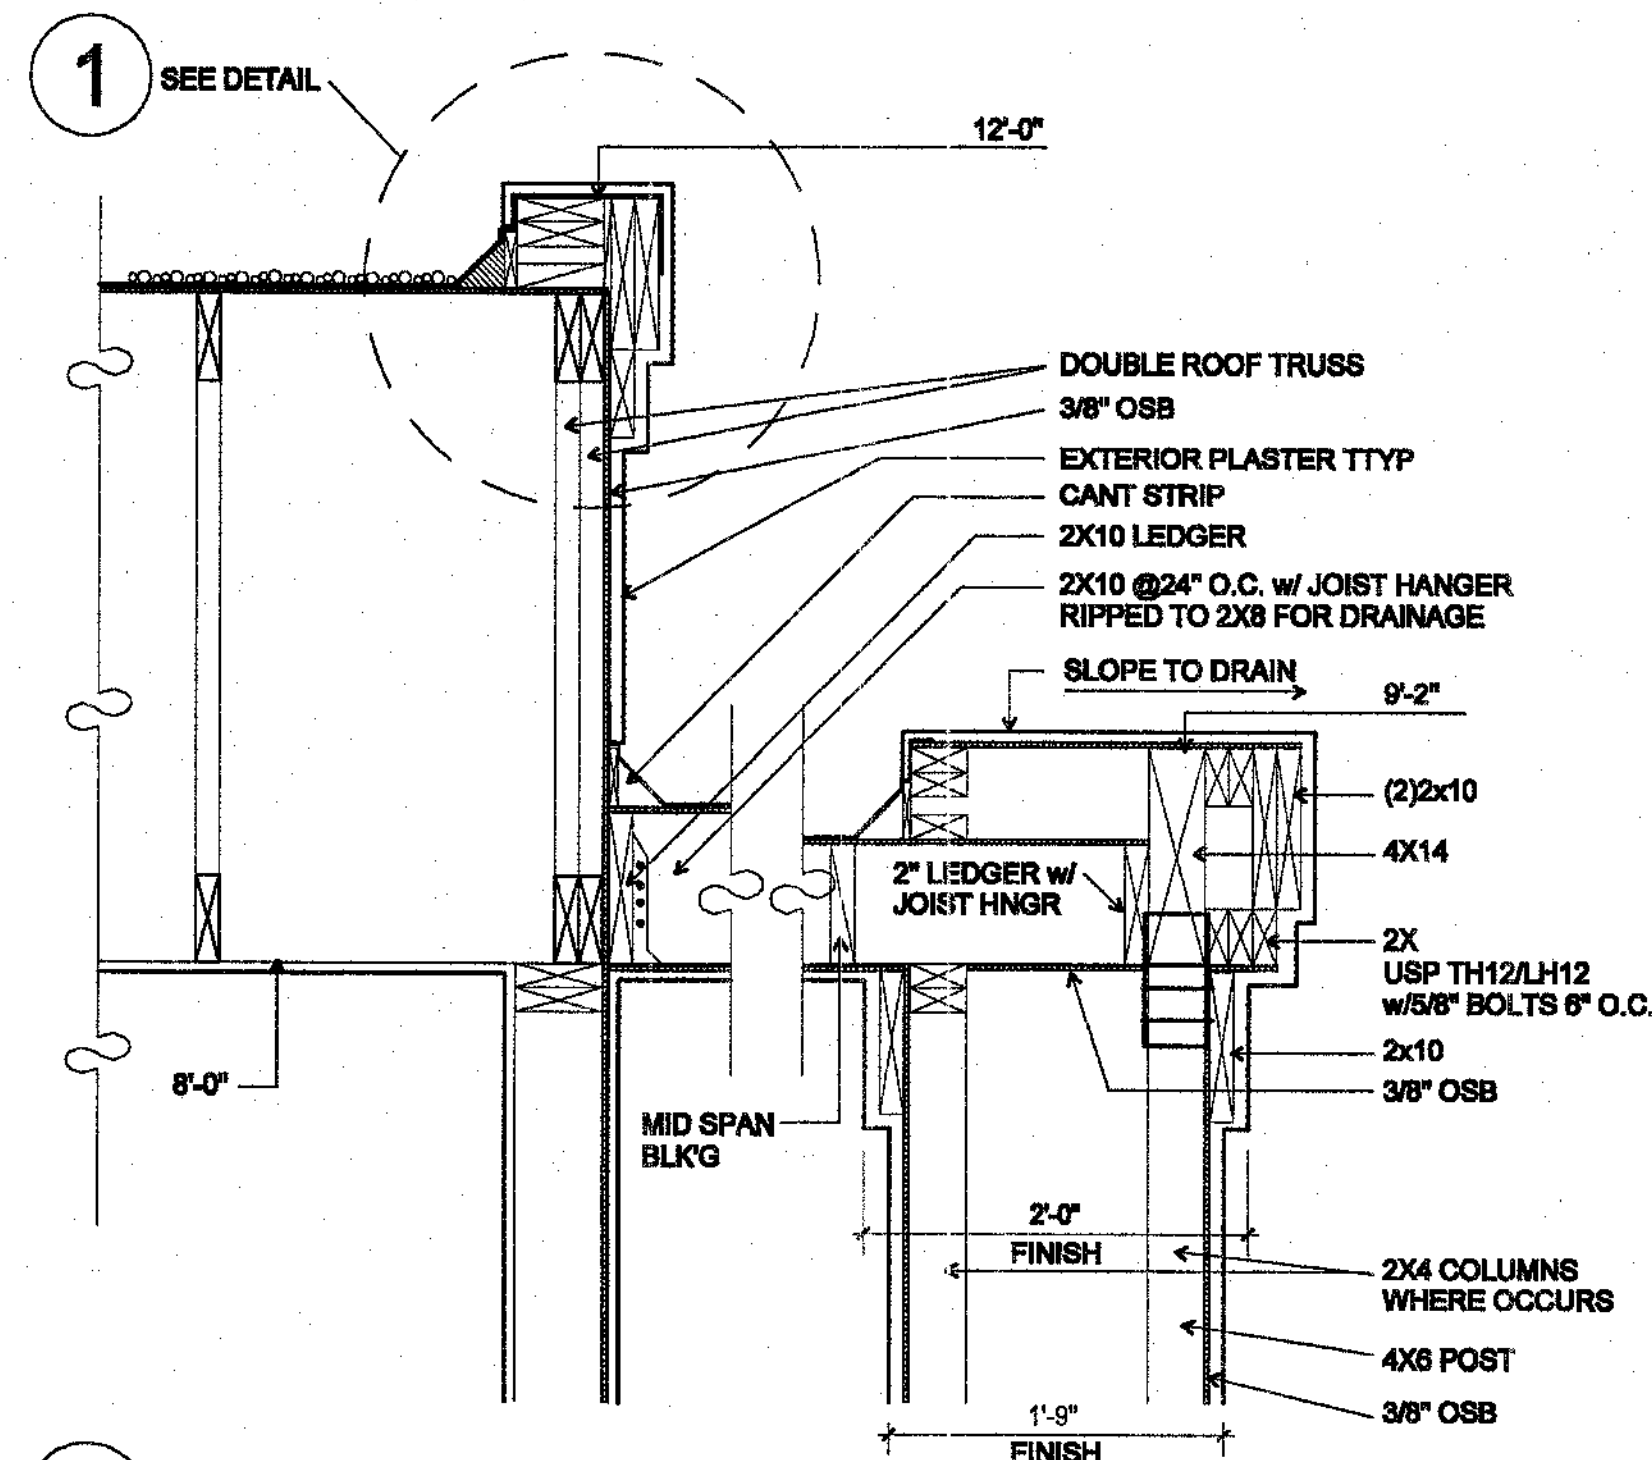

4 ROOF DETAIL


SEE DETAIL 1 FOR ADDITIONAL NOTES

SCALE: 1" = 1'-0"

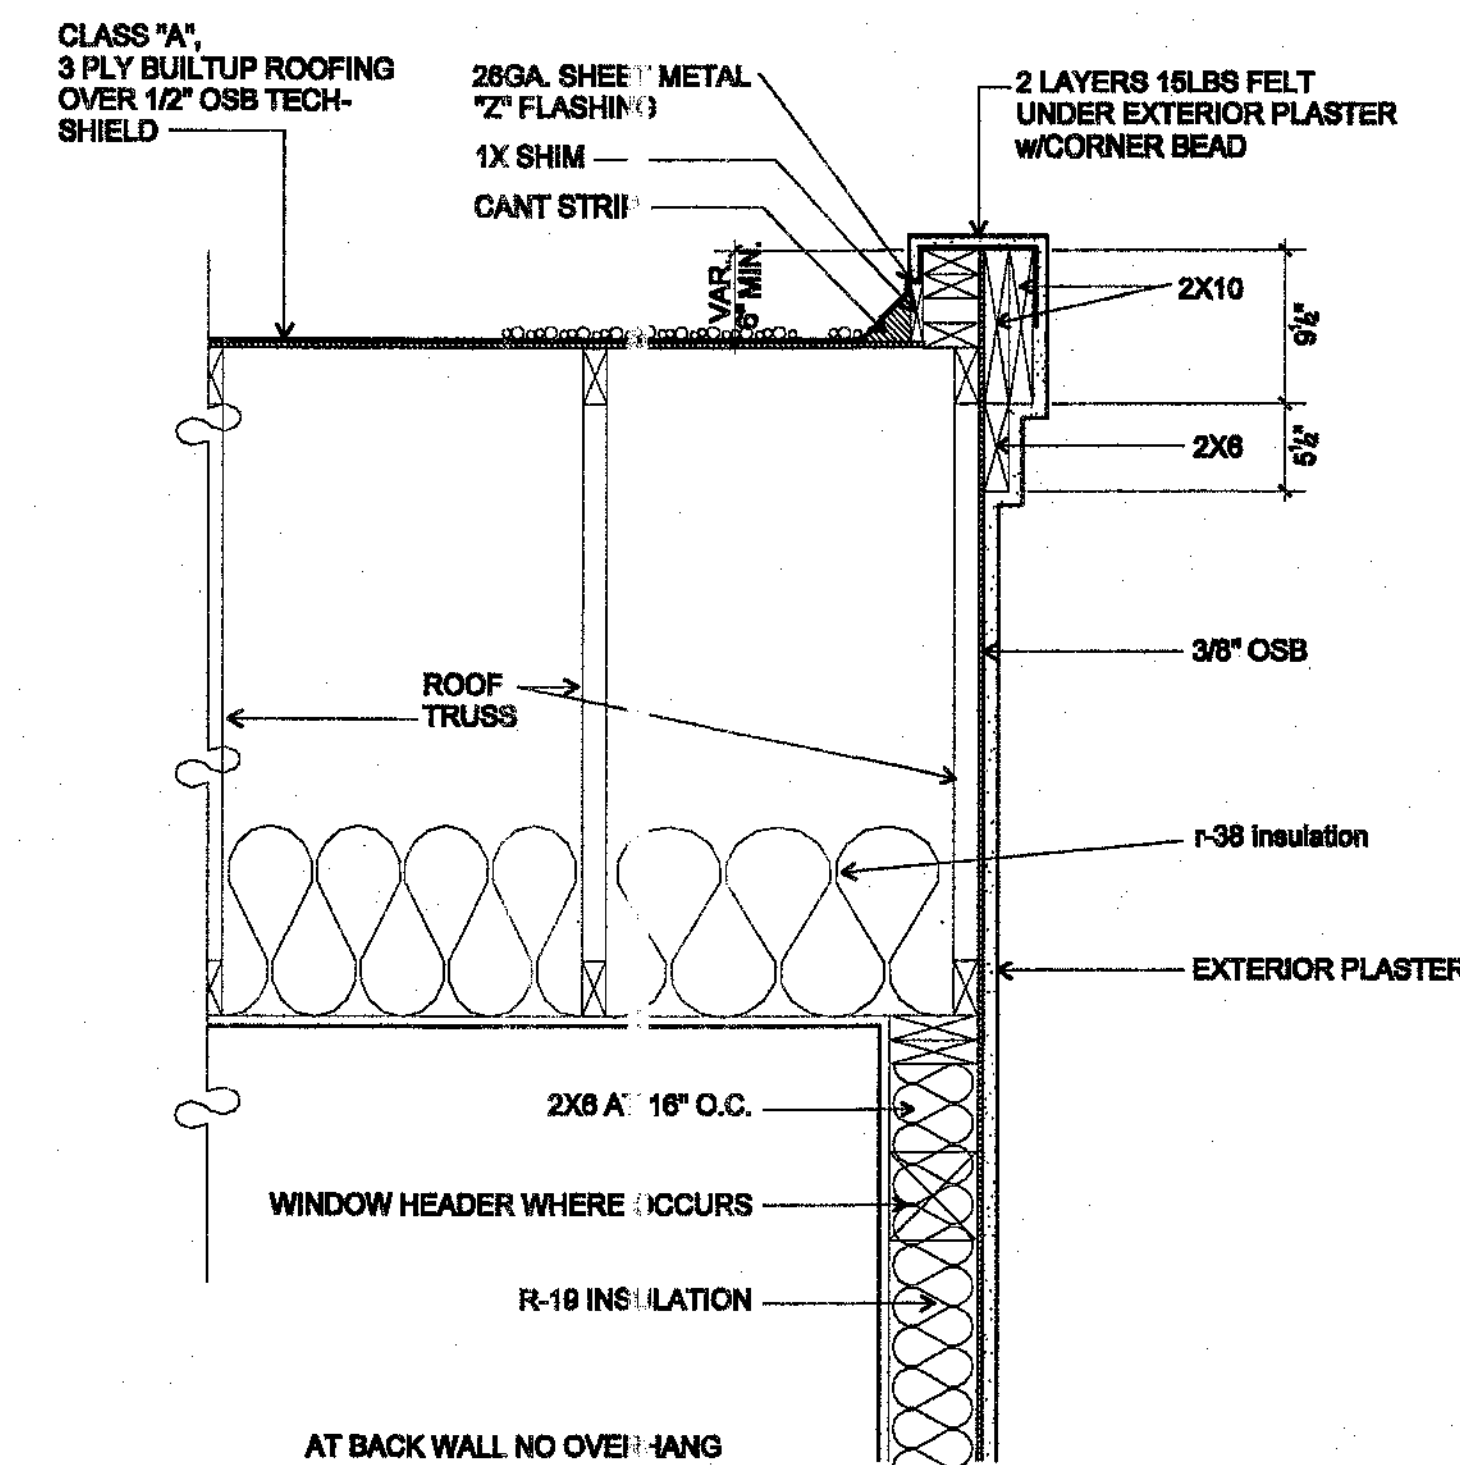

2 ROOF DETAIL

SCALE: 1" = 1'-0"

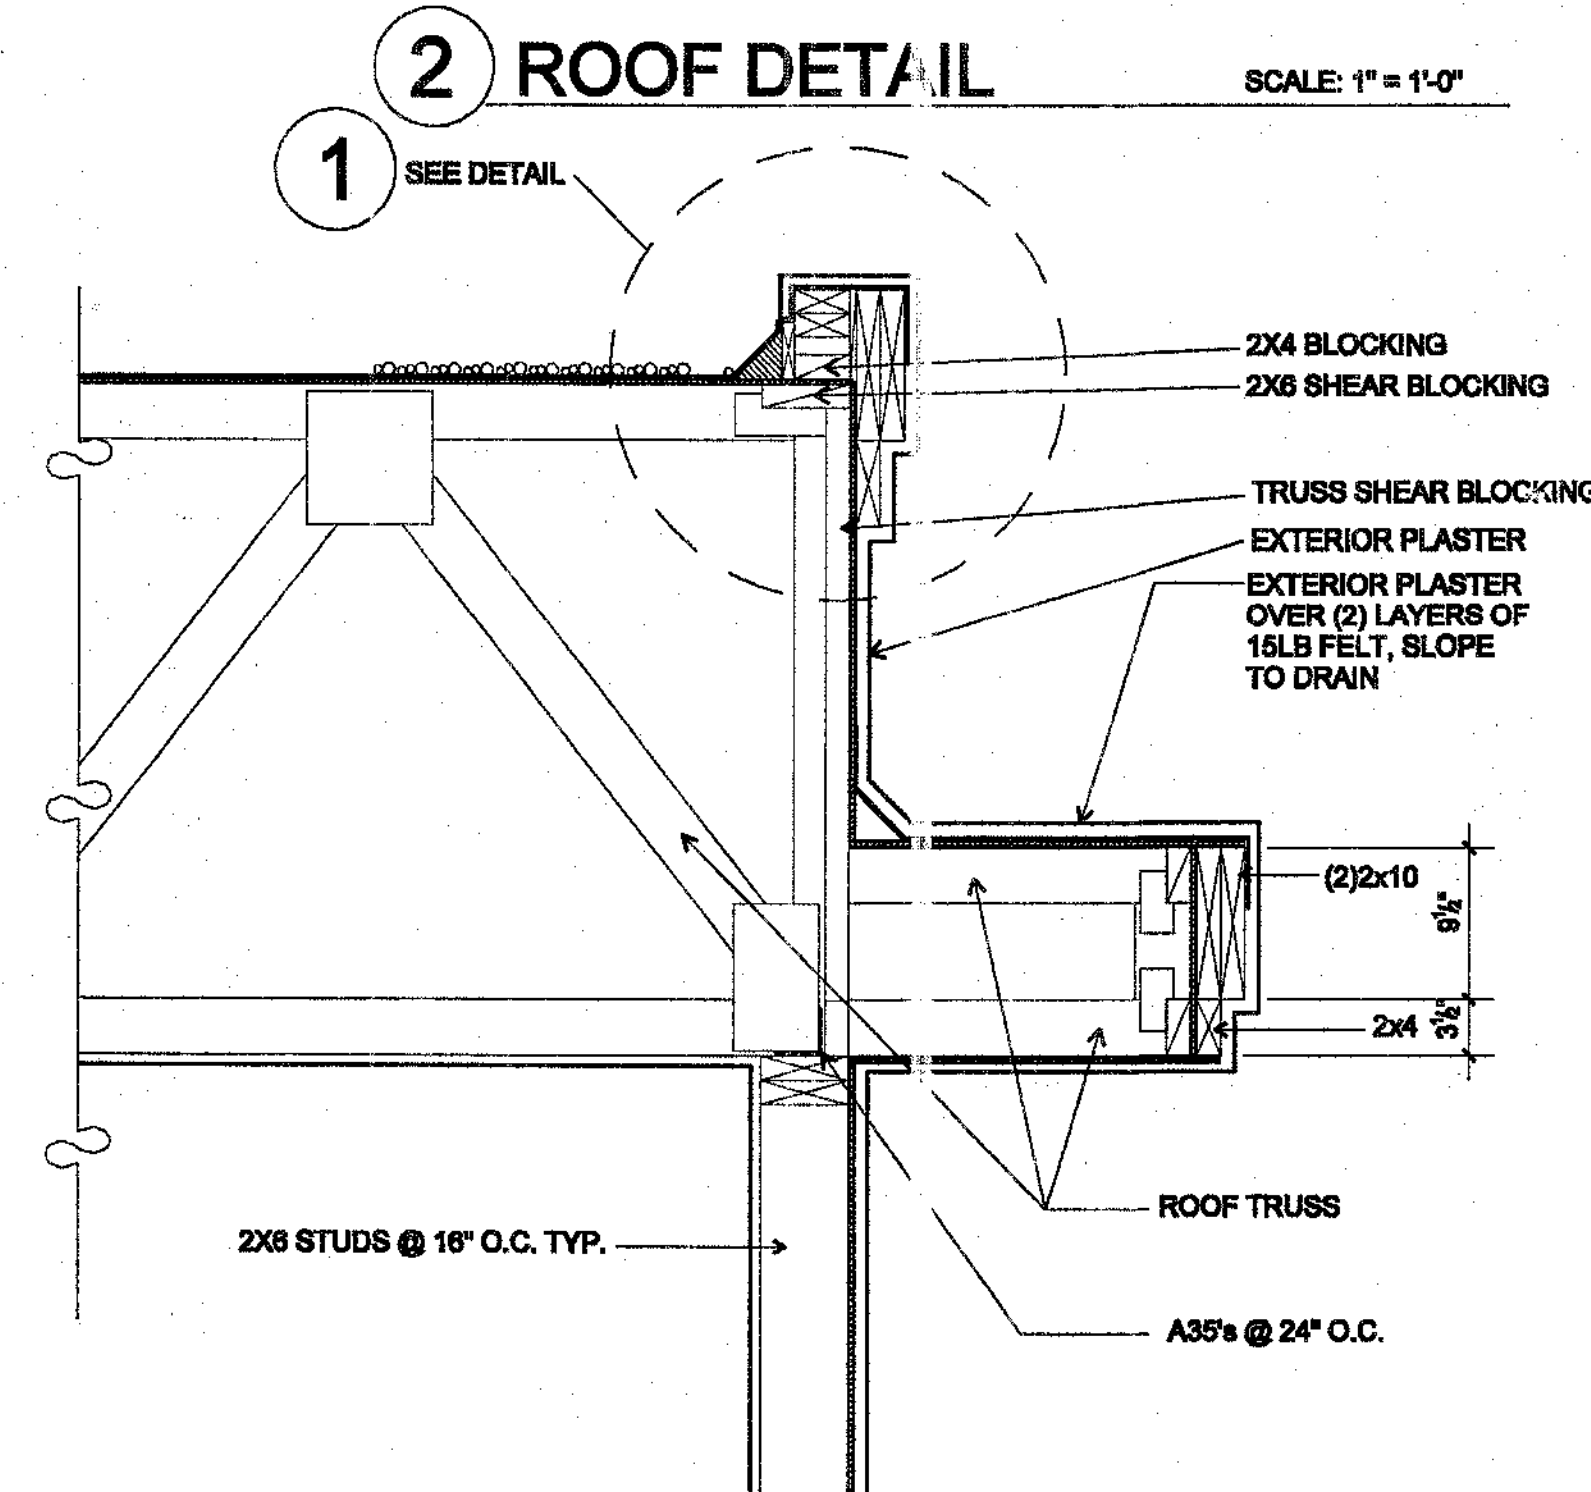


3 ROOF DETAIL



SCALE: 1" = 1'-0"

An Office and Storage Facility for:
James Hanousek
Trailer Place
Indio, California

Architect:
Charles W. McBride
74-133 El Paseo, Suite 11
Palm Desert, CA 92260
(760)346-5300
(760)346-7981 Fax
License # C12905

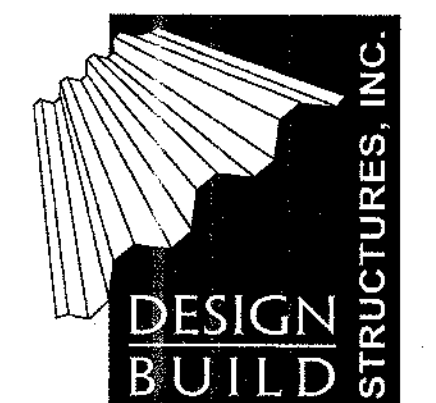

Title: Construction Documents
Date: January 15, 2004
Revised:

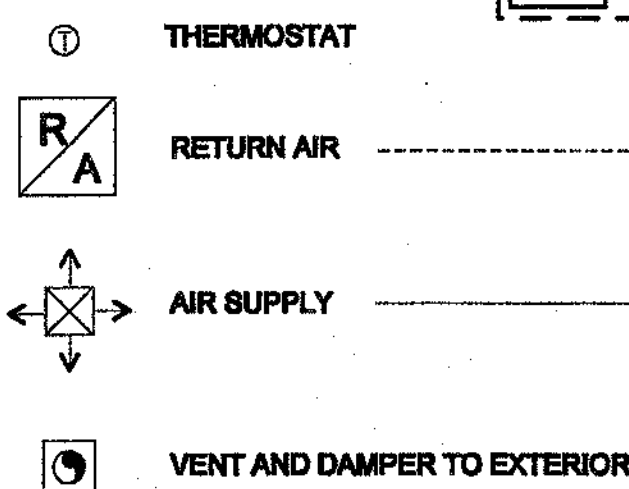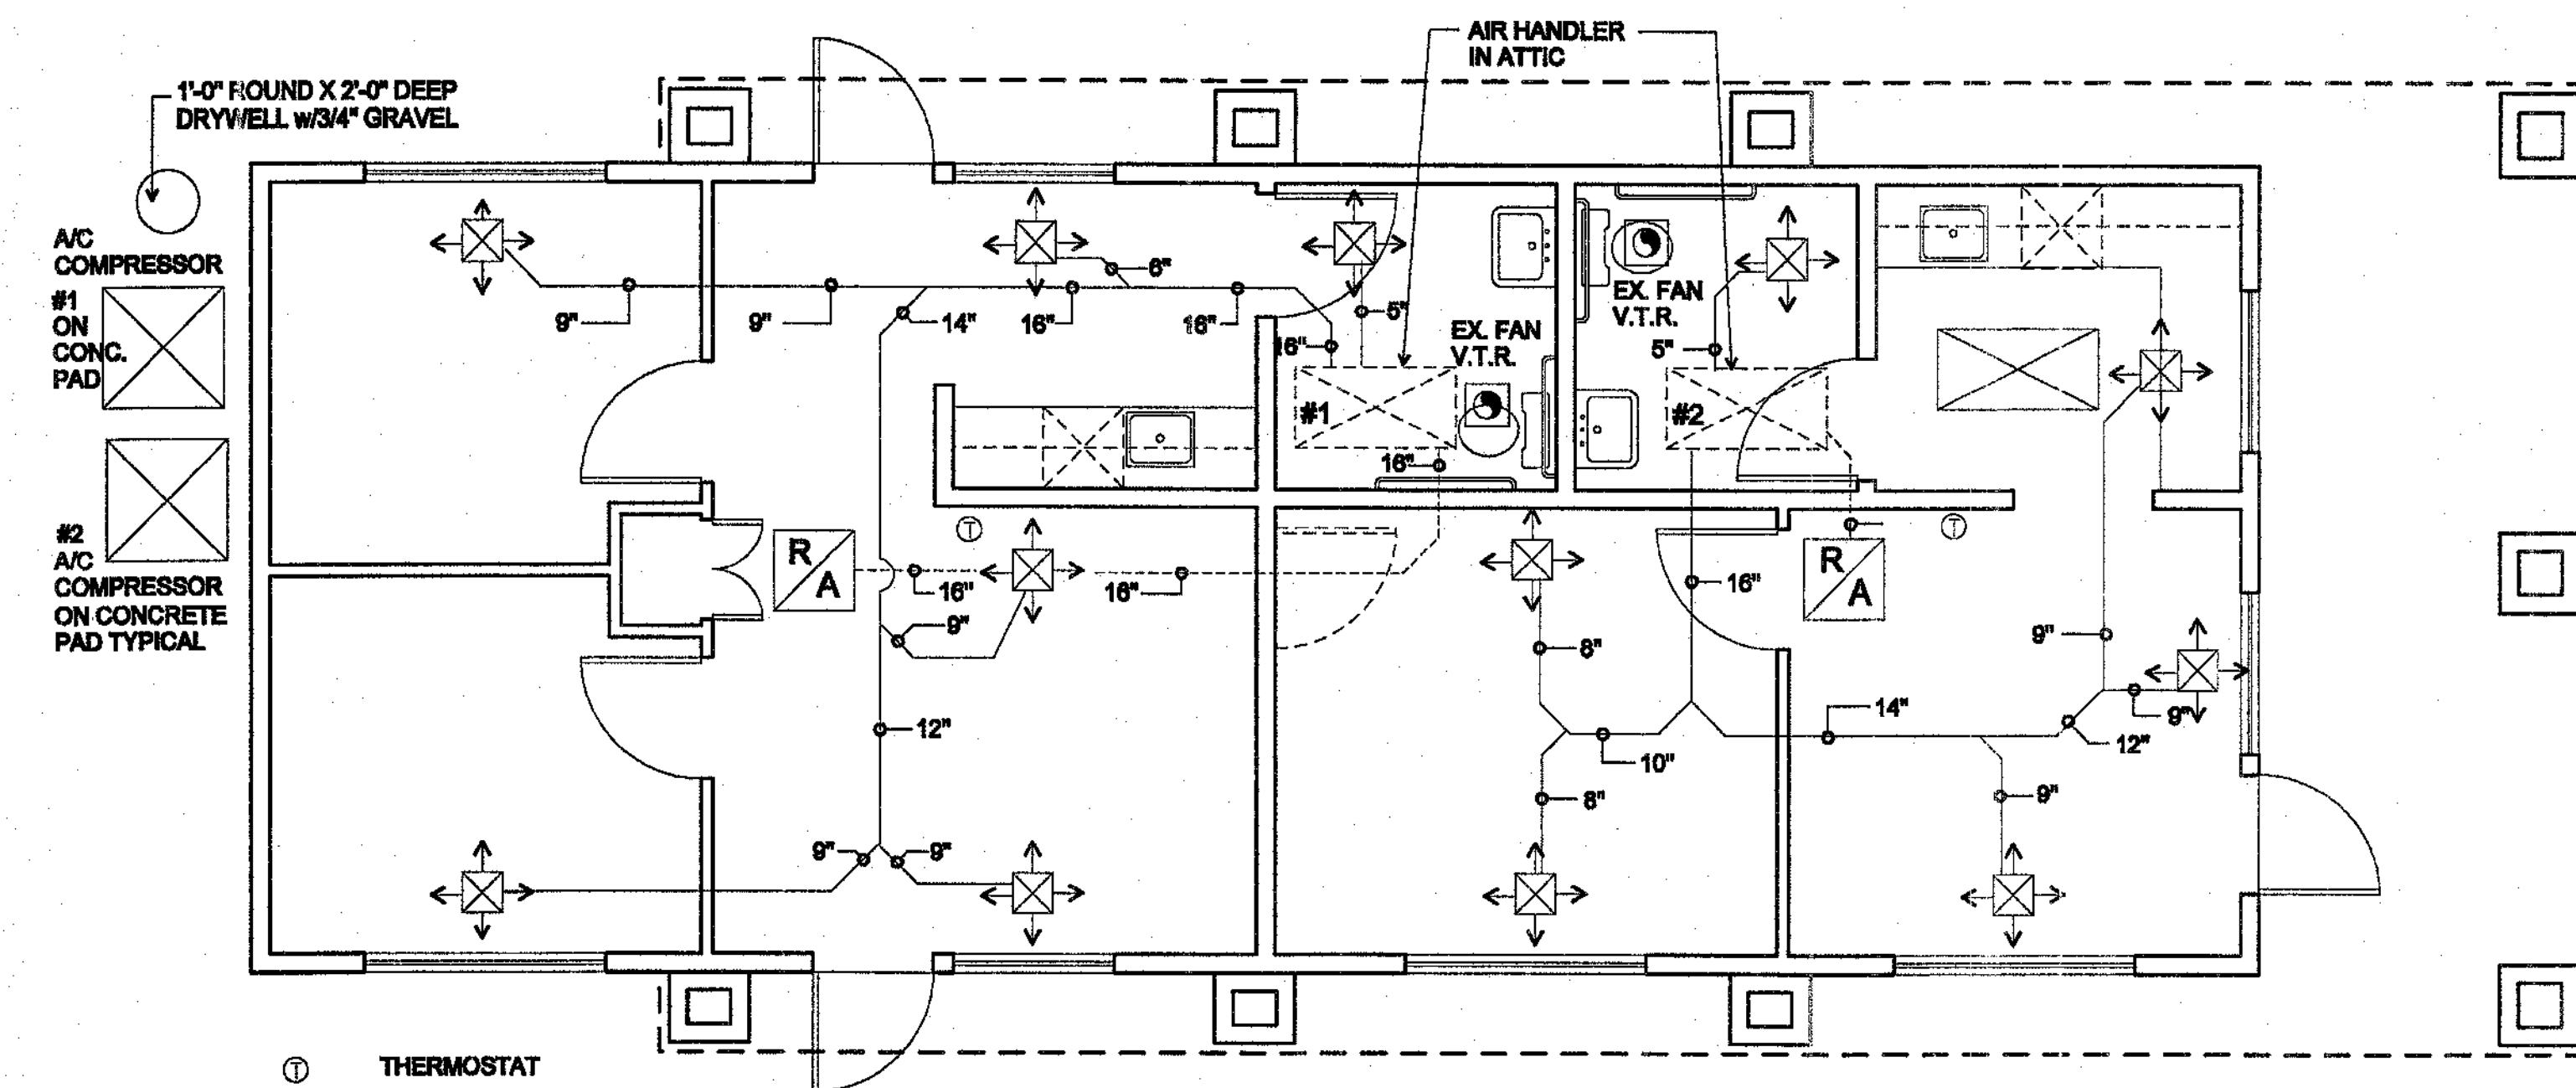


MECHANICAL PLAN 50X20 BLDG.


SCALE: 1/4" = 1'-0"

A/C SYSTEM NO.1 & 2 - YORK 3 TON F2RP096H06 FAU AND YORK 3 TON, 12 SEER, HEAT PUMP, E1RC096S06 CONDENSER

SPLIT SYSTEM
FLEXIBLE DUCT WORK
COPPER LIQUID + SUCTION LINES
CONDENSATE DRAINS
LOW VOLTAGE WIRING
BATH VENTING
SUPPLY + RETURN AIR REGISTERS
DIGITAL THERMOSTATS
SECONDARY CONDENSATE PANS
A/C RELATED MISC. SHEETMETAL

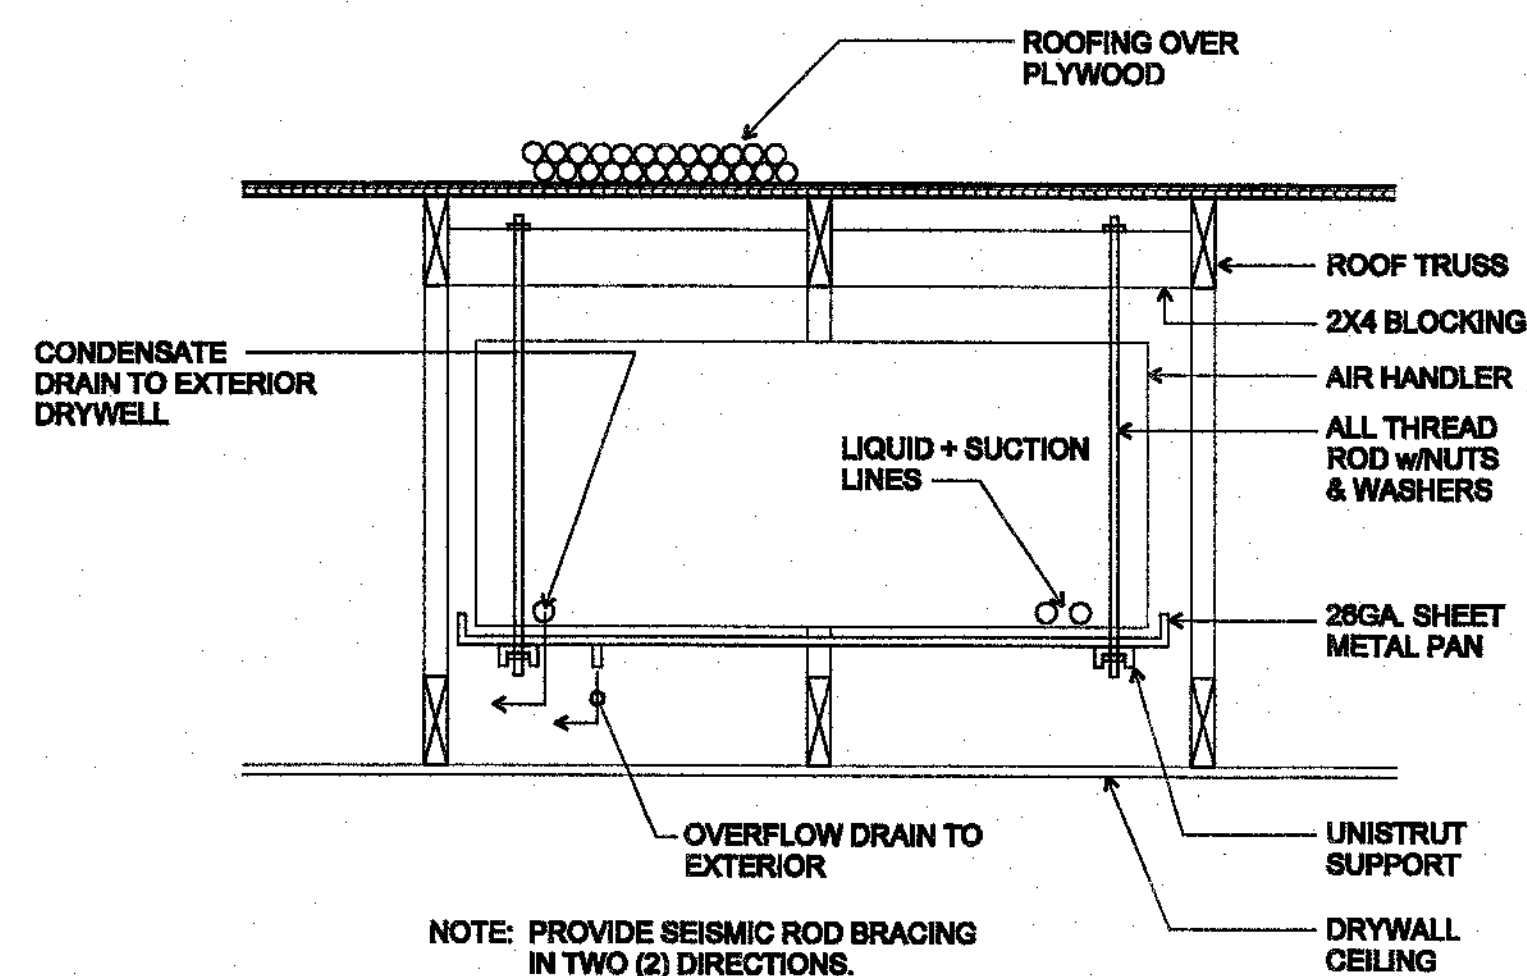

AIR HANDLER DETAIL SCALE: 1" = 1'-0"

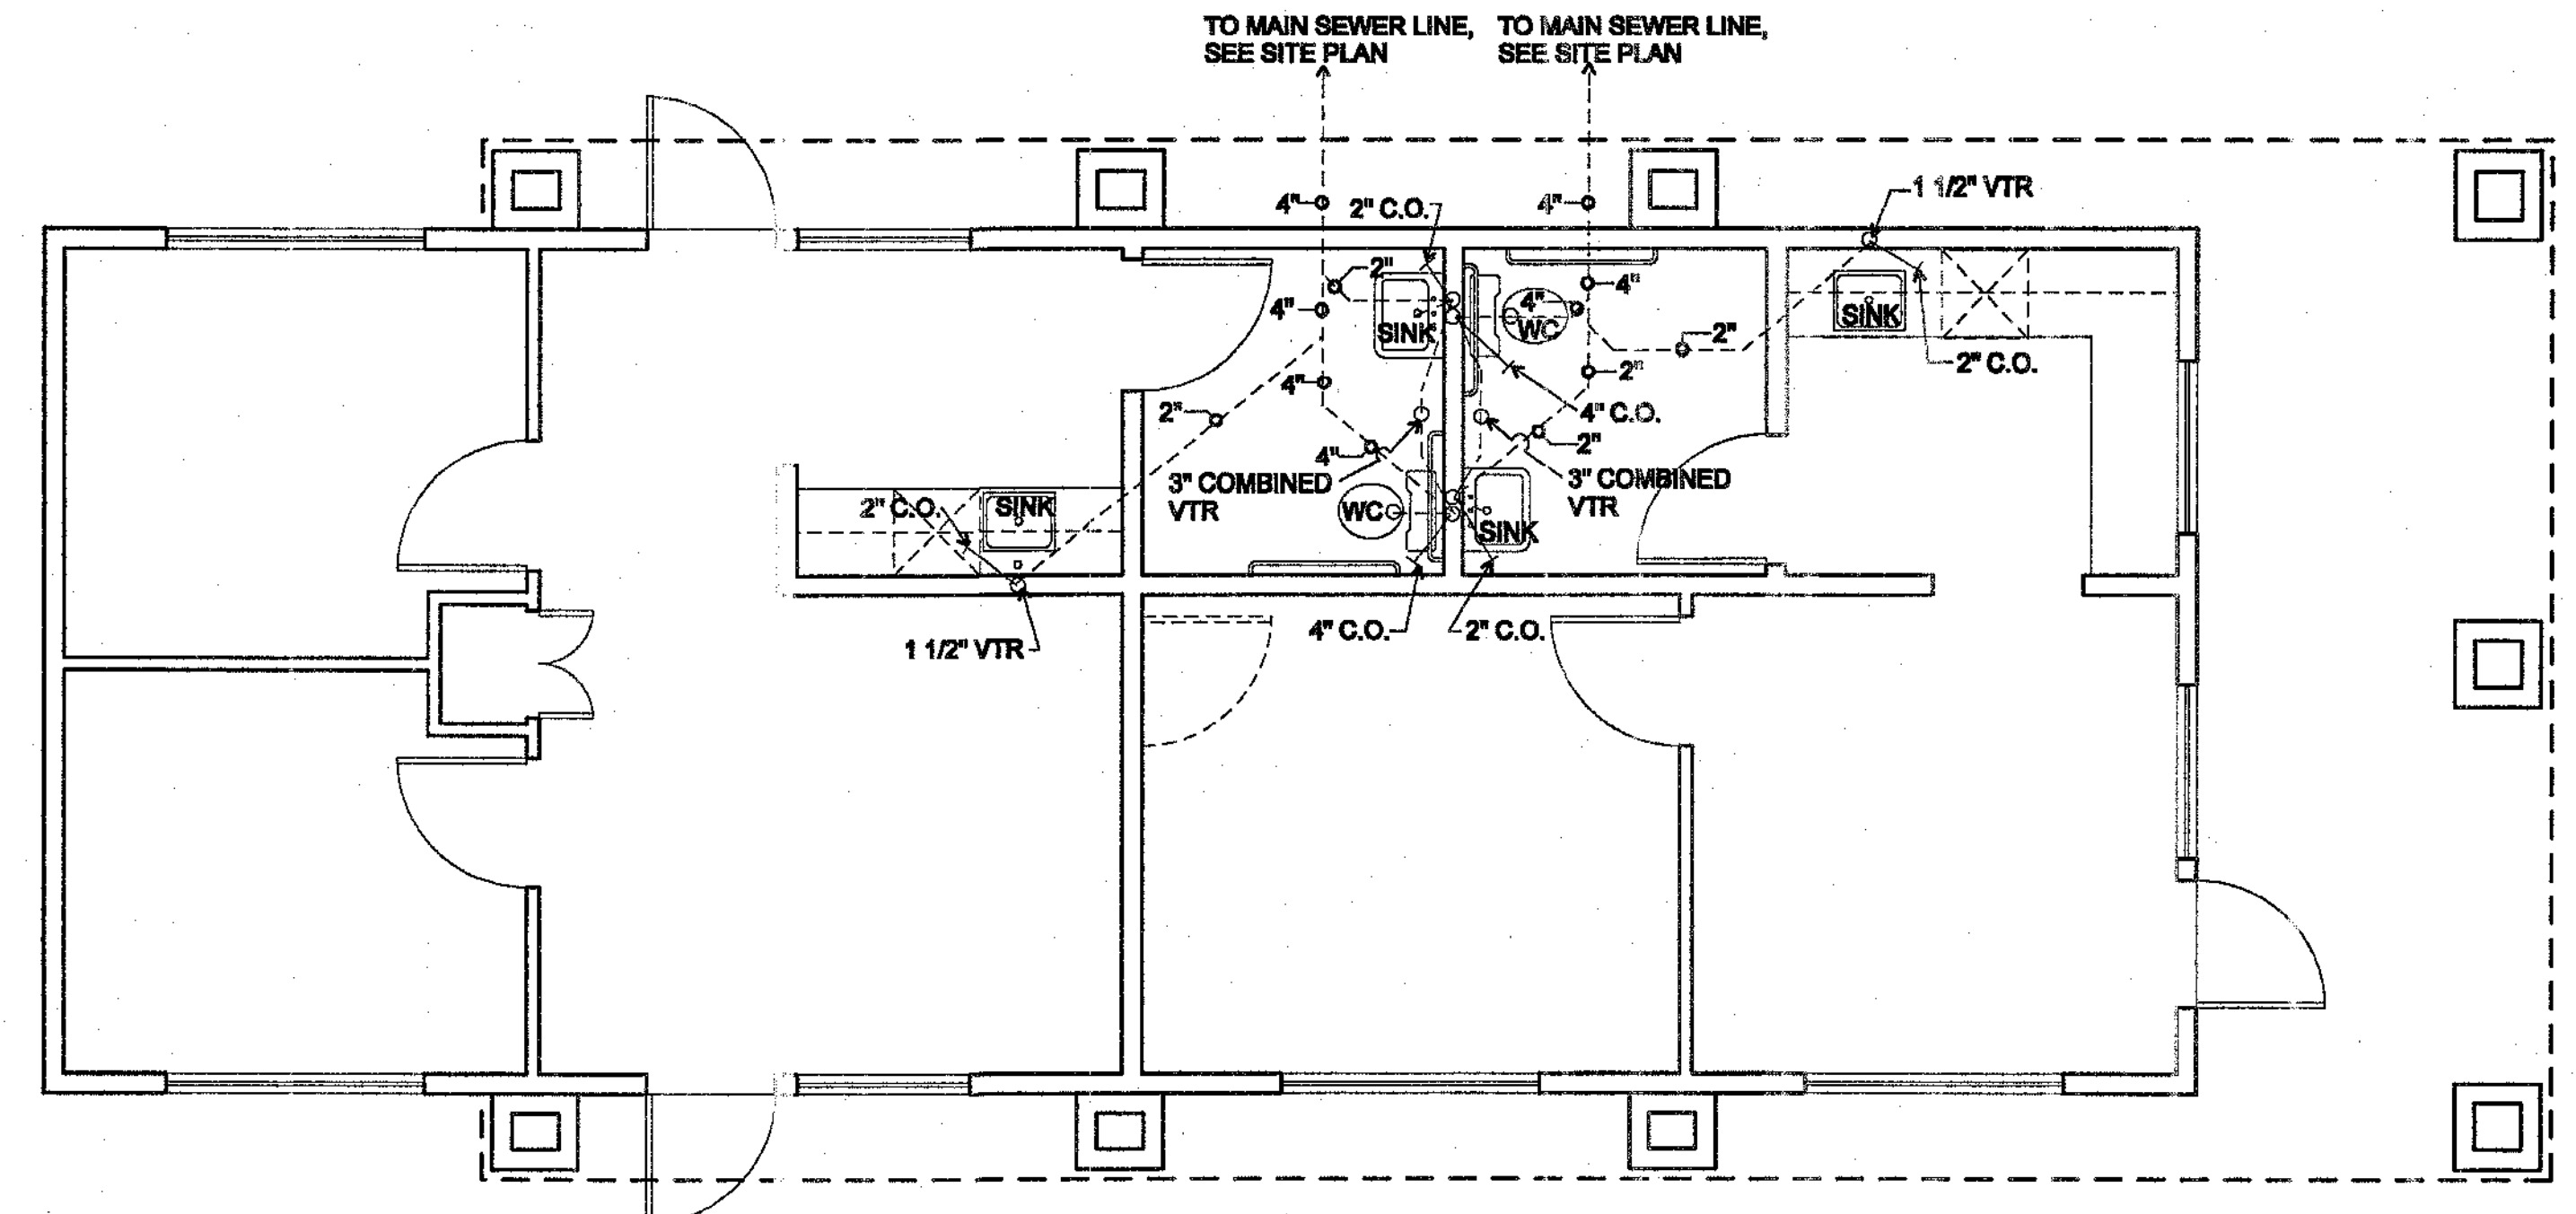


NOTE: SEE ROOF PLAN FOR ROOF DRAINS

PLUMBING PLAN 50X20 BLDG.






SCALE: 1/4" = 1'-0"

An Office and Storage Facility for:
James Hanousek
Trader Place
Indio, California

Architect:
Charles W. McBride
74-133 El Paseo, Suite 11
Palm Desert, CA 92260
(760) 346-5300
(760) 346-7981 Fax
License # C12905

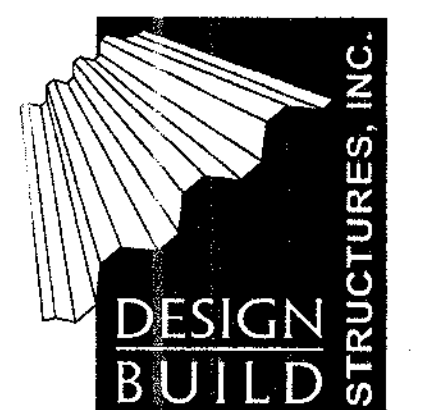


Title: Construction Documents
Date: January 15, 2004
Revised:

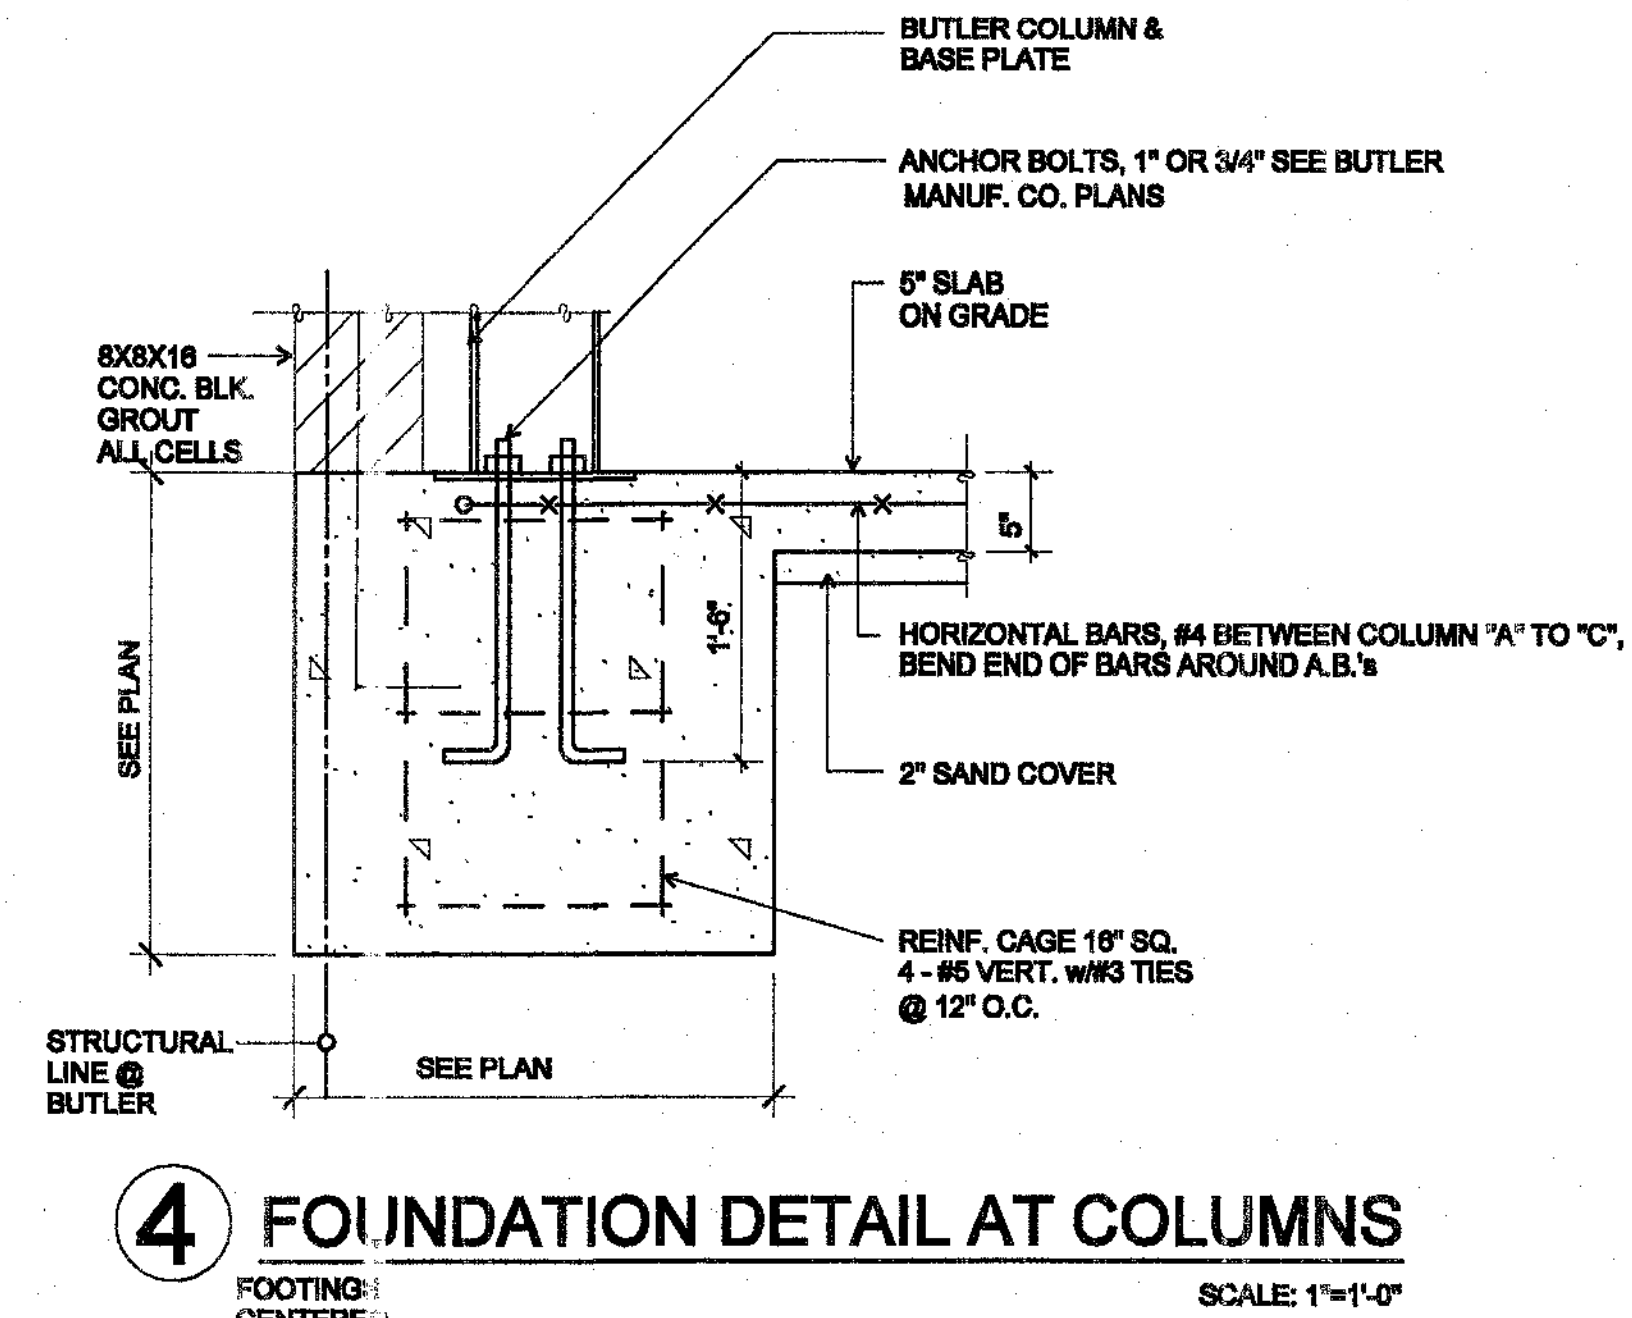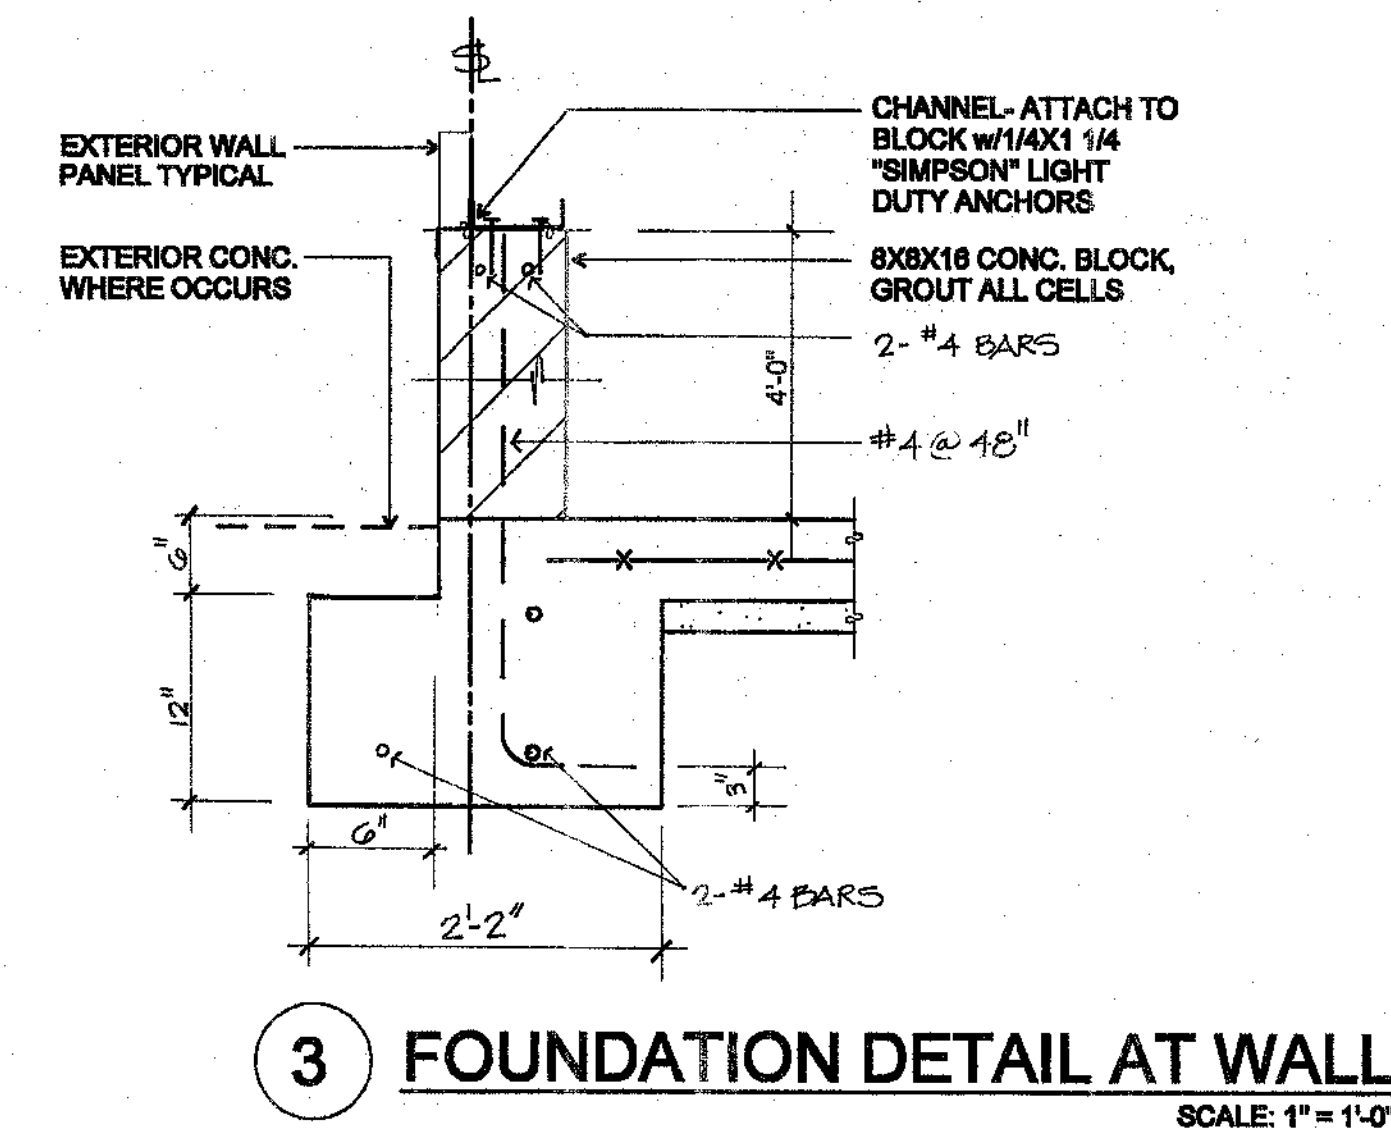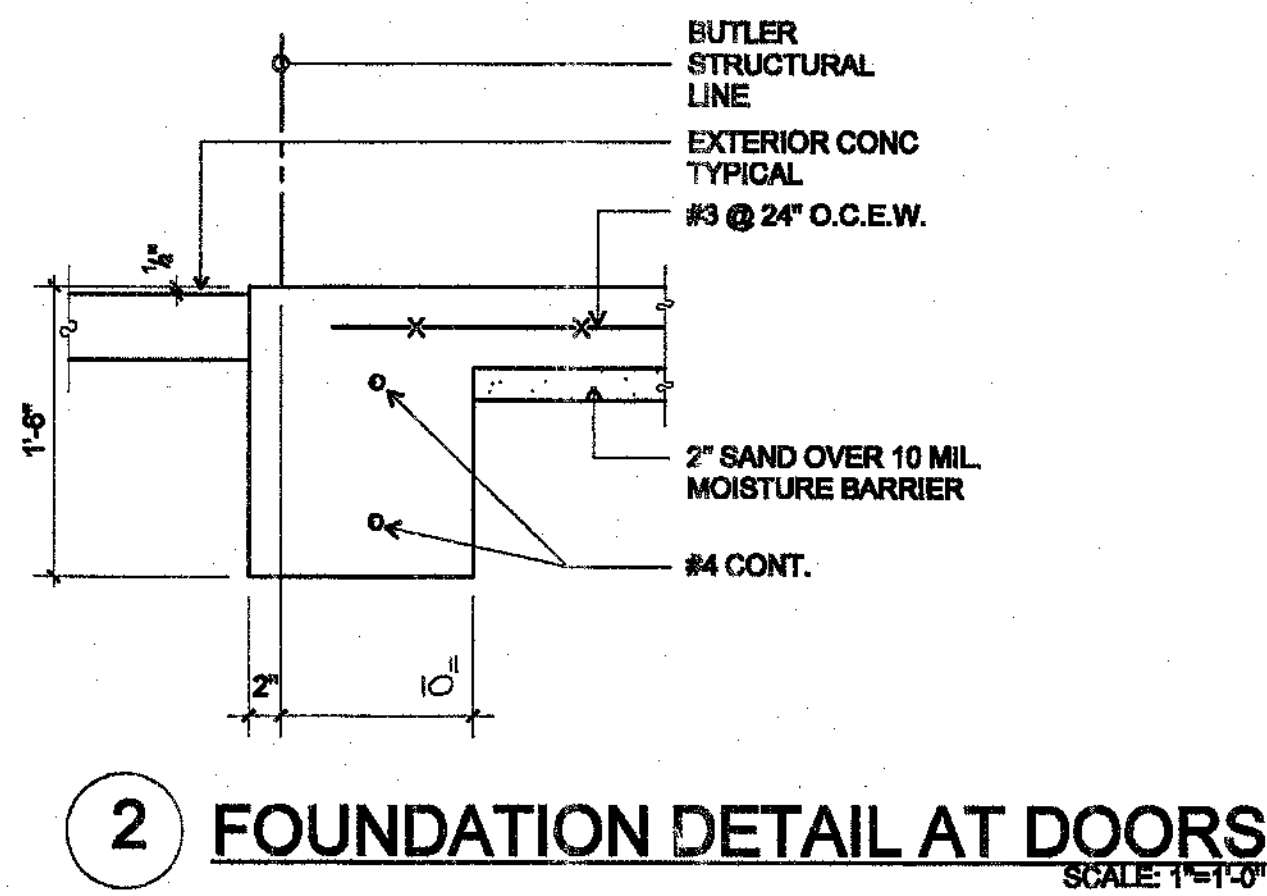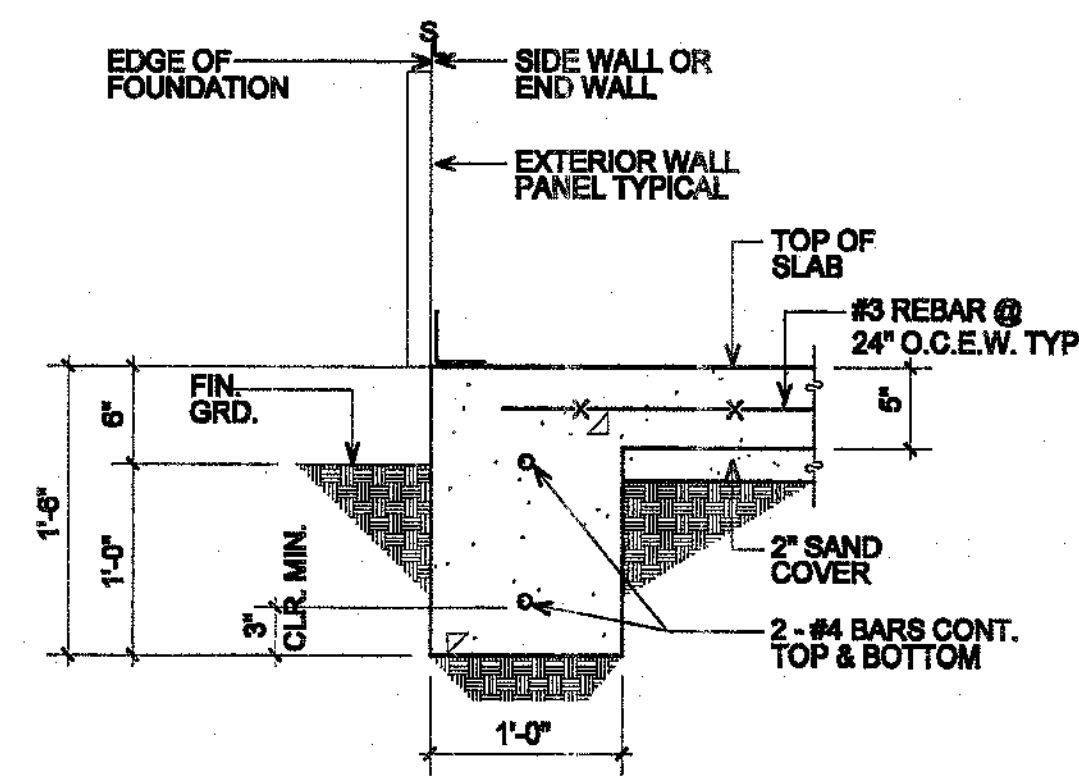
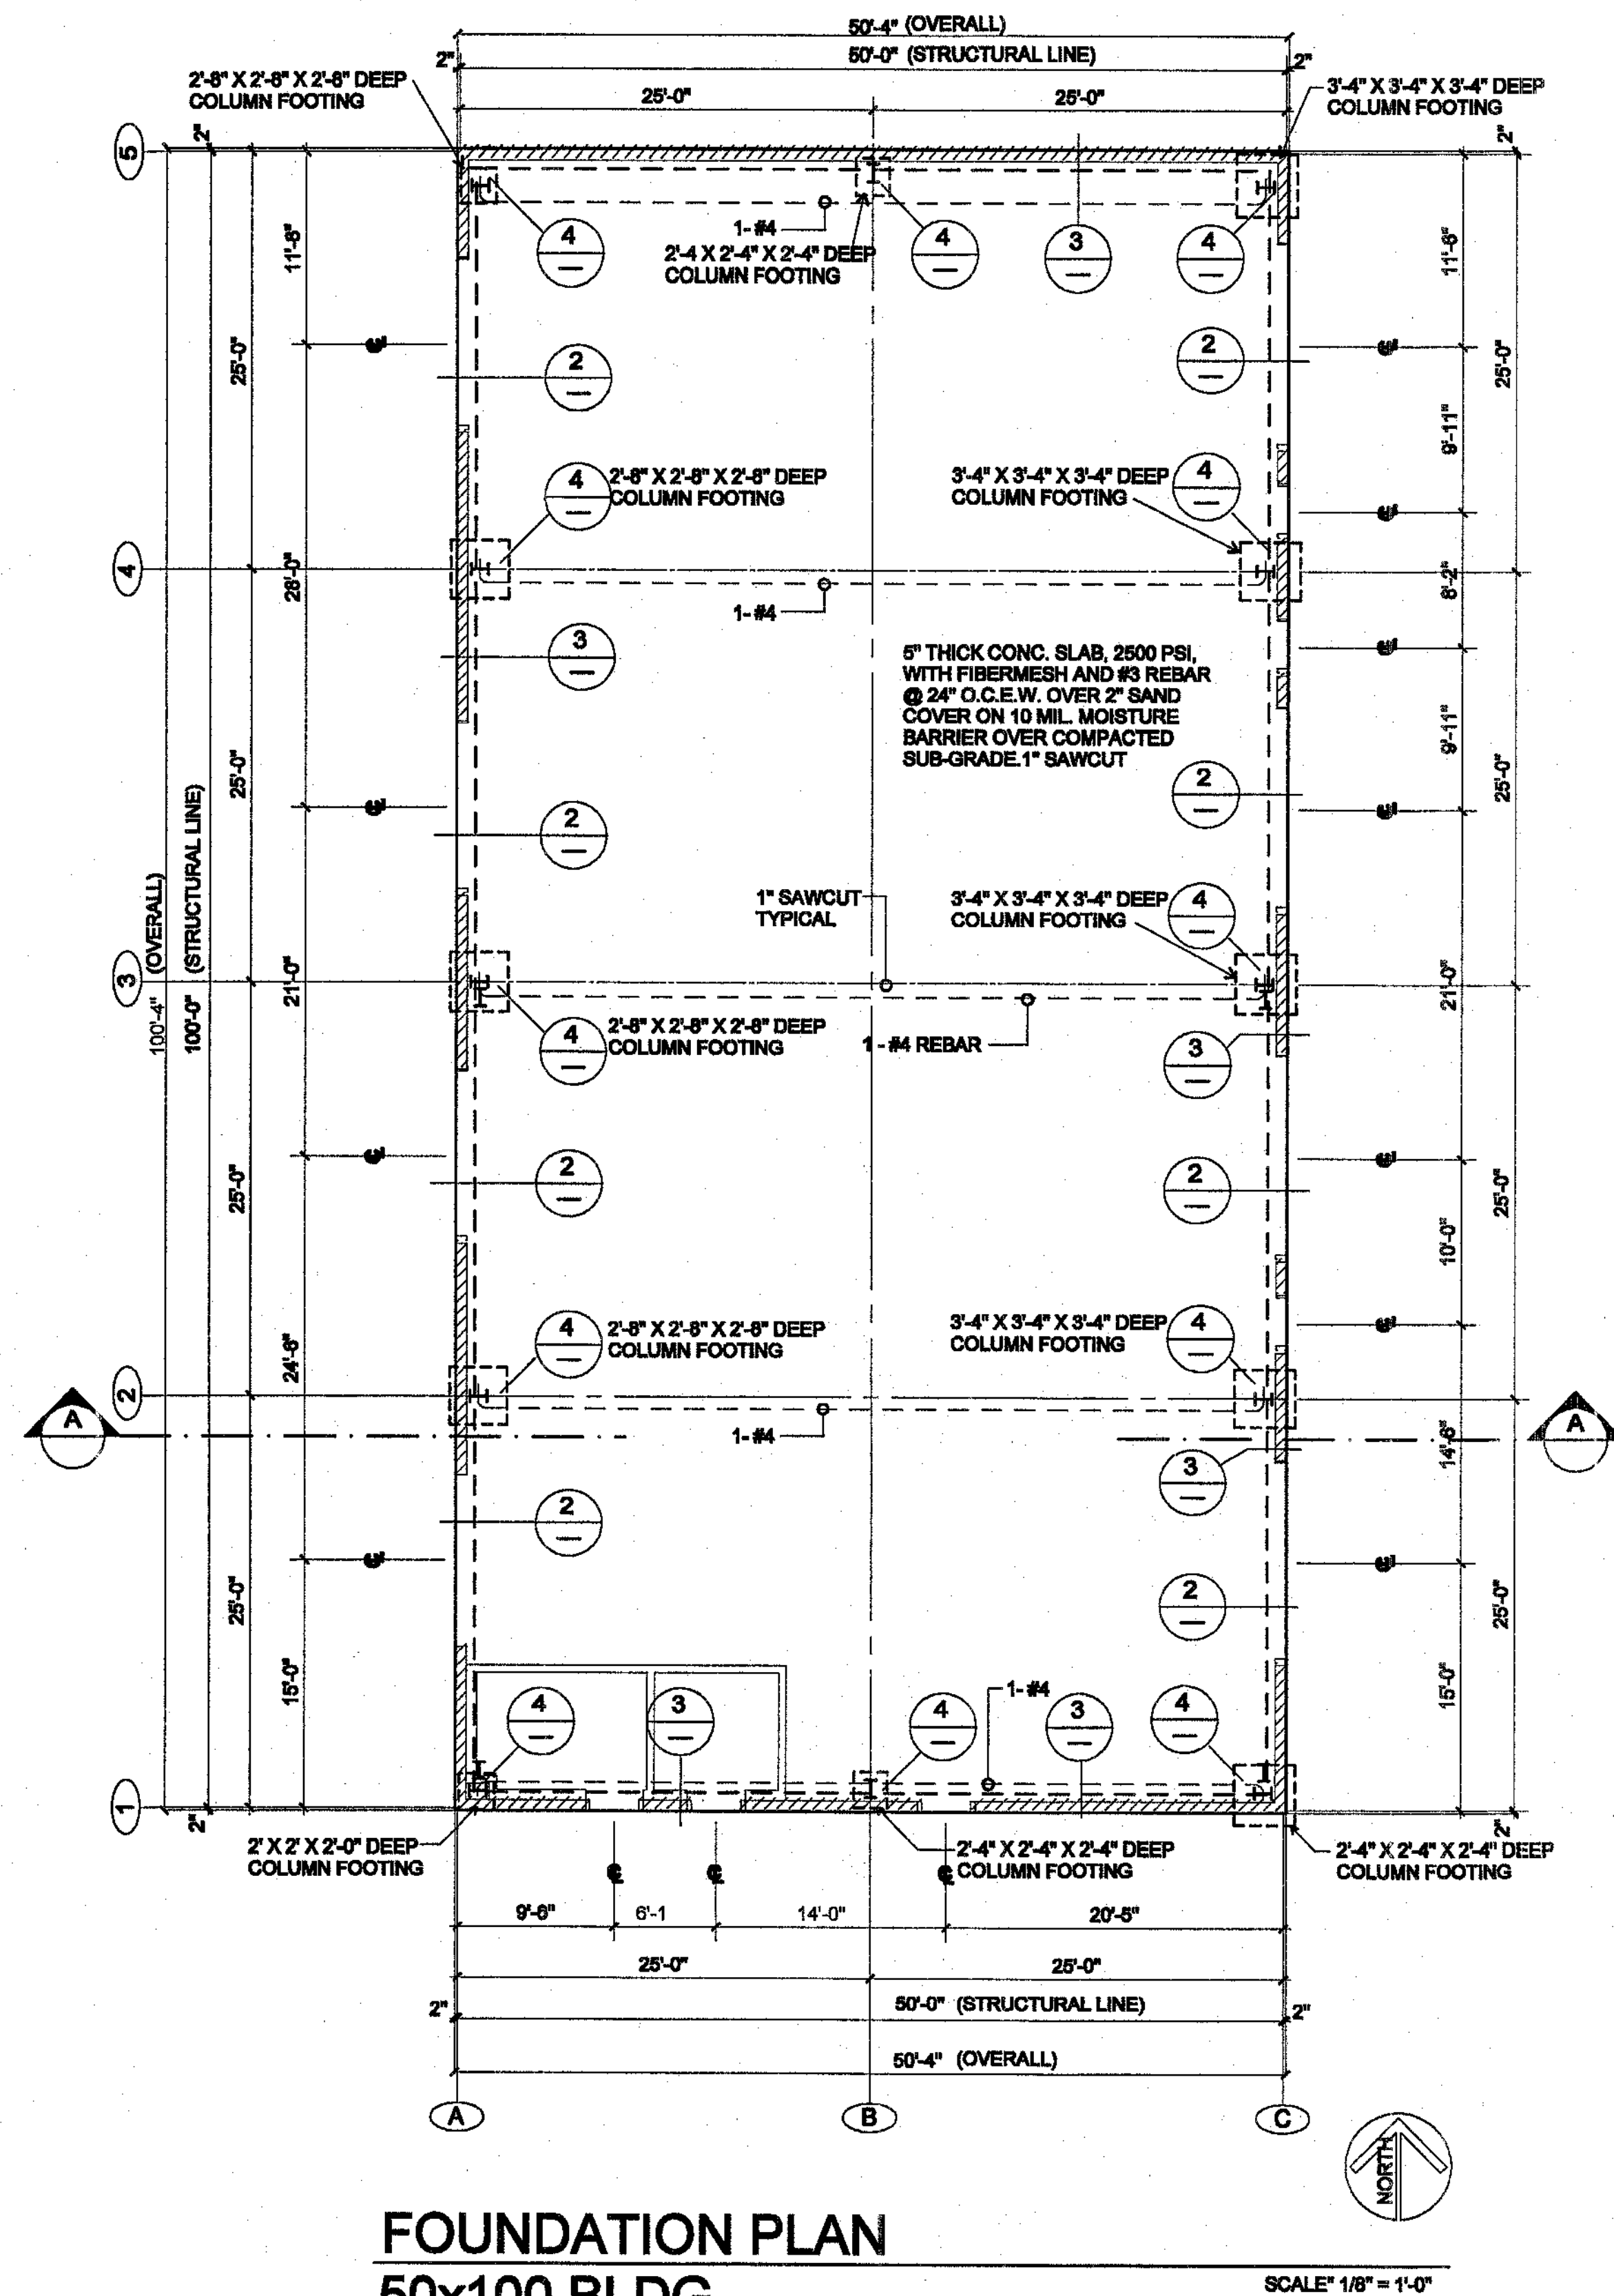


An Office and Storage Facility for:
 James Hancusek
 Trader Place
 Indio, California


Architect:
 Charles W. McBride
 74-133 El Paseo, Suite 11
 Palm Desert, CA 92260
 (760)346-5300
 (760)346-7981 Fax
 License # C12905

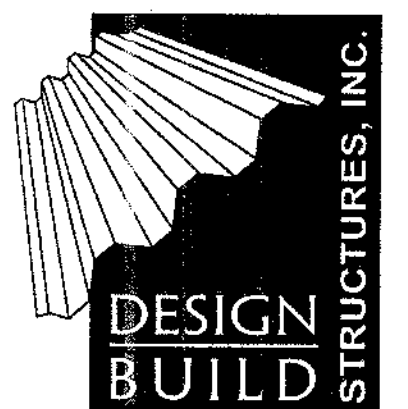


Title: Construction Documents
 Date: January 15, 2004
 Revised:

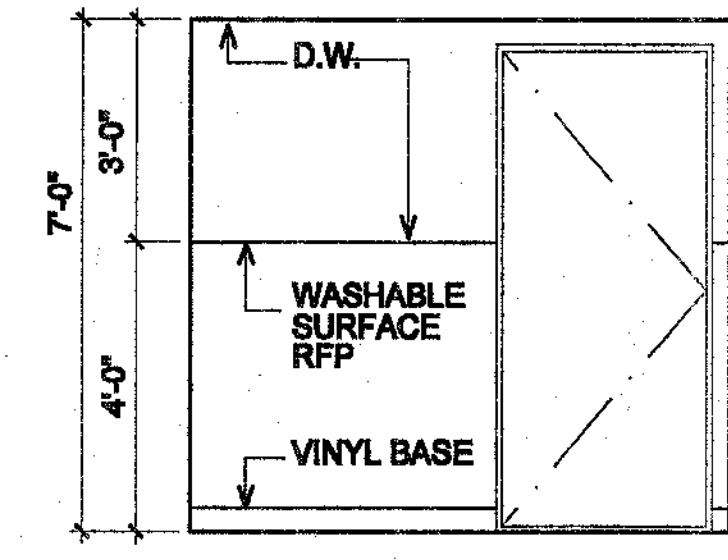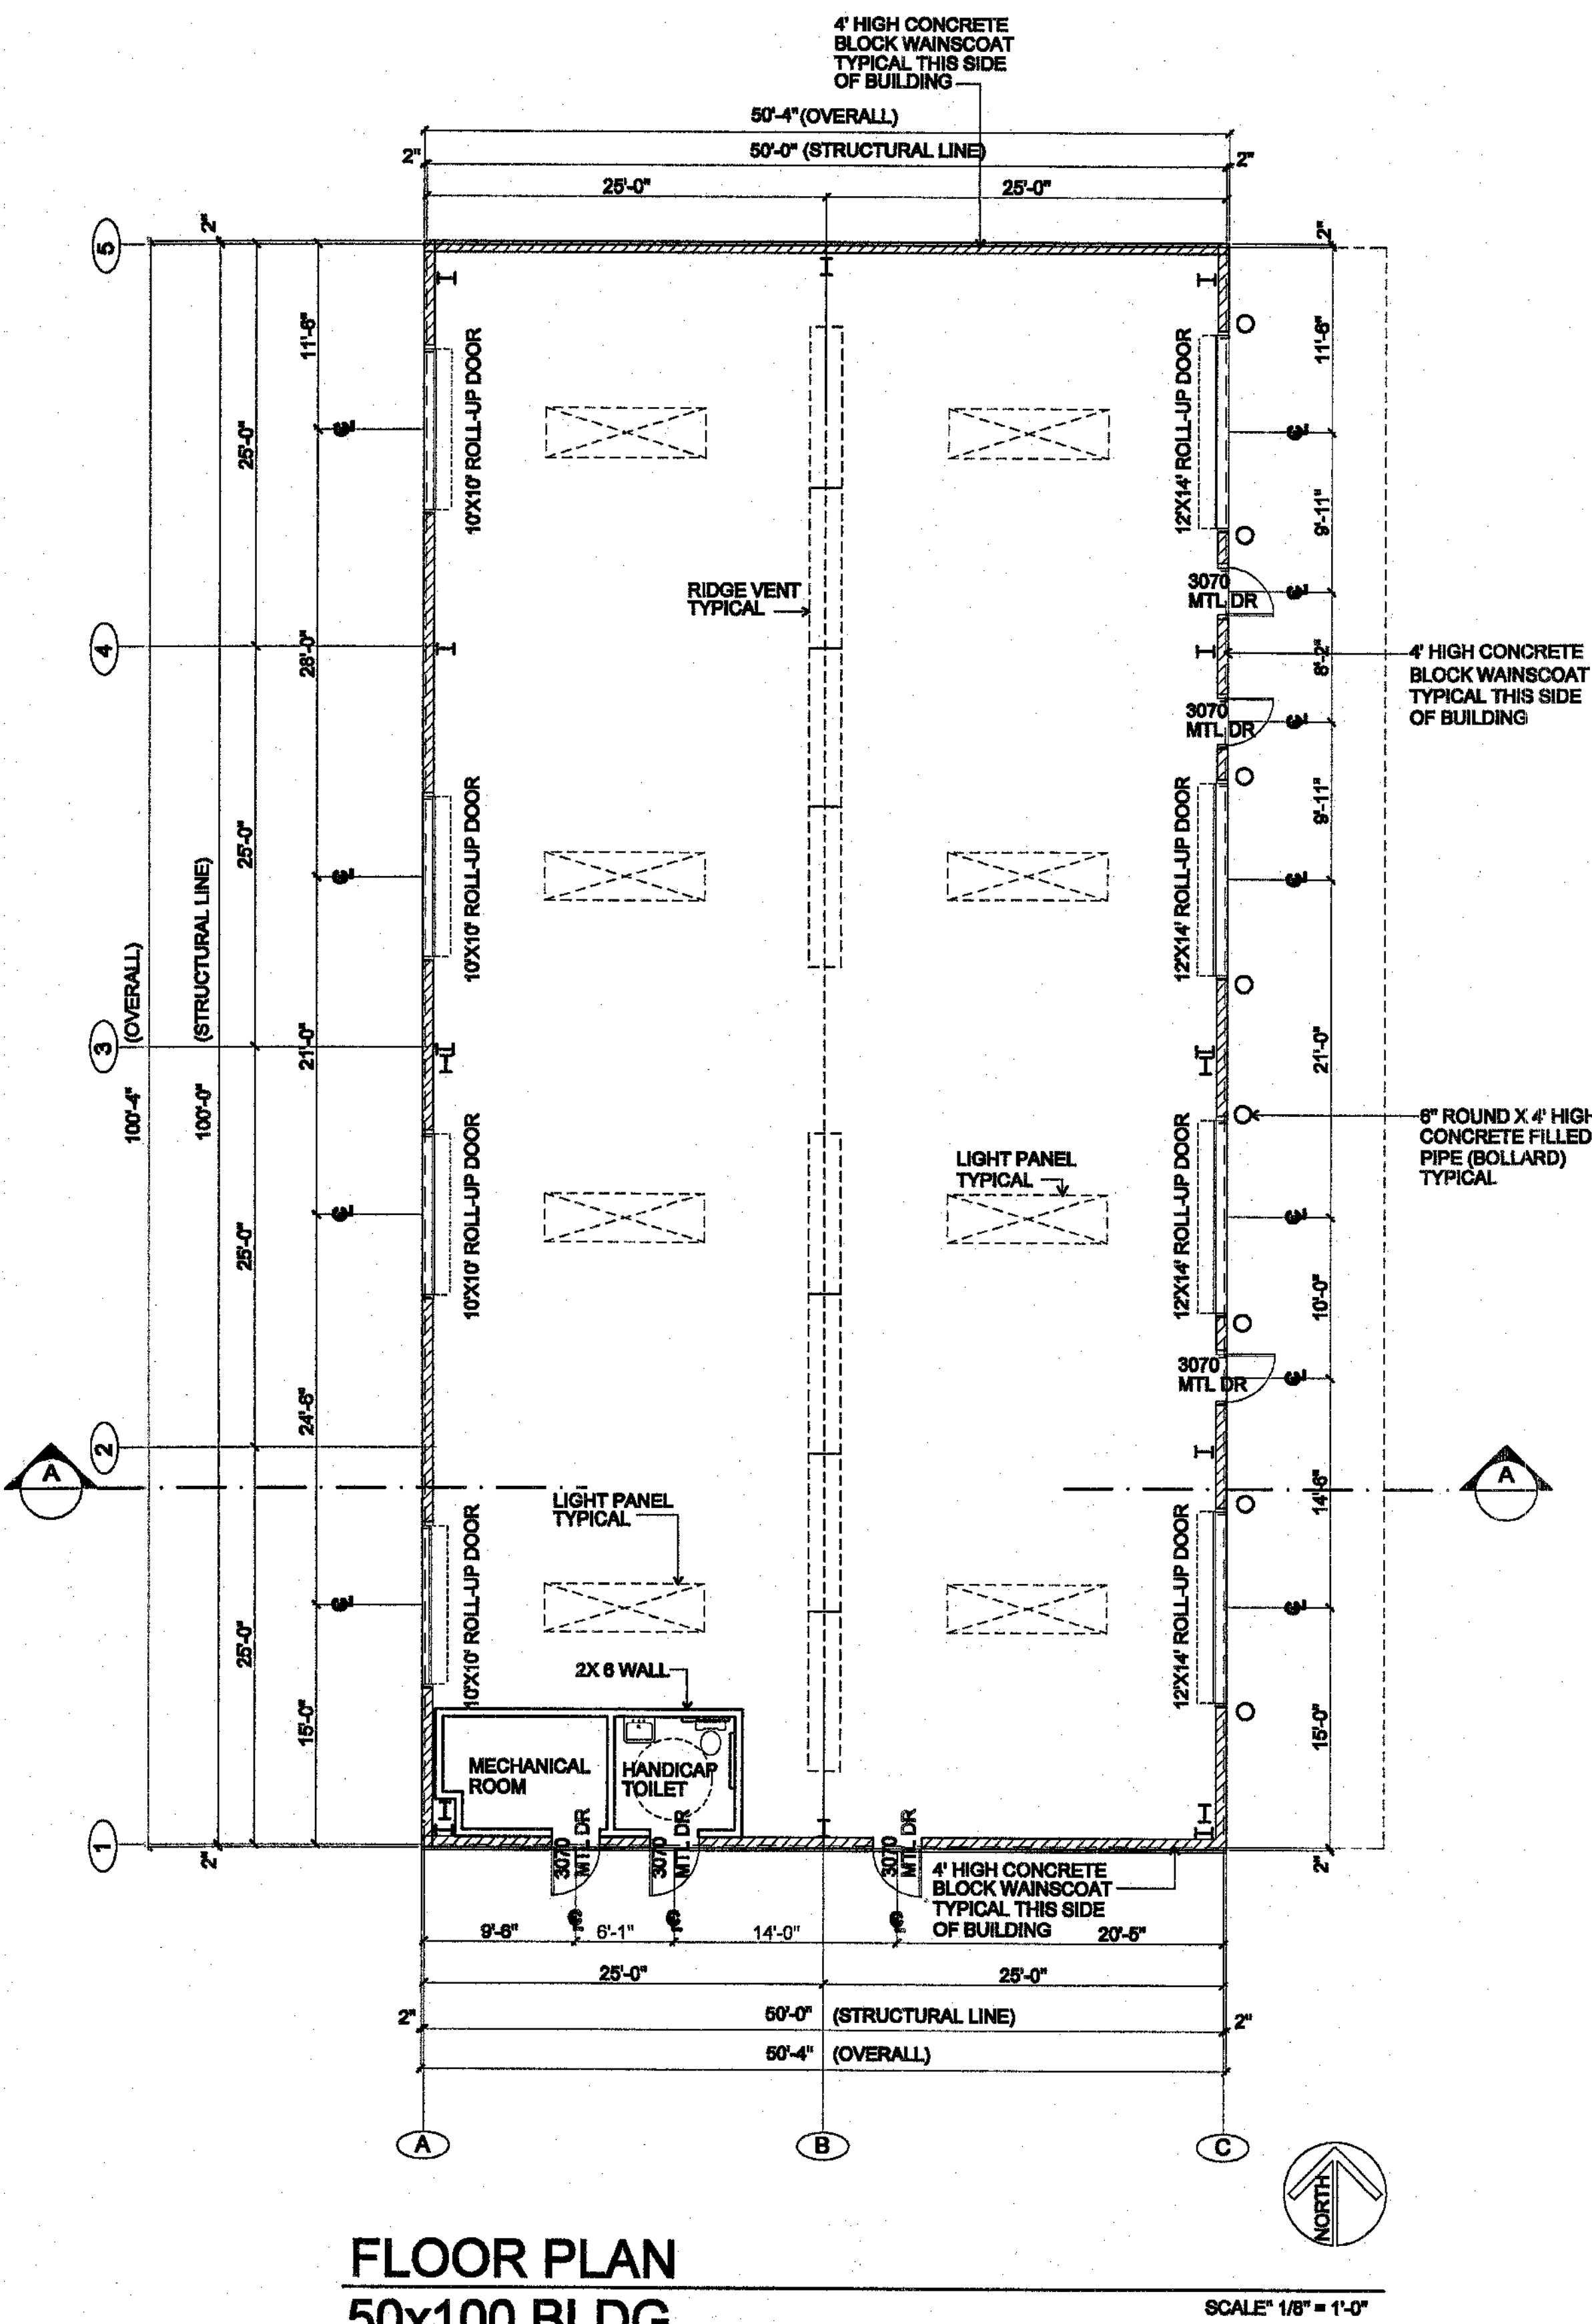


1 HANDICAP TOILET
SCALE: 3/8"=1'-0"

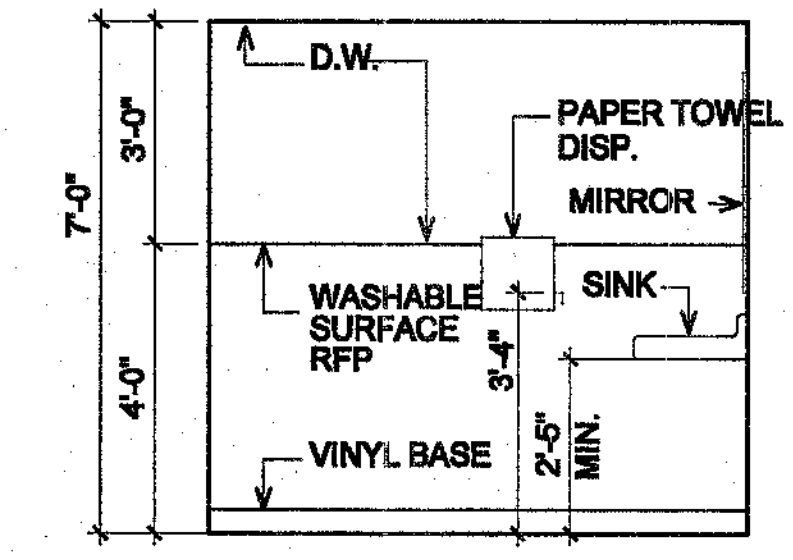

2 HANDICAP TOILET
SCALE: 3/8"=1'-0"

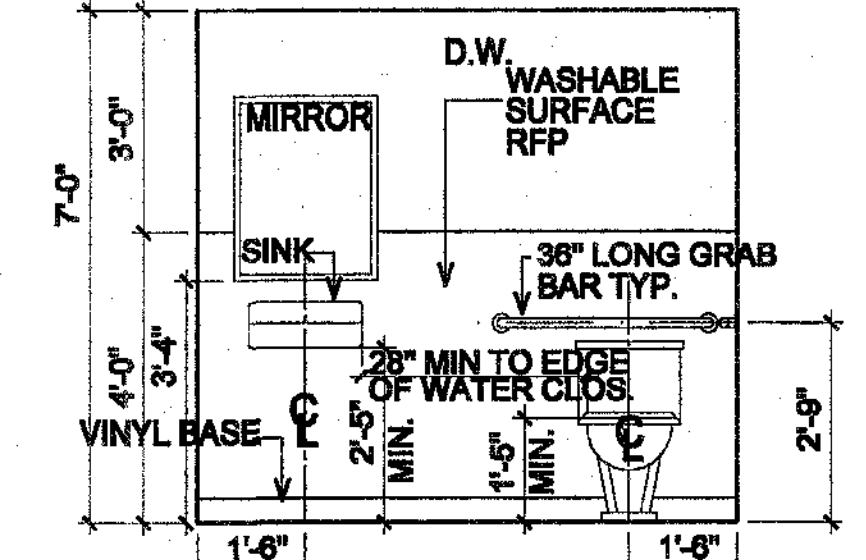


3 HANDICAP TOILET
SCALE: 3/8"=1'-0"

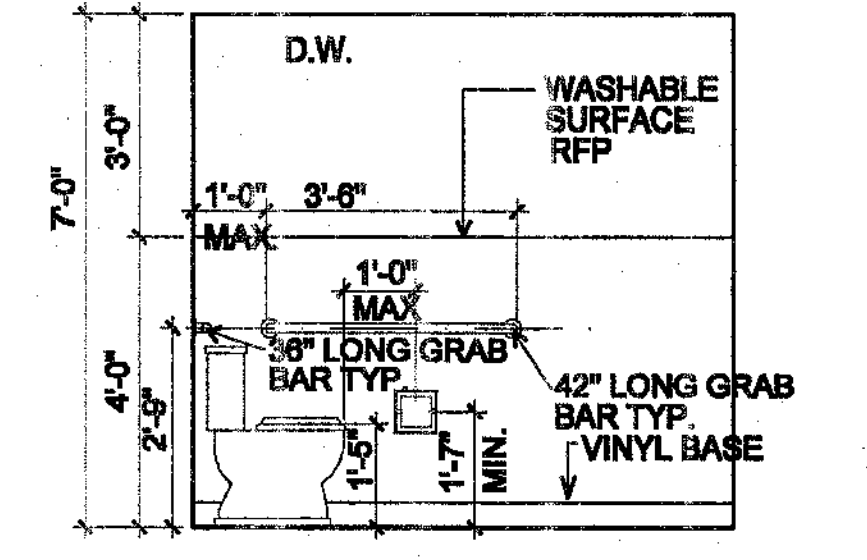


4 HANDICAP TOILET
SCALE: 3/8"=1'-0"

An Office and Storage Facility for:
James Hanousek
Tracer Place
Indio, California

Architect:
Charles W. McBride
74-133 El Paseo, Suite 11
Palm Desert, CA 92260
(760)346-5300
(760)346-7981 Fax
License # C12905

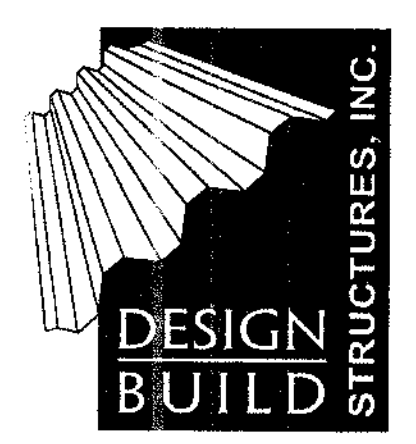


Title: Construction Documents
Date: January 15, 2004
Revised:

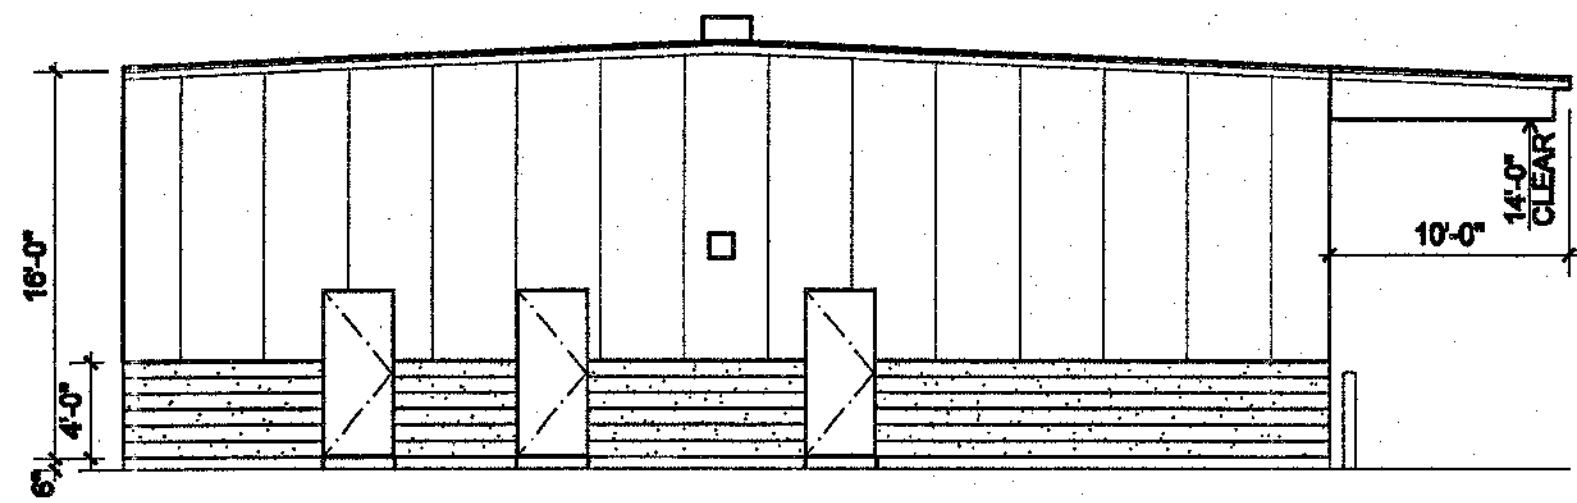


SOUTH ELEVATION

SCALE: 1/8" = 1'-0"

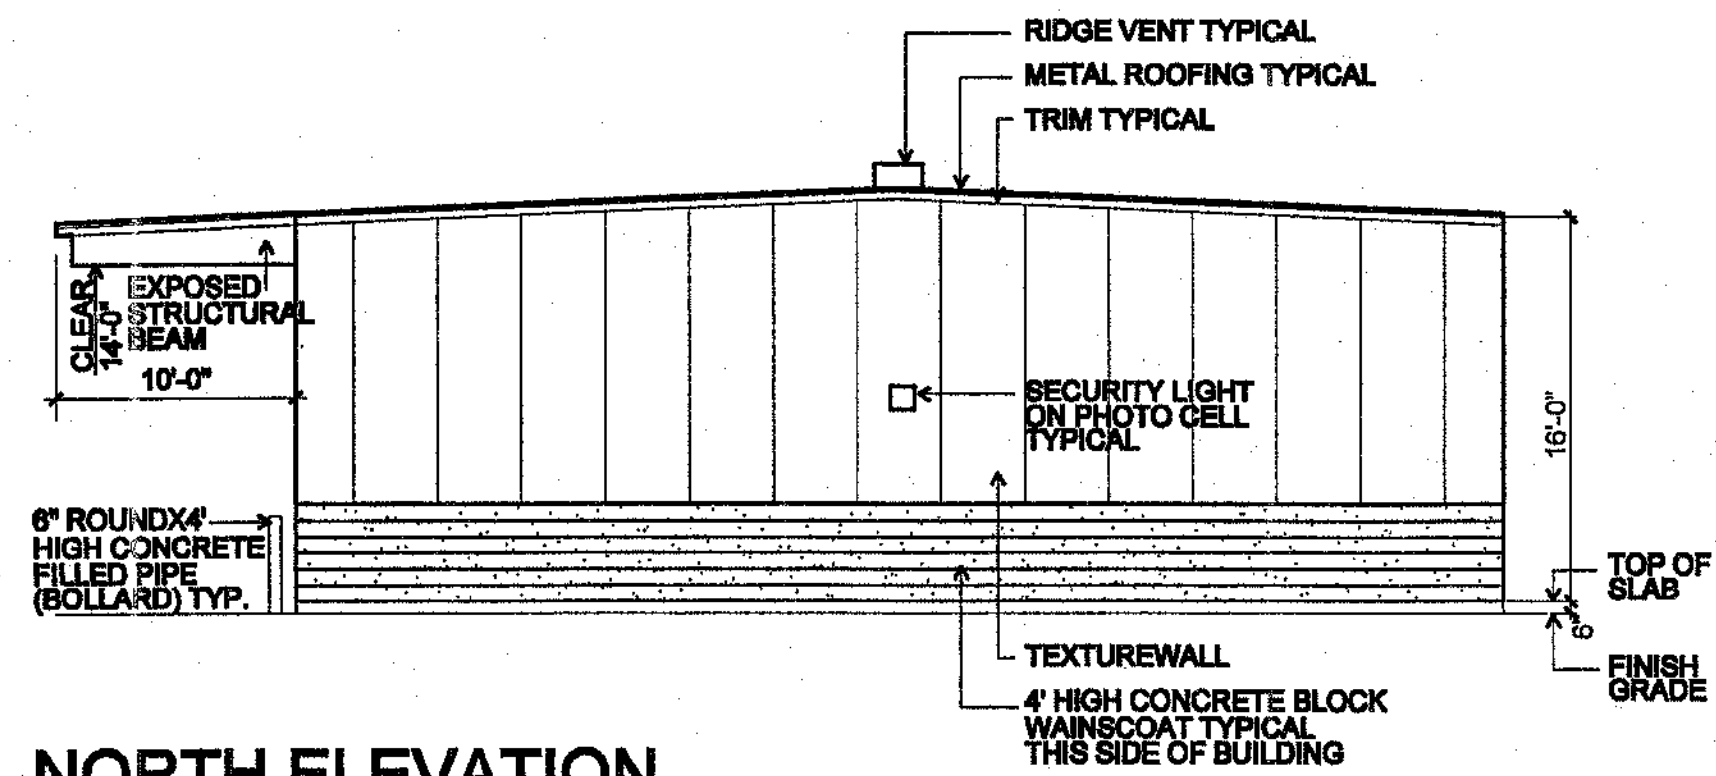


NORTH ELEVATION

SCALE: 1/8" = 1'-0"

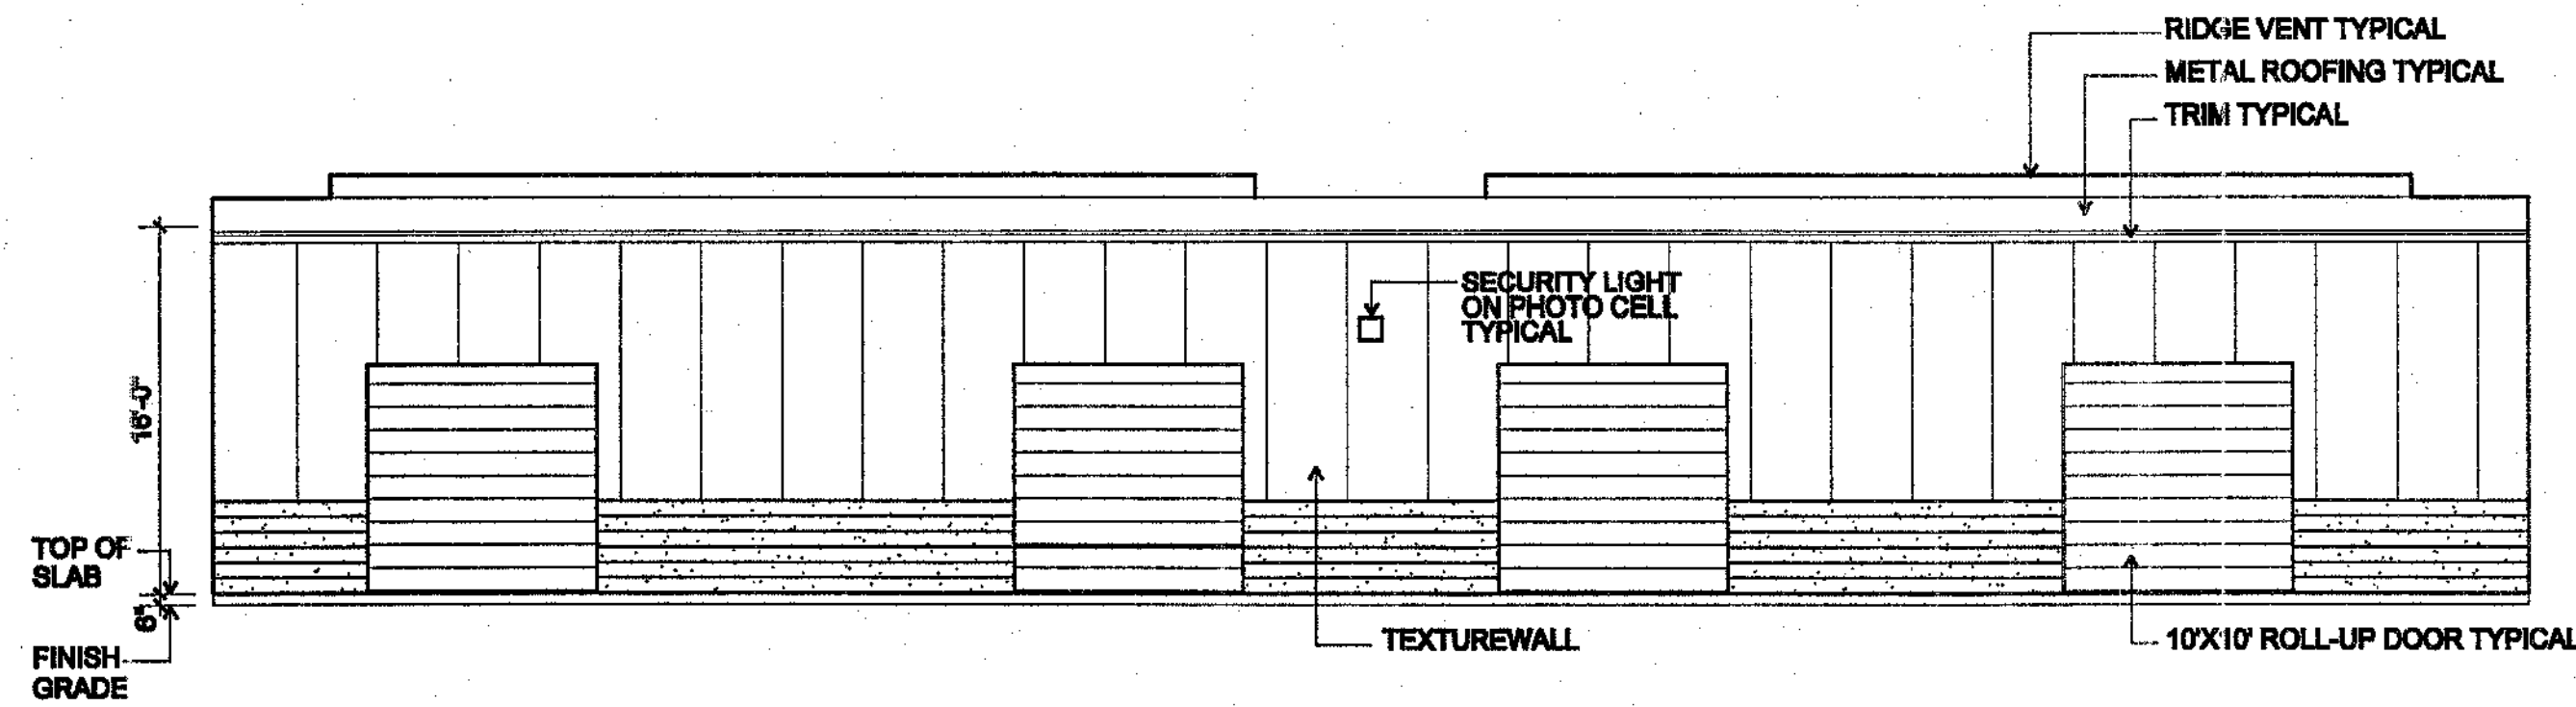


WEST ELEVATION

SCALE: 1/8" = 1'-0"

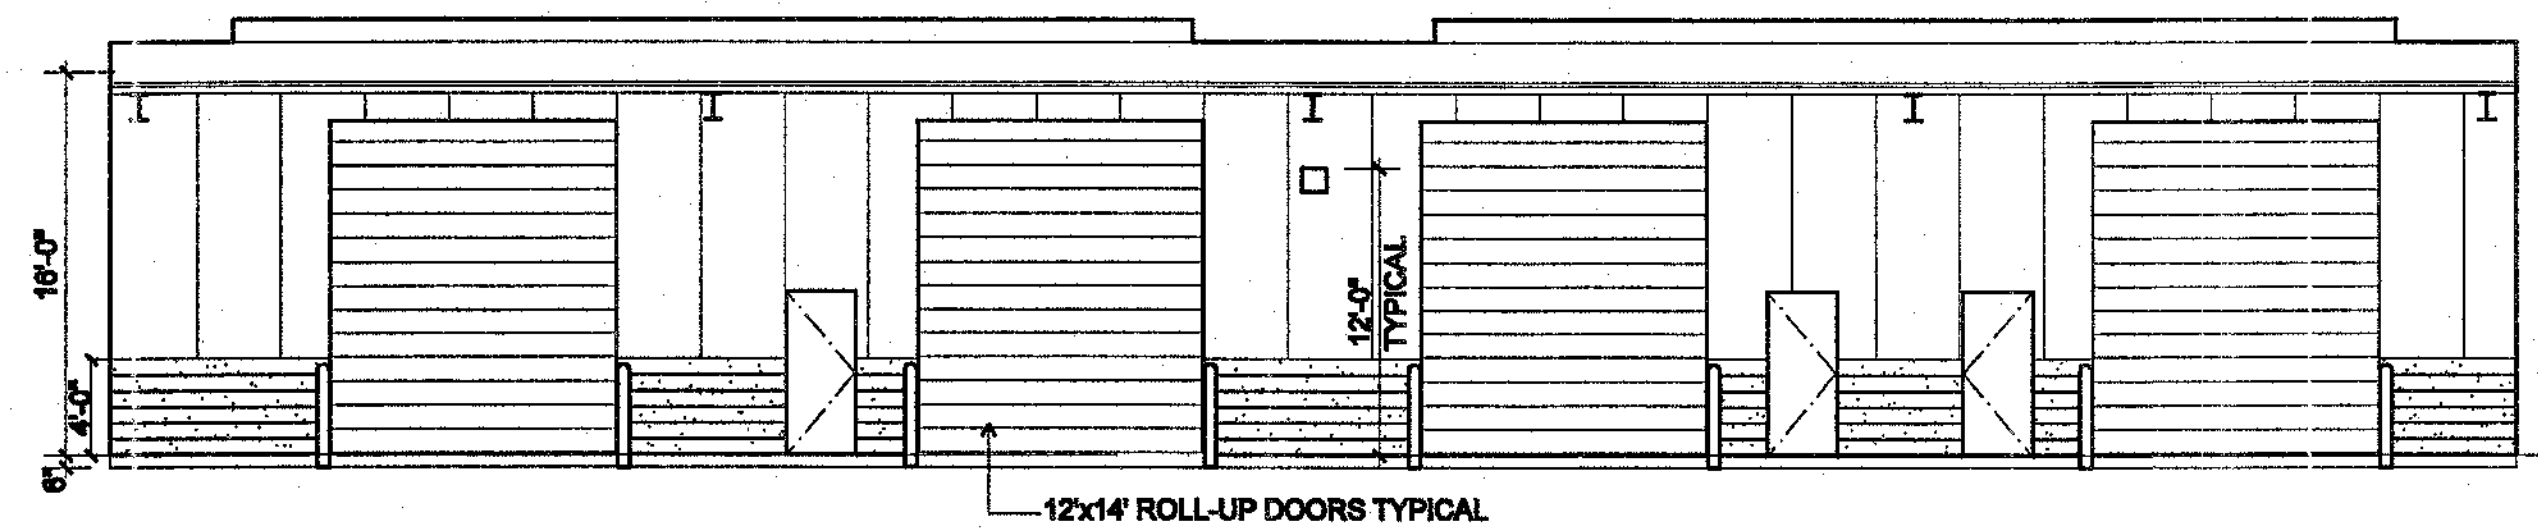

EAST ELEVATION

SCALE: 1/8" = 1'-0"

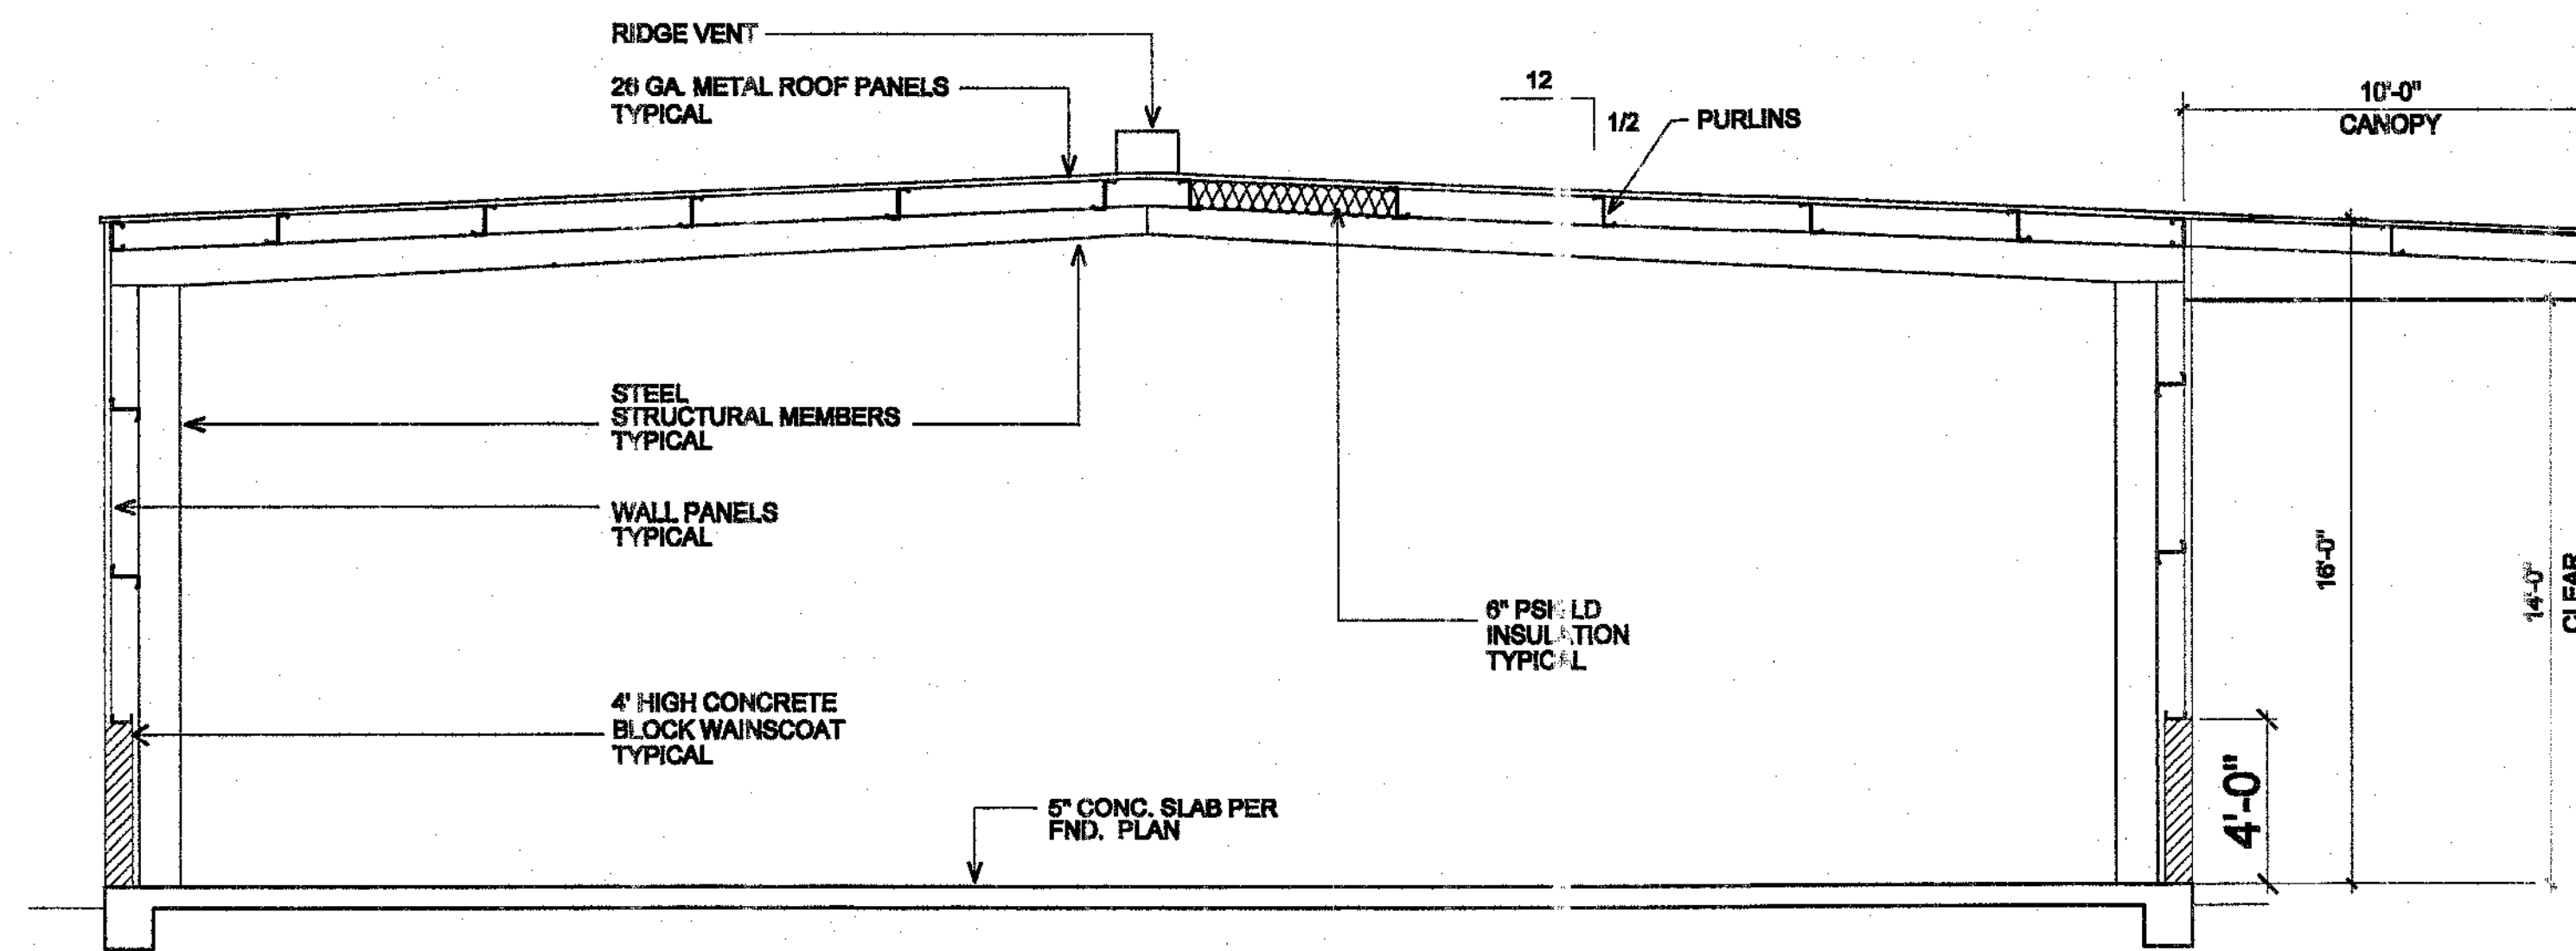


A-A SECTION


SCALE: 1/4" = 1'-0"

An Office and Storage Facility for:
James Hanousek
Trader Place
Incio, California

Architect:
Charles W. McBride
74-133 El Paseo, Suite 11
Palm Desert, CA 92260
(760)346-5300
(760)346-7981 Fax
License # C12905


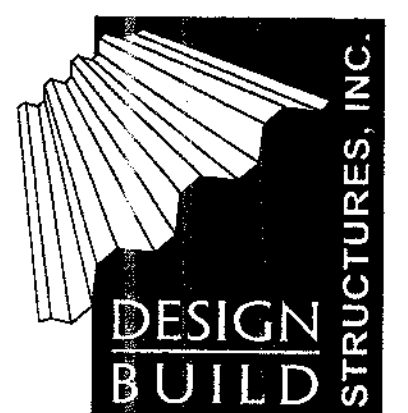


Title: Construction Documents
Date: January 15, 2004
Revised:

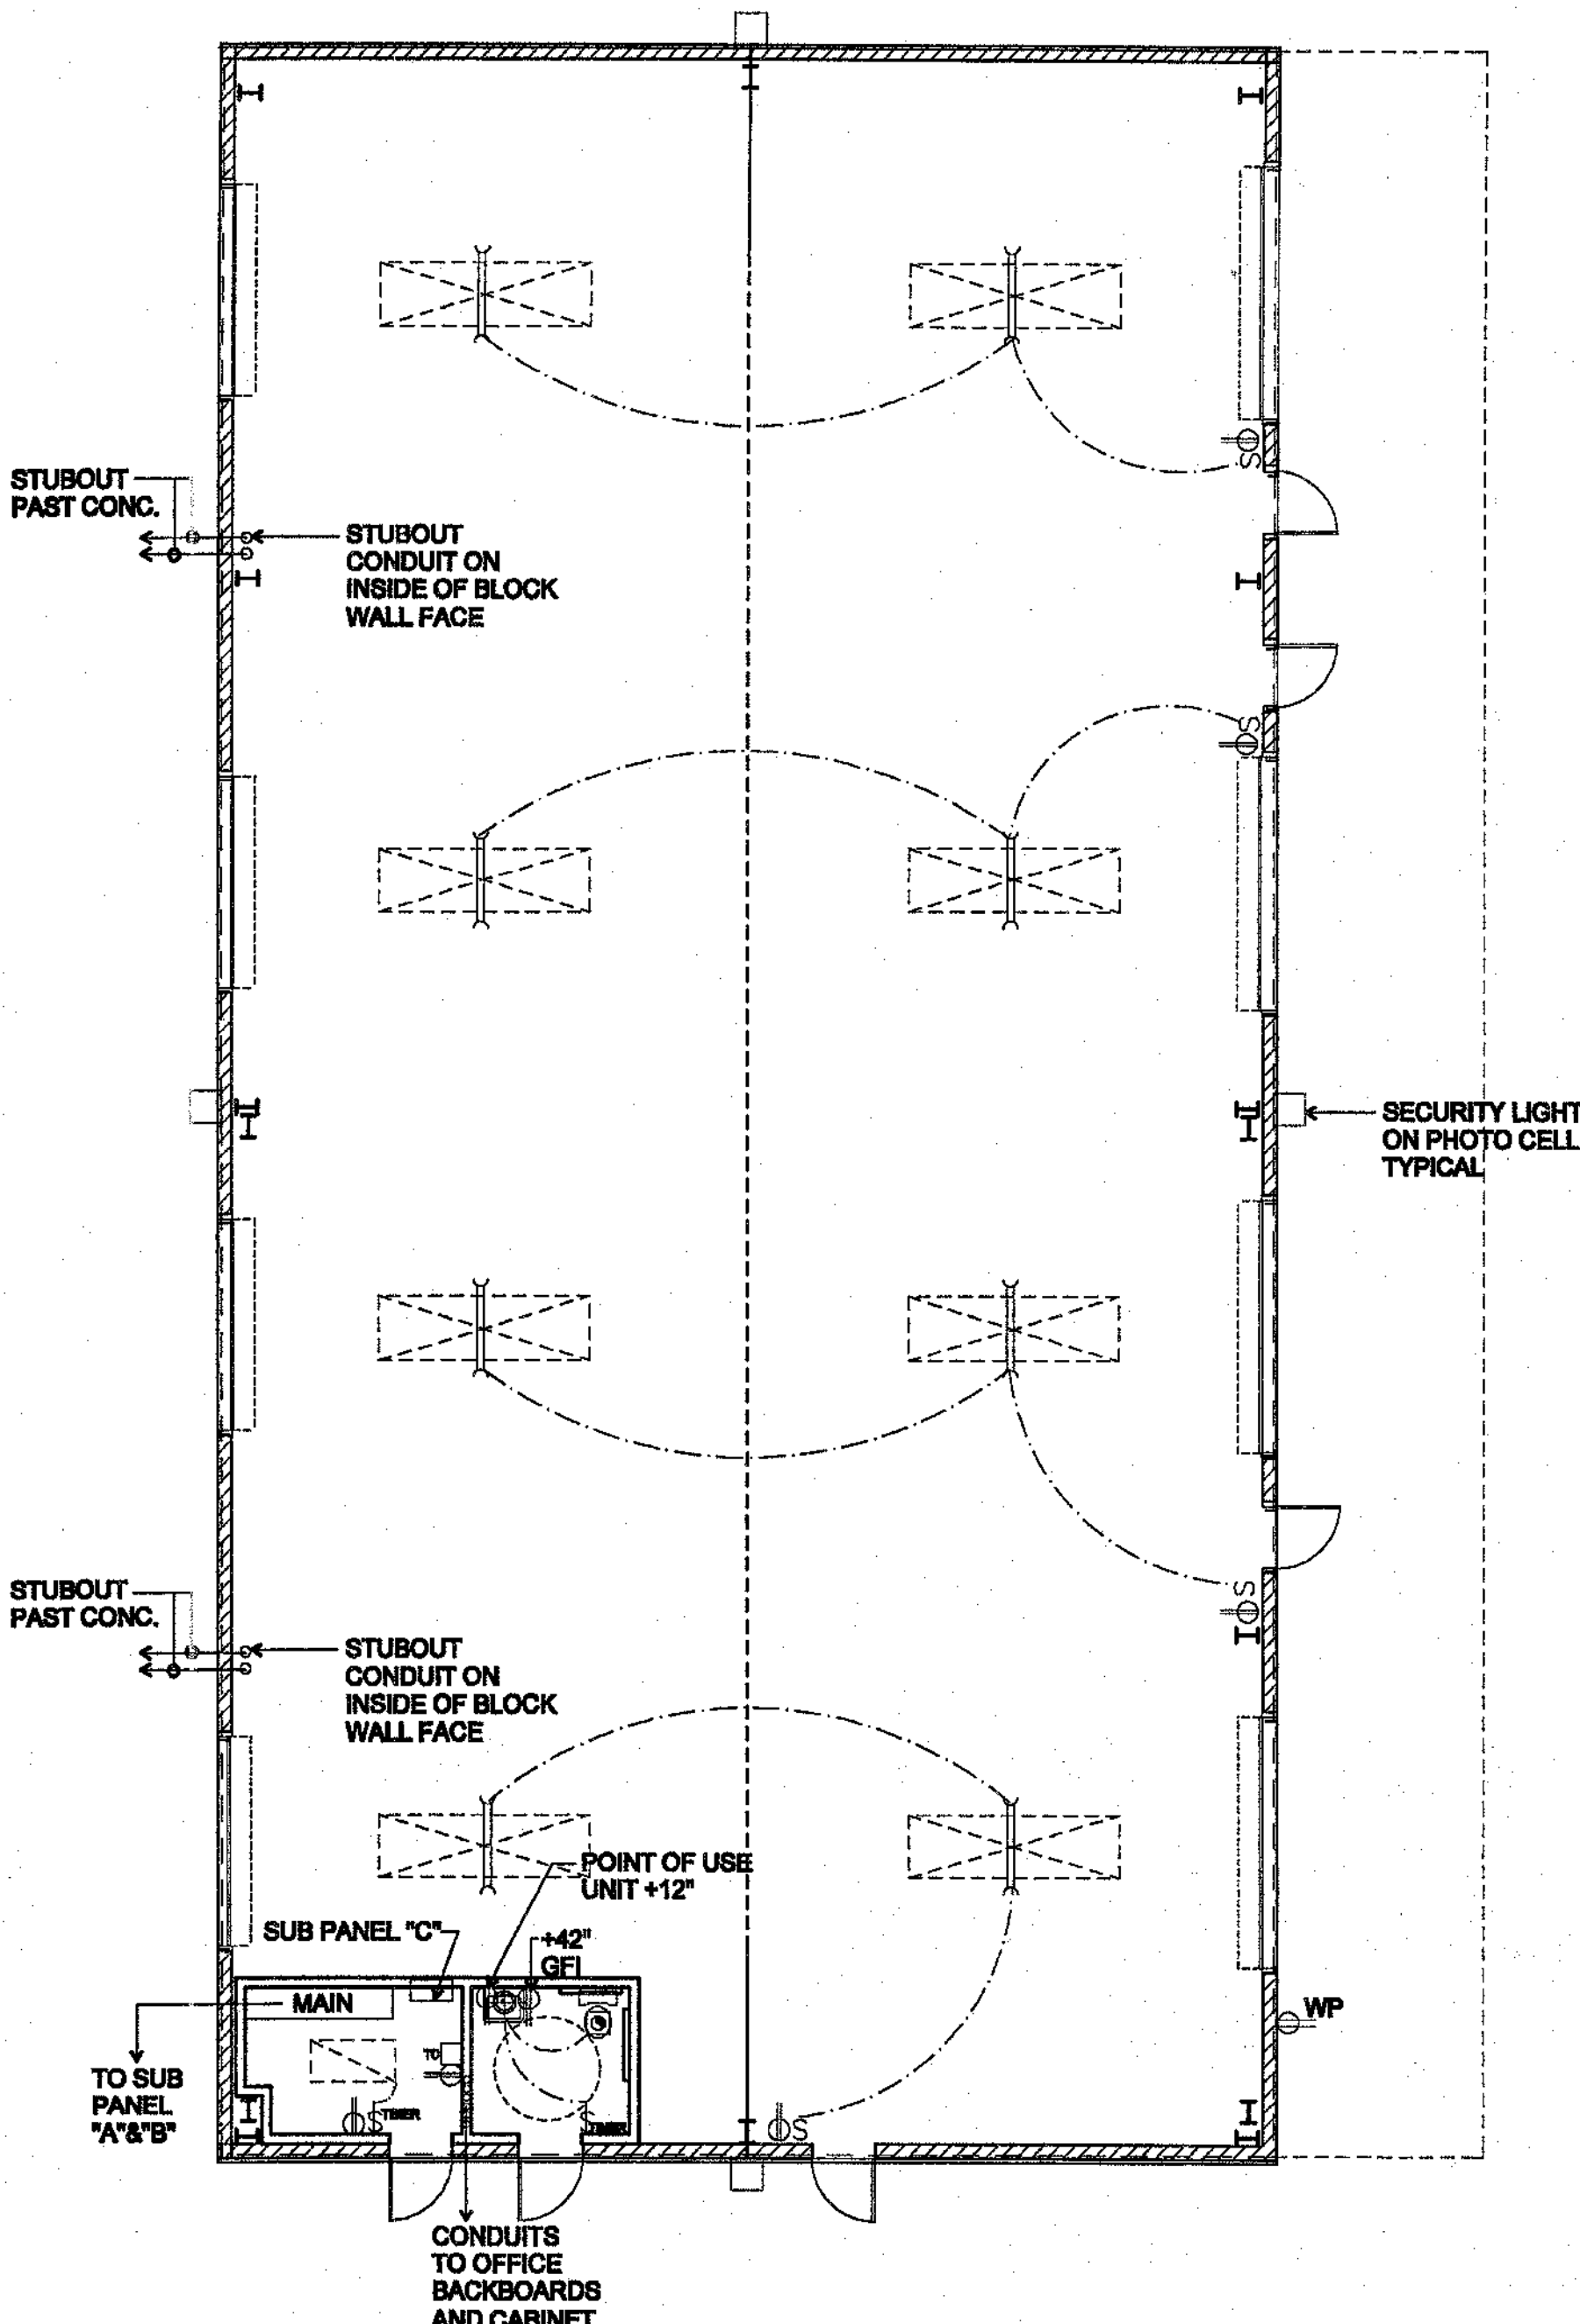


ELECTRICAL PLAN
50x100 BLDG

SCALE: 1/8" = 1'-0"

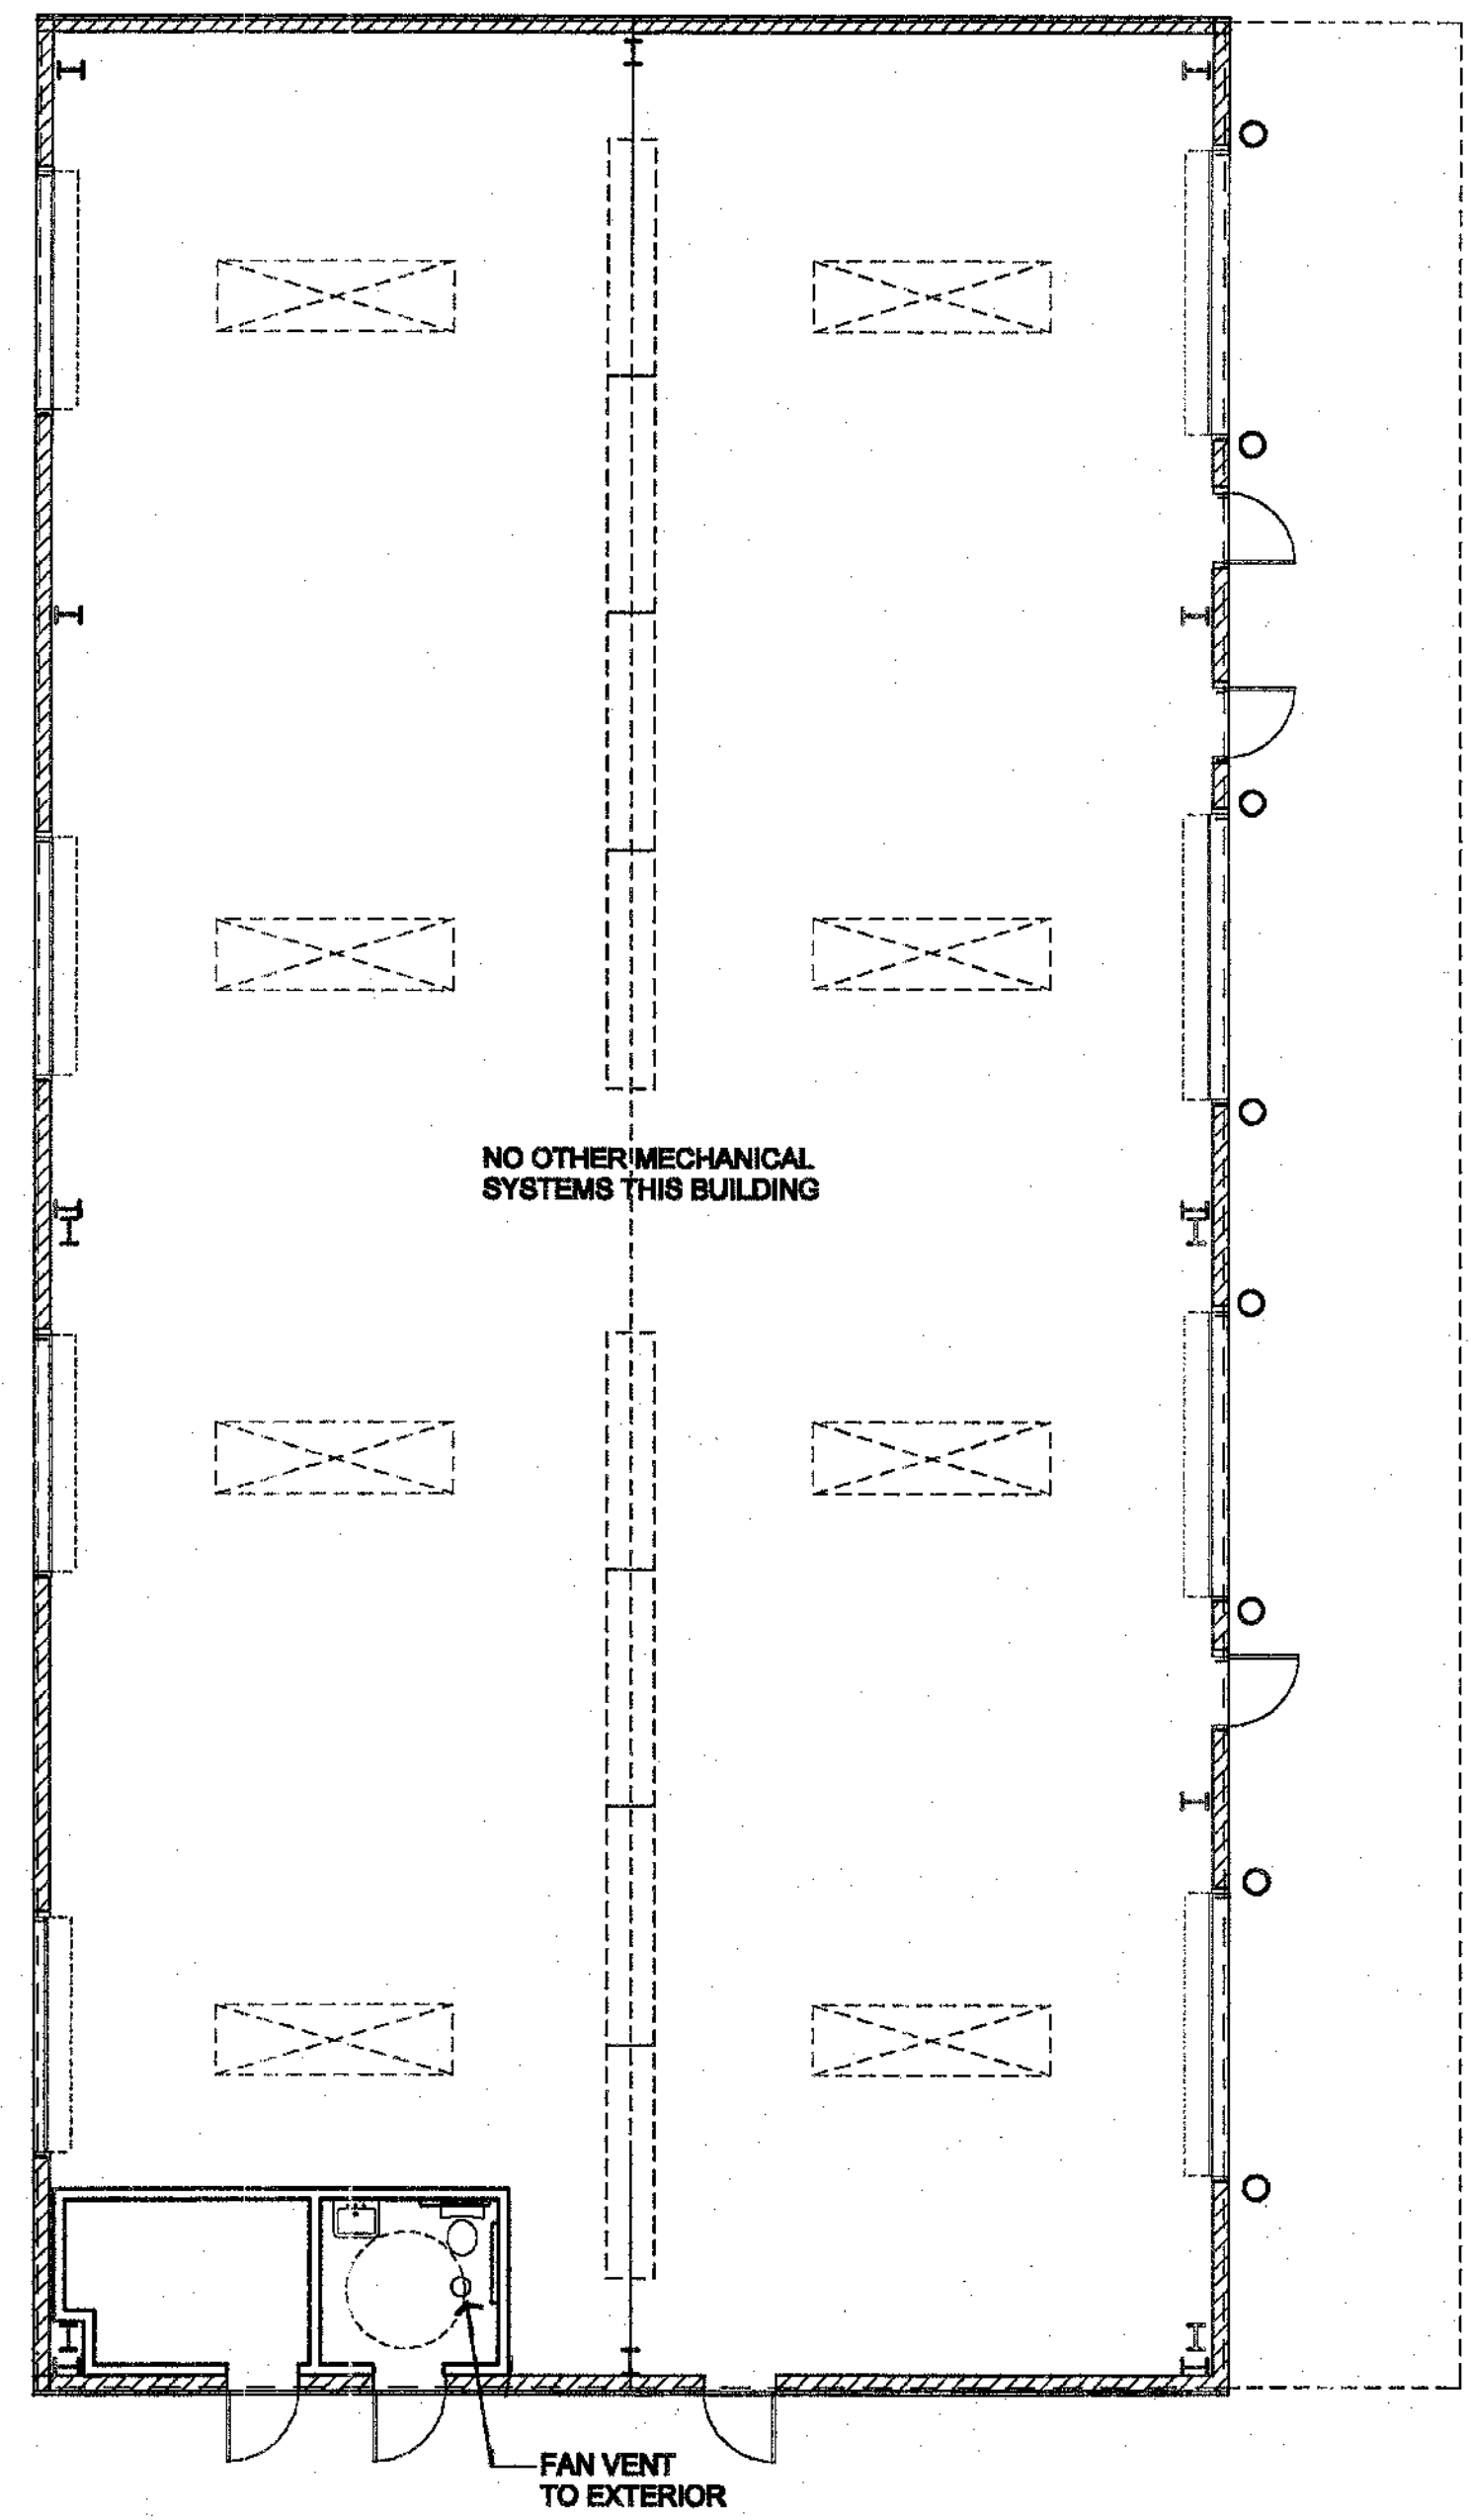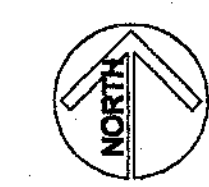

MECHANICAL PLAN
50x100 BLDG

SCALE: 1/8" = 1'-0"

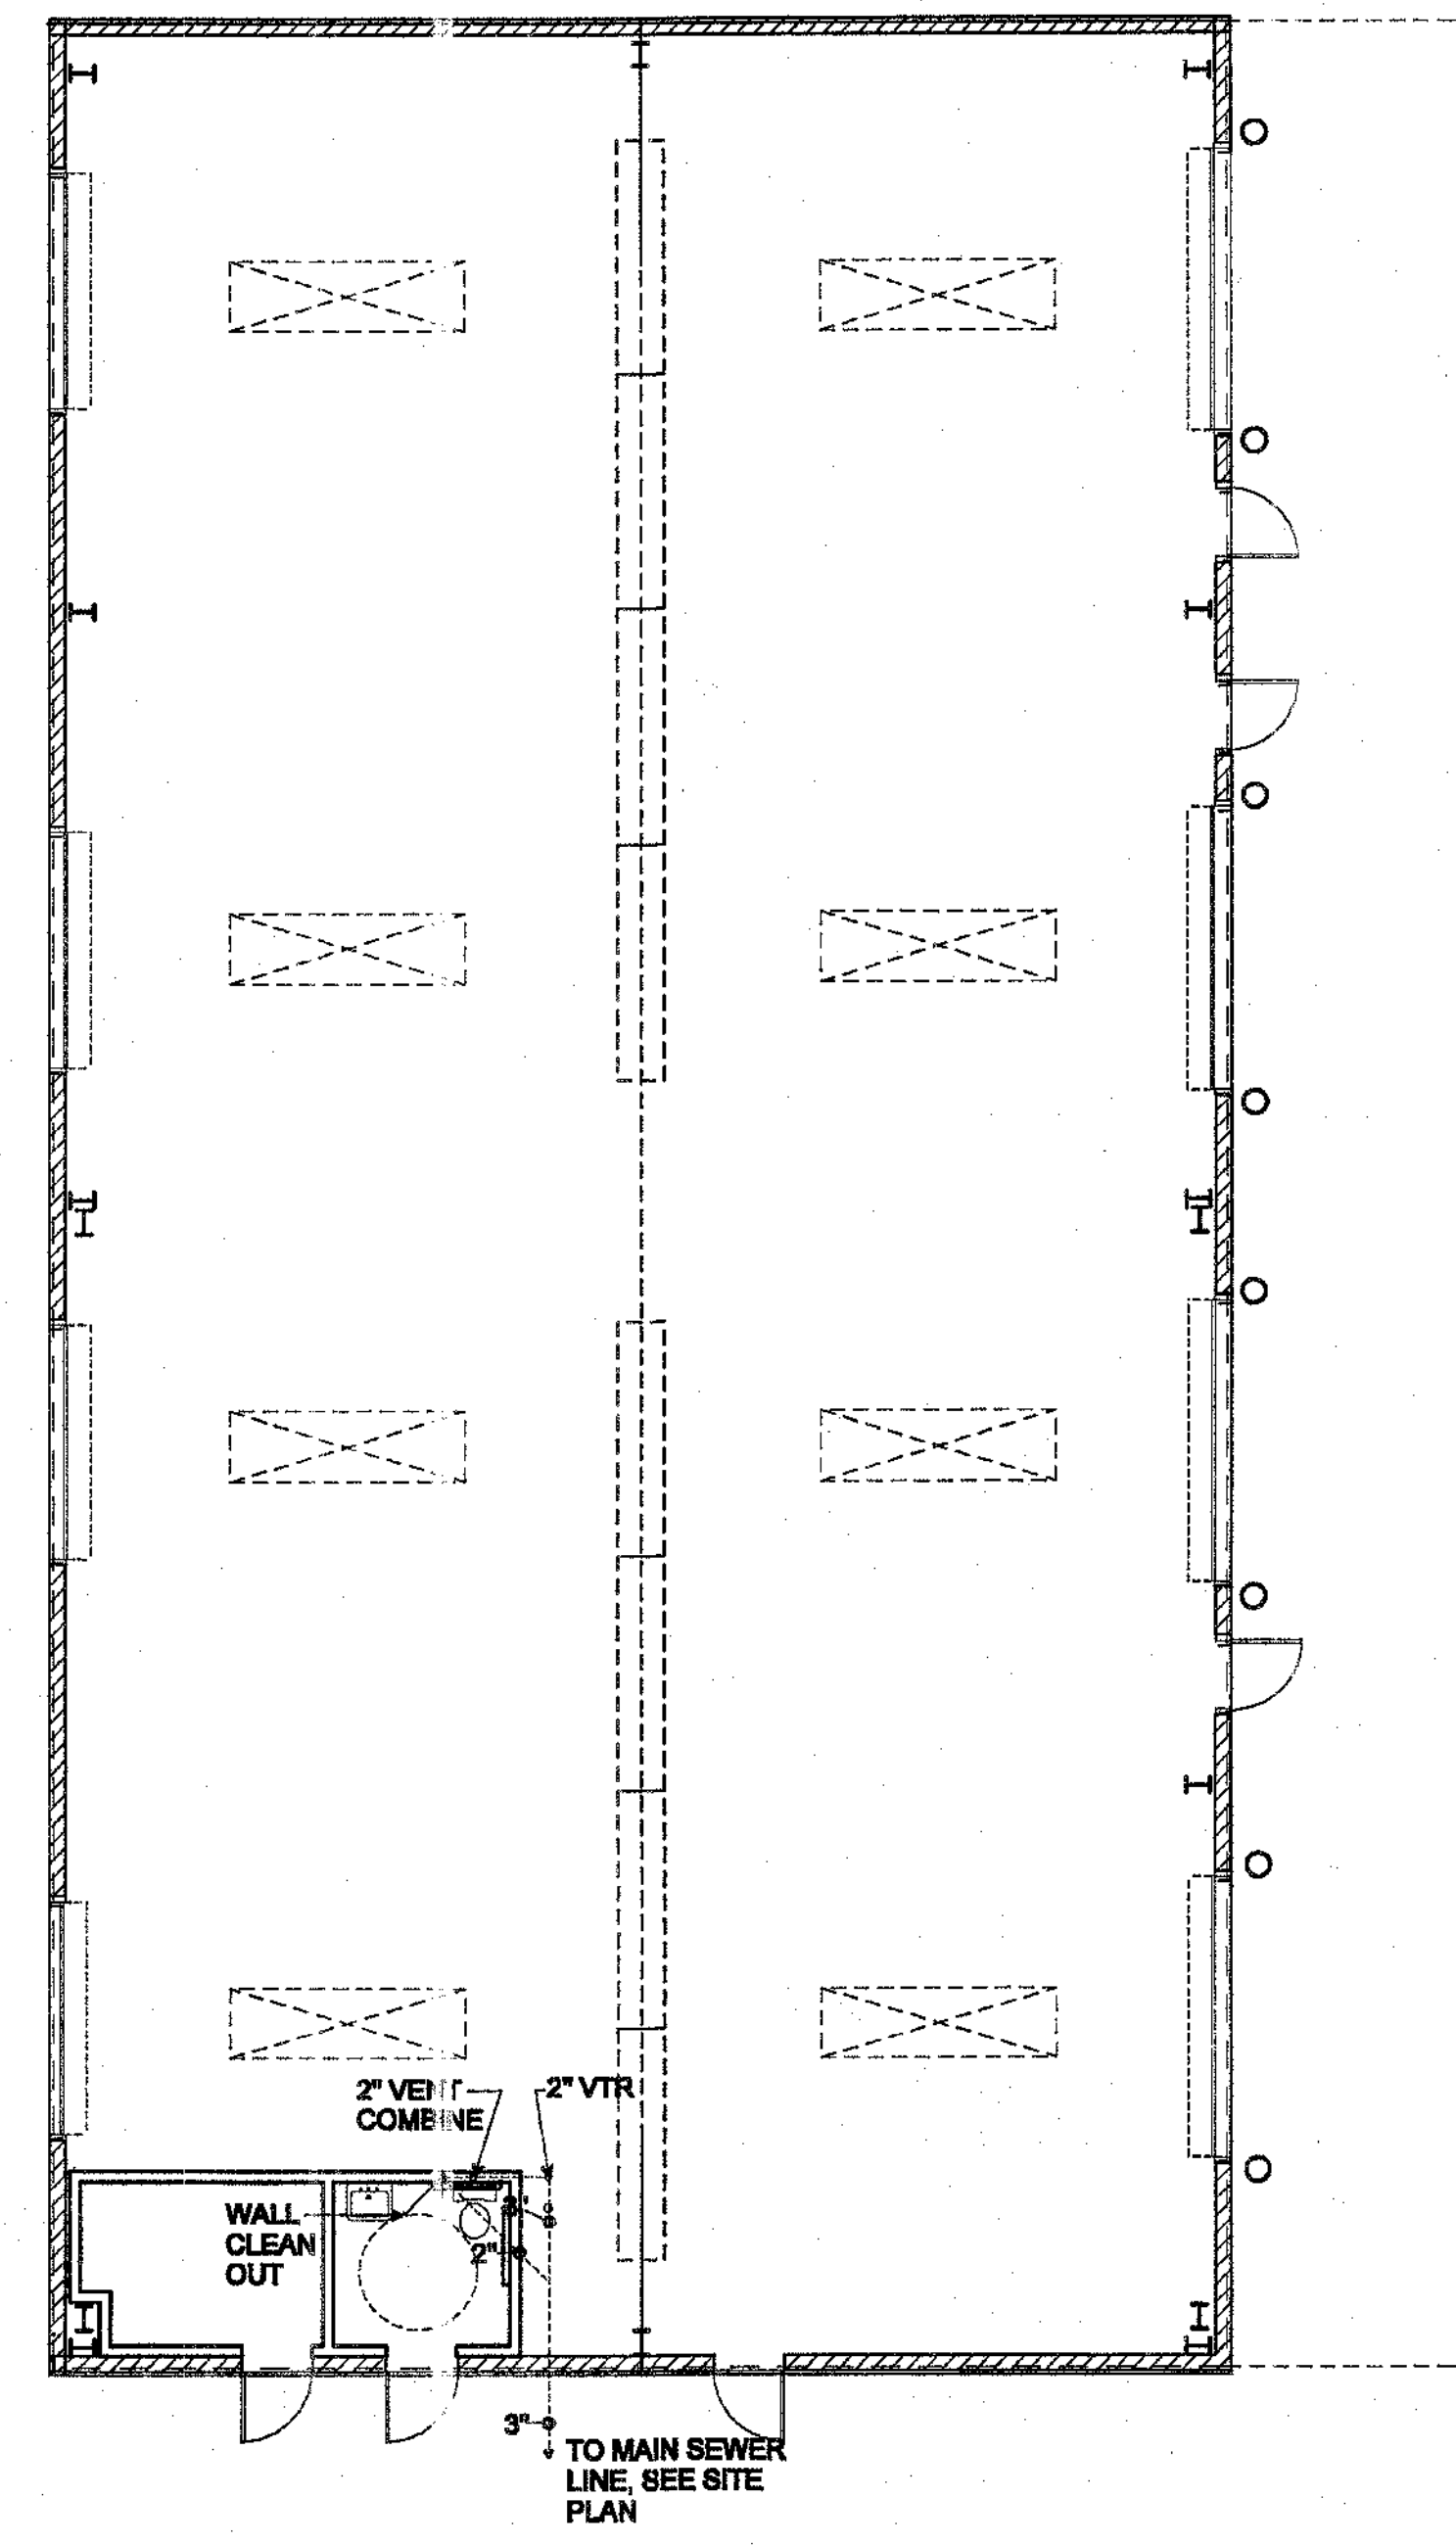

PLUMBING PLAN
50x100 BLDG


SCALE: 1/8" = 1'-0"




- ELECTRICAL LEGEND**
- WALL MOUNTED HOODED SECURITY LIGHT ON PHOTO CELL w/TIMECLOCK OVERRIDE
 - SINGLE POLE SWITCH
 - DUPLEX CONVENIENCE OUTLET
 - GFI WHERE NOTED
 - WATERPROOF CONVENIENCE OUTLET
 - 2-TUBE 4'-0" FLOURESCENT FIXTURE SECURED TO PURLIN
 - RECESSED EXHAUST FAN (VENT BY HVAC)
 - SURFACE MOUNTED LIGHT FIXTURE
 - SWITCH WITH TIMER
 - 2-TUBE 2'-0"X4'-0" FLOURESCENT FIXTURE SURFACE MTD. TO DRYWALL CEILING
 - MAIN SWITCH GEAR (SIZED FOR OFFICE, STORAGE BUILDING, SITE WORK, AND FUTURE STORAGE BUILDING)
 - SUB PANEL
 - TIME CLOCK FOR SECURITY LIGHTS

An Office and Storage Facility for:
James Hanousek
Trailer Place
Indio, California


Architect:
Charles W. McBride
74- 33 El Paseo, Suite 11
Palm Desert, CA 92260
(760)346-5300
(760)346-7981 Fax
License # C12905

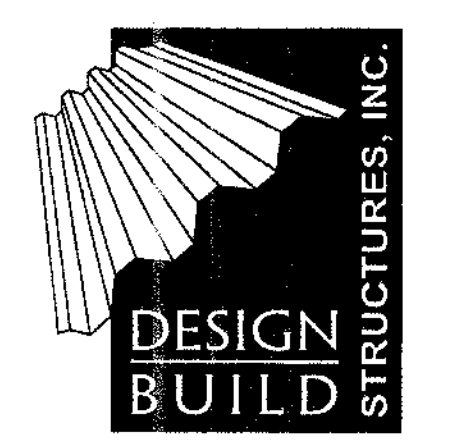


Title: Construction Documents
Date: January 15, 2004
Revised:

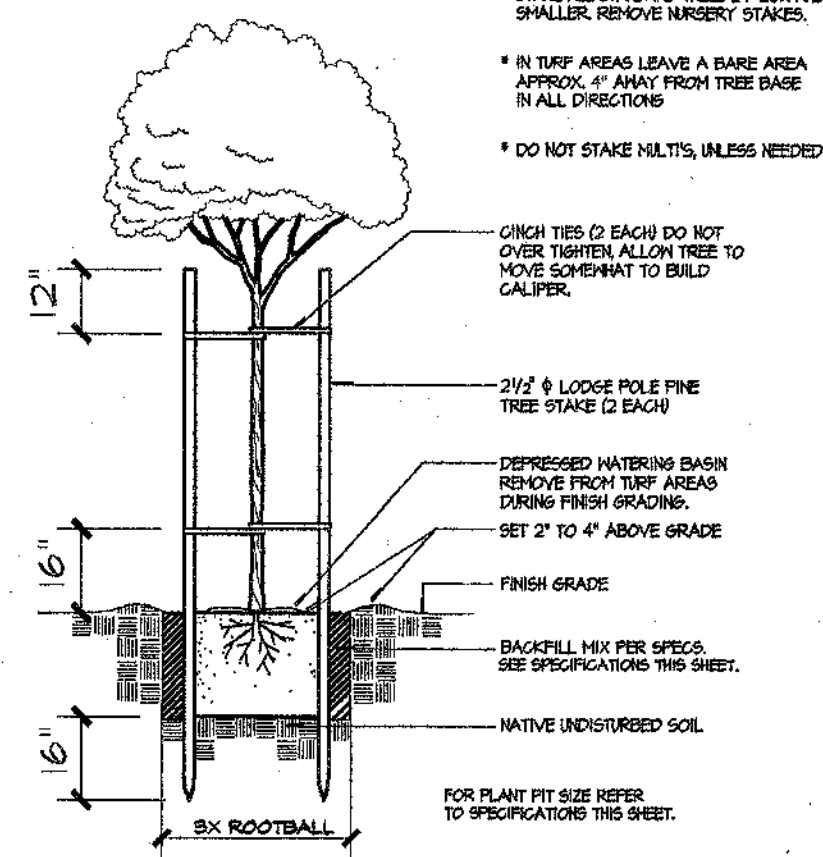


B TREE PLANTING W/ DOUBLE STAKING
N.T.S.

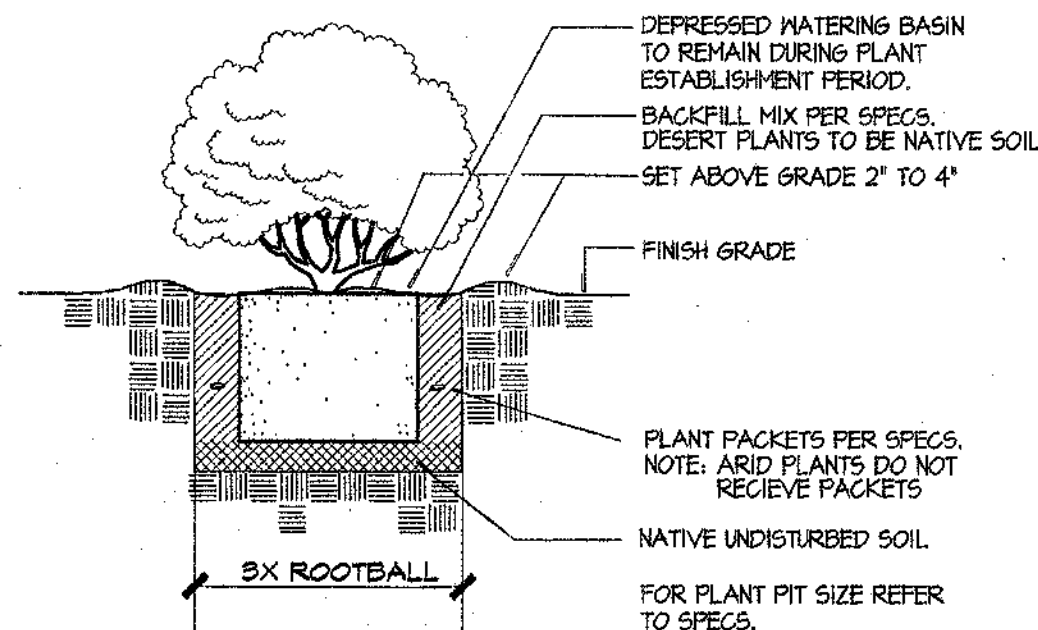


C SHRUB PLANTING
N.T.S.

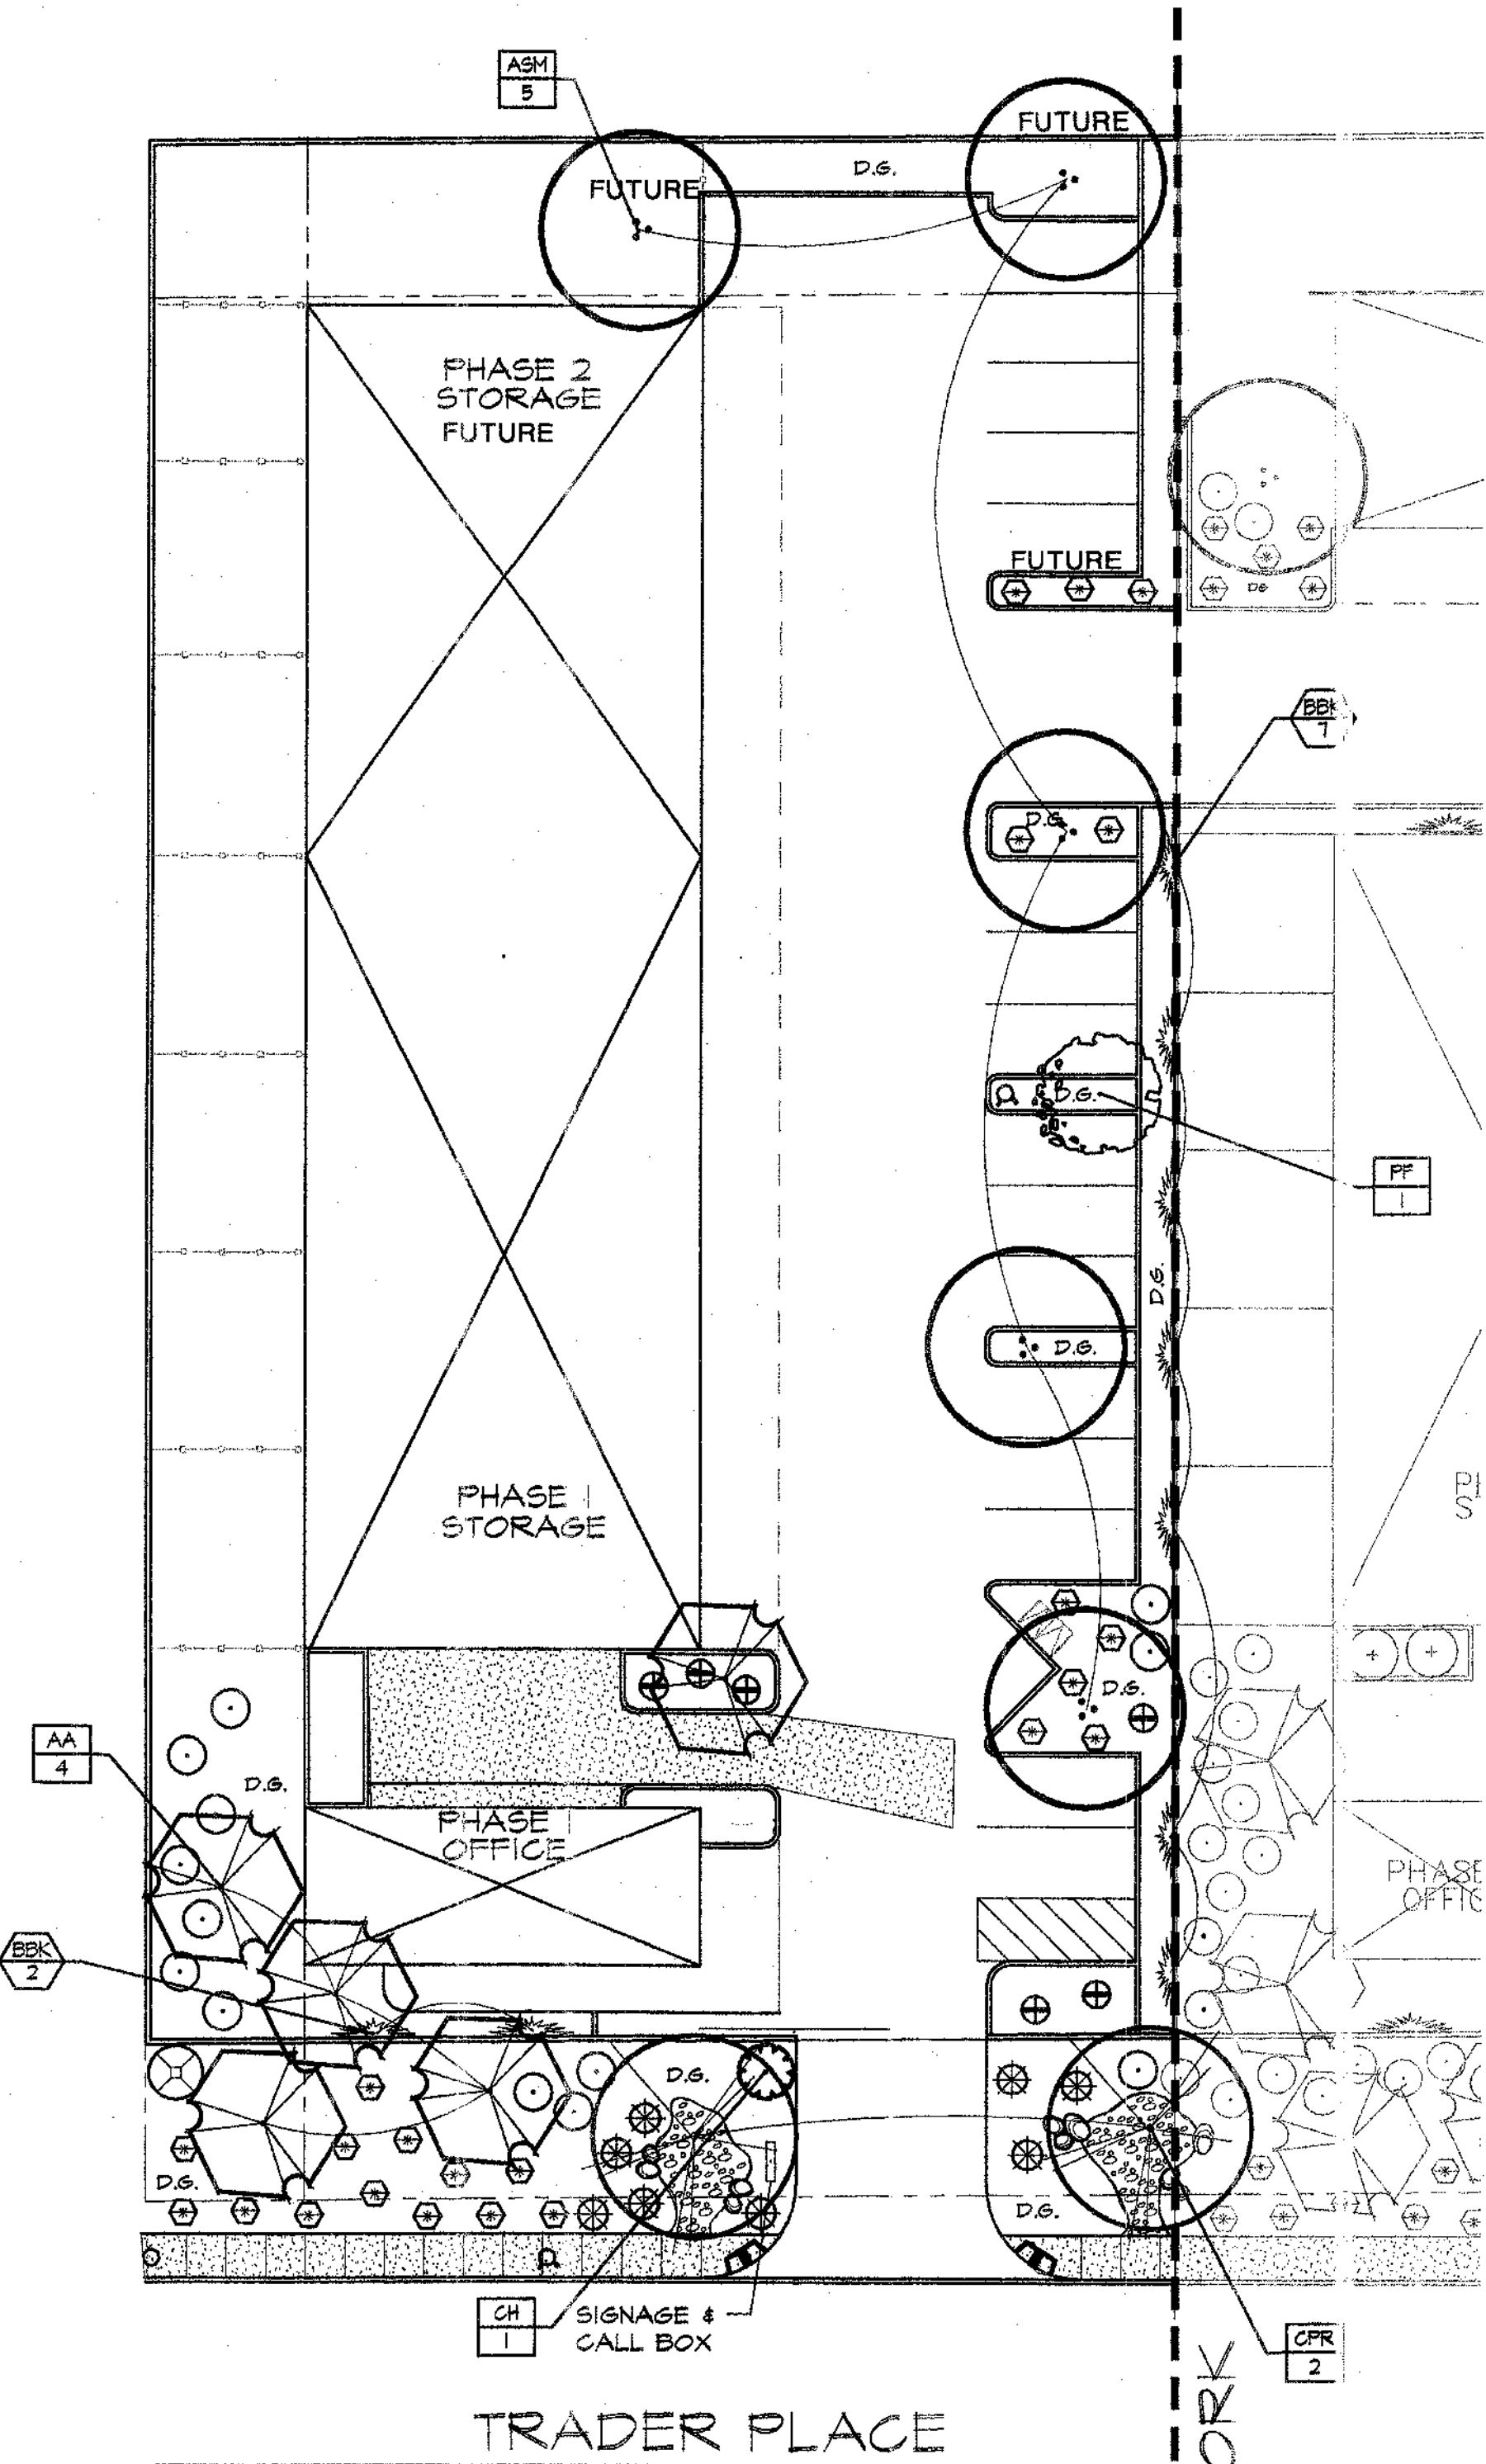

PLANT LEGEND

 CANOPY TREES				
SYM. NAME	SIZE	QTY.	COMMENTS	
AA <i>Acacia aneura</i> Ninga	24" box	5		
ASM <i>Acacia smallii</i> Weeping Acacia	24" BOX	5	MULTI-TRUNK	
PF <i>Phacellobium Pluviale</i> Texas Ebony	24" BOX	1	STANDARD	
CPR <i>Cercidium praecox</i> Sonoran Palo Verde	24" BOX	2	MULTI-TRUNK	
SHRUBS				
SYM. NAME	WATER USAGE	SIZE	QTY.	COMMENTS
 <i>Chamaecrops humilis</i> Mediterranean Fan Palm		24" box	1	Mult-trunk
SHRUBS				
SYM. NAME	WATER USAGE	SIZE	QTY.	COMMENTS
 <i>Bougainvillea Rosea</i> <i>Bougainvillea Rosea</i>	(L/M)	5 gal.	8	Low growing
 <i>Casatophila pulcherrima</i> <i>Barbados Pride</i>		5 gal.	1	
 <i>Cassia nemophila</i> <i>Green Cassia</i>		5 gal.	15	
 <i>Lantana montevideensis</i> "New Gold" <i>Yellow Trailing Lantana</i> (L/M)		1 gal.	25	Yellow
 <i>Mastembleria capillaris</i> "Regal mist" <i>Regal Mist</i>		1 gal.	4	
VINES				
SYM. NAME	WATER USAGE	SIZE	QTY.	COMMENTS
BEK <i>Bougainvillea</i> "Barbara Kari" <i>Bougainvillea</i>		5 gal.	4	
DESERT ACCENTS				
SYM. NAME	WATER USAGE	SIZE	QTY.	COMMENTS
 <i>Daylily wheeleri</i> Desert spoon	(L/M)	5 gal.	8	
GROUND COVERS				
SYM. NAME	WATER USAGE	SIZE	QTY.	COMMENTS
 <i>Gray granite Cobble</i> <i>Permeable Stone</i>		8" - 12" DIA.		
 <i>Blasted granite Boulders - Permeable</i> <i>Bury 1/3 of size of boulder</i>		3" - 5" DIA.		
 <i>DECOMPOSED GRANITE 'MOJAVE GOLD'</i> <i>3/8"- FINES NETTED & ROLLED TO 10% COMPACTION</i>				

- PLANTING NOTES**
- Before any plants are planted, all planted areas are to have been graded in an acceptable manner to assure positive drainage per the grading notes.
 - Separate all shrub/ground cover areas from lawn areas with 2" x 2" redwood headerboard or 5 layers of redwood headerboard with staggered joints (refer to planting plan). Stake headerboard with 1" x 2" x 12" redwood stakes spaced 40" on center maximum.
 - Plant shrubs a minimum of 50" from all landscape light fixtures.
 - Where circumstances permit, plant no tree closer than 18" to an edge of paving or headerboard.
 - Provide all shrubs which need support with 1/2" square redwood stakes. Once installed, trim top of stake 6" below top of shrub. Use green plastic ties.
 - Remove all stakes from vines.
 - Refer to planting details.
 - Whenever possible, use plant materials acclimated to the Coachella Valley.
 - Landscape contractor when tying vines is to use a drill to establish the pilot hole to receive the red-head portion of the molly.
 - When tying vines or espaliers, vines should be spaced as follows: let (2) at 1'-6" apart from finish grade, the next (3) at 1'-0" apart to make the top wire at 6'-0" above finish grade. Vines should be a minimum of 6'-0" long center on plants. When vines or espaliers are closer than 6' apart, use a continuous wire between both plants.
 - For protection of trees in turf areas leave a bare area approx. 4" away from tree base in all directions. For plant pit size refer to specs.
 - Where circumstances permit, do not plant specimen trees closer than four (4) feet from the edge of paving, headerboard, or roof lines. DEERPROOF or approved root barriers are to be installed per detail. Refer to planting legend for species requiring deep root barriers.
 - WARNING:** Plant material listed may or may not have been approved by the Agricultural Commissioner's office. Landscape contractor, please contact the developer for status of Agricultural Commissioner's approval or denial. Plant material not conforming with quarantine laws may be destroyed and civil action taken. All plant material is subject to inspection at the discretion of the Agricultural Commissioner's office. All plant material must be free from Red Scale (*Aonidiella aurantii*).

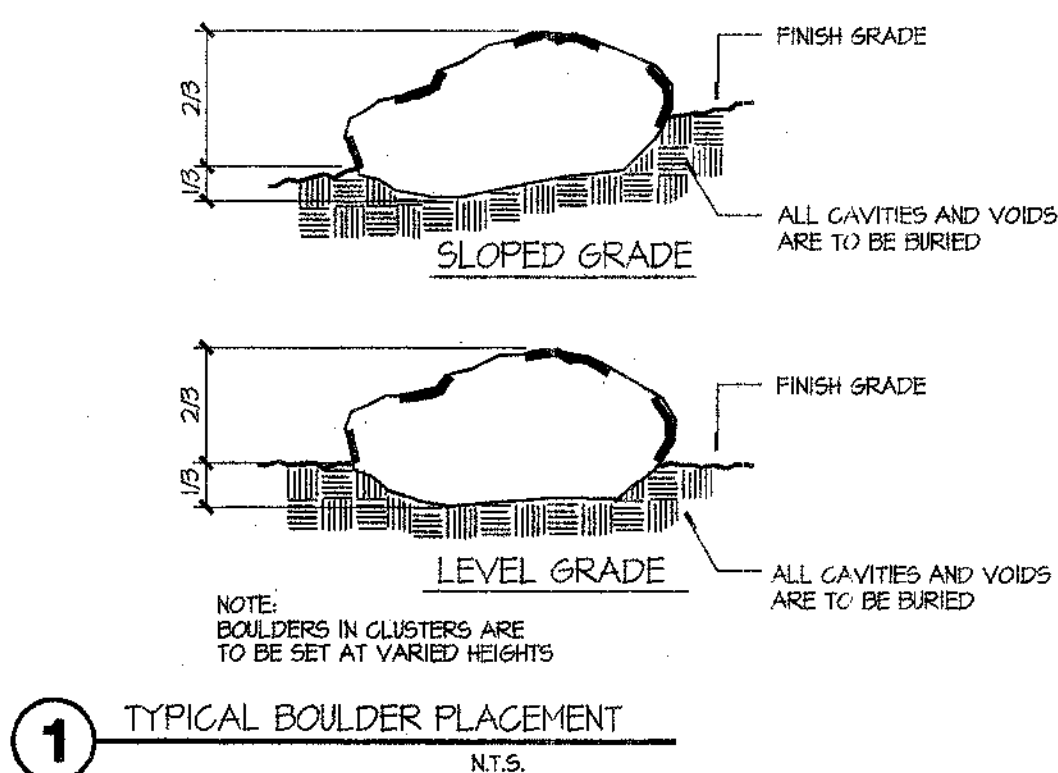



1 TYPICAL BOULDER PLACEMENT
N.T.S.

BOULDER SCHEDULE

SYMBOL	SIZE	QUANTITY
A	3'x4'x2' ± 1-1/2 tons	#
B	2'x3'x2' ± 3/4 ton	#
C	3'x1'x2' ± 1/2 ton	#
D	2'x2'x1' ± 1/4 ton	#

BOULDER NOTES:

Boulders are to be smooth gray granite varying in size from 2'x3' to 3'x5'. Boulders are identified on landscape plan by letter, 'A' being the largest and 'D' being the smallest. Landscape contractor to vary the sizes and heights when placing boulders in clusters. Boulders to be buried no less than 1/3 of their height upon final grading.

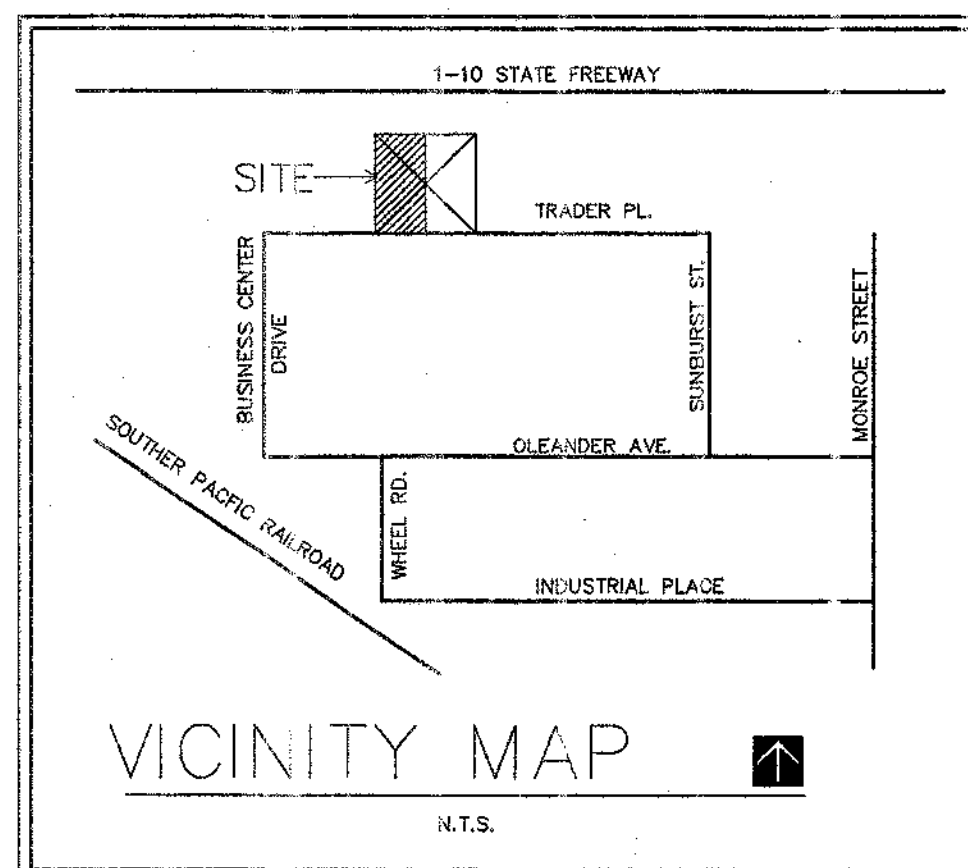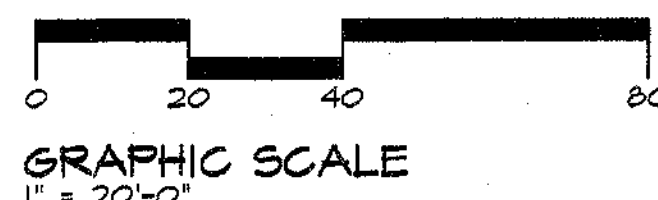

Scale:

1" = 20'-0"

Date:

6-23-03

Sheet No.


P.1

PLANTING PLAN

HANOUSEK BUILDING
INDIO, CALIFORNIA

no.	revisions	date
1		
2		
3		
4		
5		

NO.	REVISIONS	DATE
1		
2		
3		
4		
5		

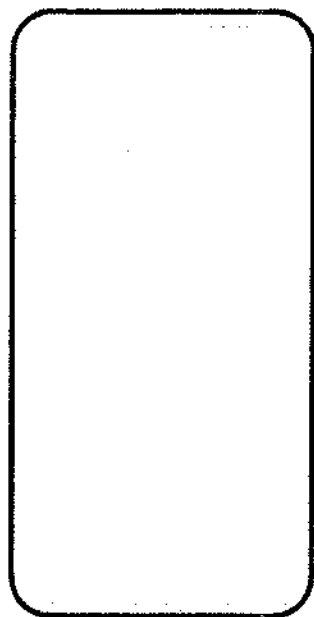

IRRIGATION PLAN

HANOUSEK BUILDING
INDIO, CALIFORNIA

Scale:
1" = 20'-0"

Date:
6-23-03

Sheet No.


1.1

DRIP IRRIGATION LEGEND							
SYMBOL	MANUFACTURER	MODEL NO.	DESCRIPTION	NOZZLE	RADIUS	FLOW GPM	PRI
•	RAINBIRD	1400 SERIES	BUBBLER	1404	-	1.00 GPM	25
•	RAINBIRD	XB-SERIES	XEB-BUG	XB-20	-	2.0 GPM	30
* SYMBOL INDICATES BUBBLER GROUPING. REFER TO DETAIL ON SHEET.							
⊠	HUNTER	100-1000-M	12 STATION LIGHT-DUTY COMMERCIAL CONTROLLER. CONFIGURABLE TO 32 STATIONS				
⊙	RAINBIRD	10V SERIES	ELECTRIC CONTROL VALVE KIT FOR DRIP AREAS PLUS PALM TREE BUBBLERS, SIZE AS NOTED ON PLAN.				
⊙	RAINBIRD	10V SERIES	ELECTRIC CONTROL VALVE FOR TURF AREAS AND PALM/TREE BUBBLERS, SIZE AS NOTED ON PLAN.				
⊙	XB	#MP-1000-T	BALL VALVE (LINE SIZE), REFER TO DETAIL ON IRRIGATION DETAIL SHEET				
⊙	RAINBIRD	30C	3/4" QUICK COUPLER REFER TO DETAIL ON IRRIGATION DETAIL SHEET				
PRESSURE MAINLINE PIPING USE SCHEDULE 40 - SIZE AS NOTED							
NON-PRESSURE LATERAL LINE PIPING - PVC CLASS 200 FOR TURF AND PALM TREE BUBBLERS							
DRIP SYSTEM PIPING FOR ZONING INDICATION. LARGER DOT INDICATES END OF BACKBONE LATERAL							
BACKFLOW PREVENTOR - SIZE AS NOTED ON PLAN							
IRRIGATION POINT OF CONNECTION - 3/4" IRRIGATION POINT OF CONNECTION FROM WATER METER SOURCE.							
PIPE SLEEVING SHALL OCCUR UNDER ALL MAJOR HARDSCAPE. SLEEVING SHALL BE 4" DIAMETER PIPE.							
INDICATES CONTROLLER NUMBER							
INDICATES FLOW IN GALLONS PER MINUTE							
INDICATES ZONE TYPE							
INDICATES ELECTRIC CONTROL VALVE SIZE							

PIPE SIZE	MAX. ALLOWABLE FLOW
1/2"	5 GPM
3/4"	10 GPM
1"	16 GPM
1-1/4"	26 GPM
1-1/2"	40 GPM
2"	60 GPM

-REFER TO PLANT LIST / EMITTER SCHEDULE FOR EMITTER MODEL # AND GPM FOR EACH PLANT SPECIES THIS SHEET.

-REFER TO EXAMPLE DRIP EMITTER LATERAL SYSTEM DETAIL SHEET L4.

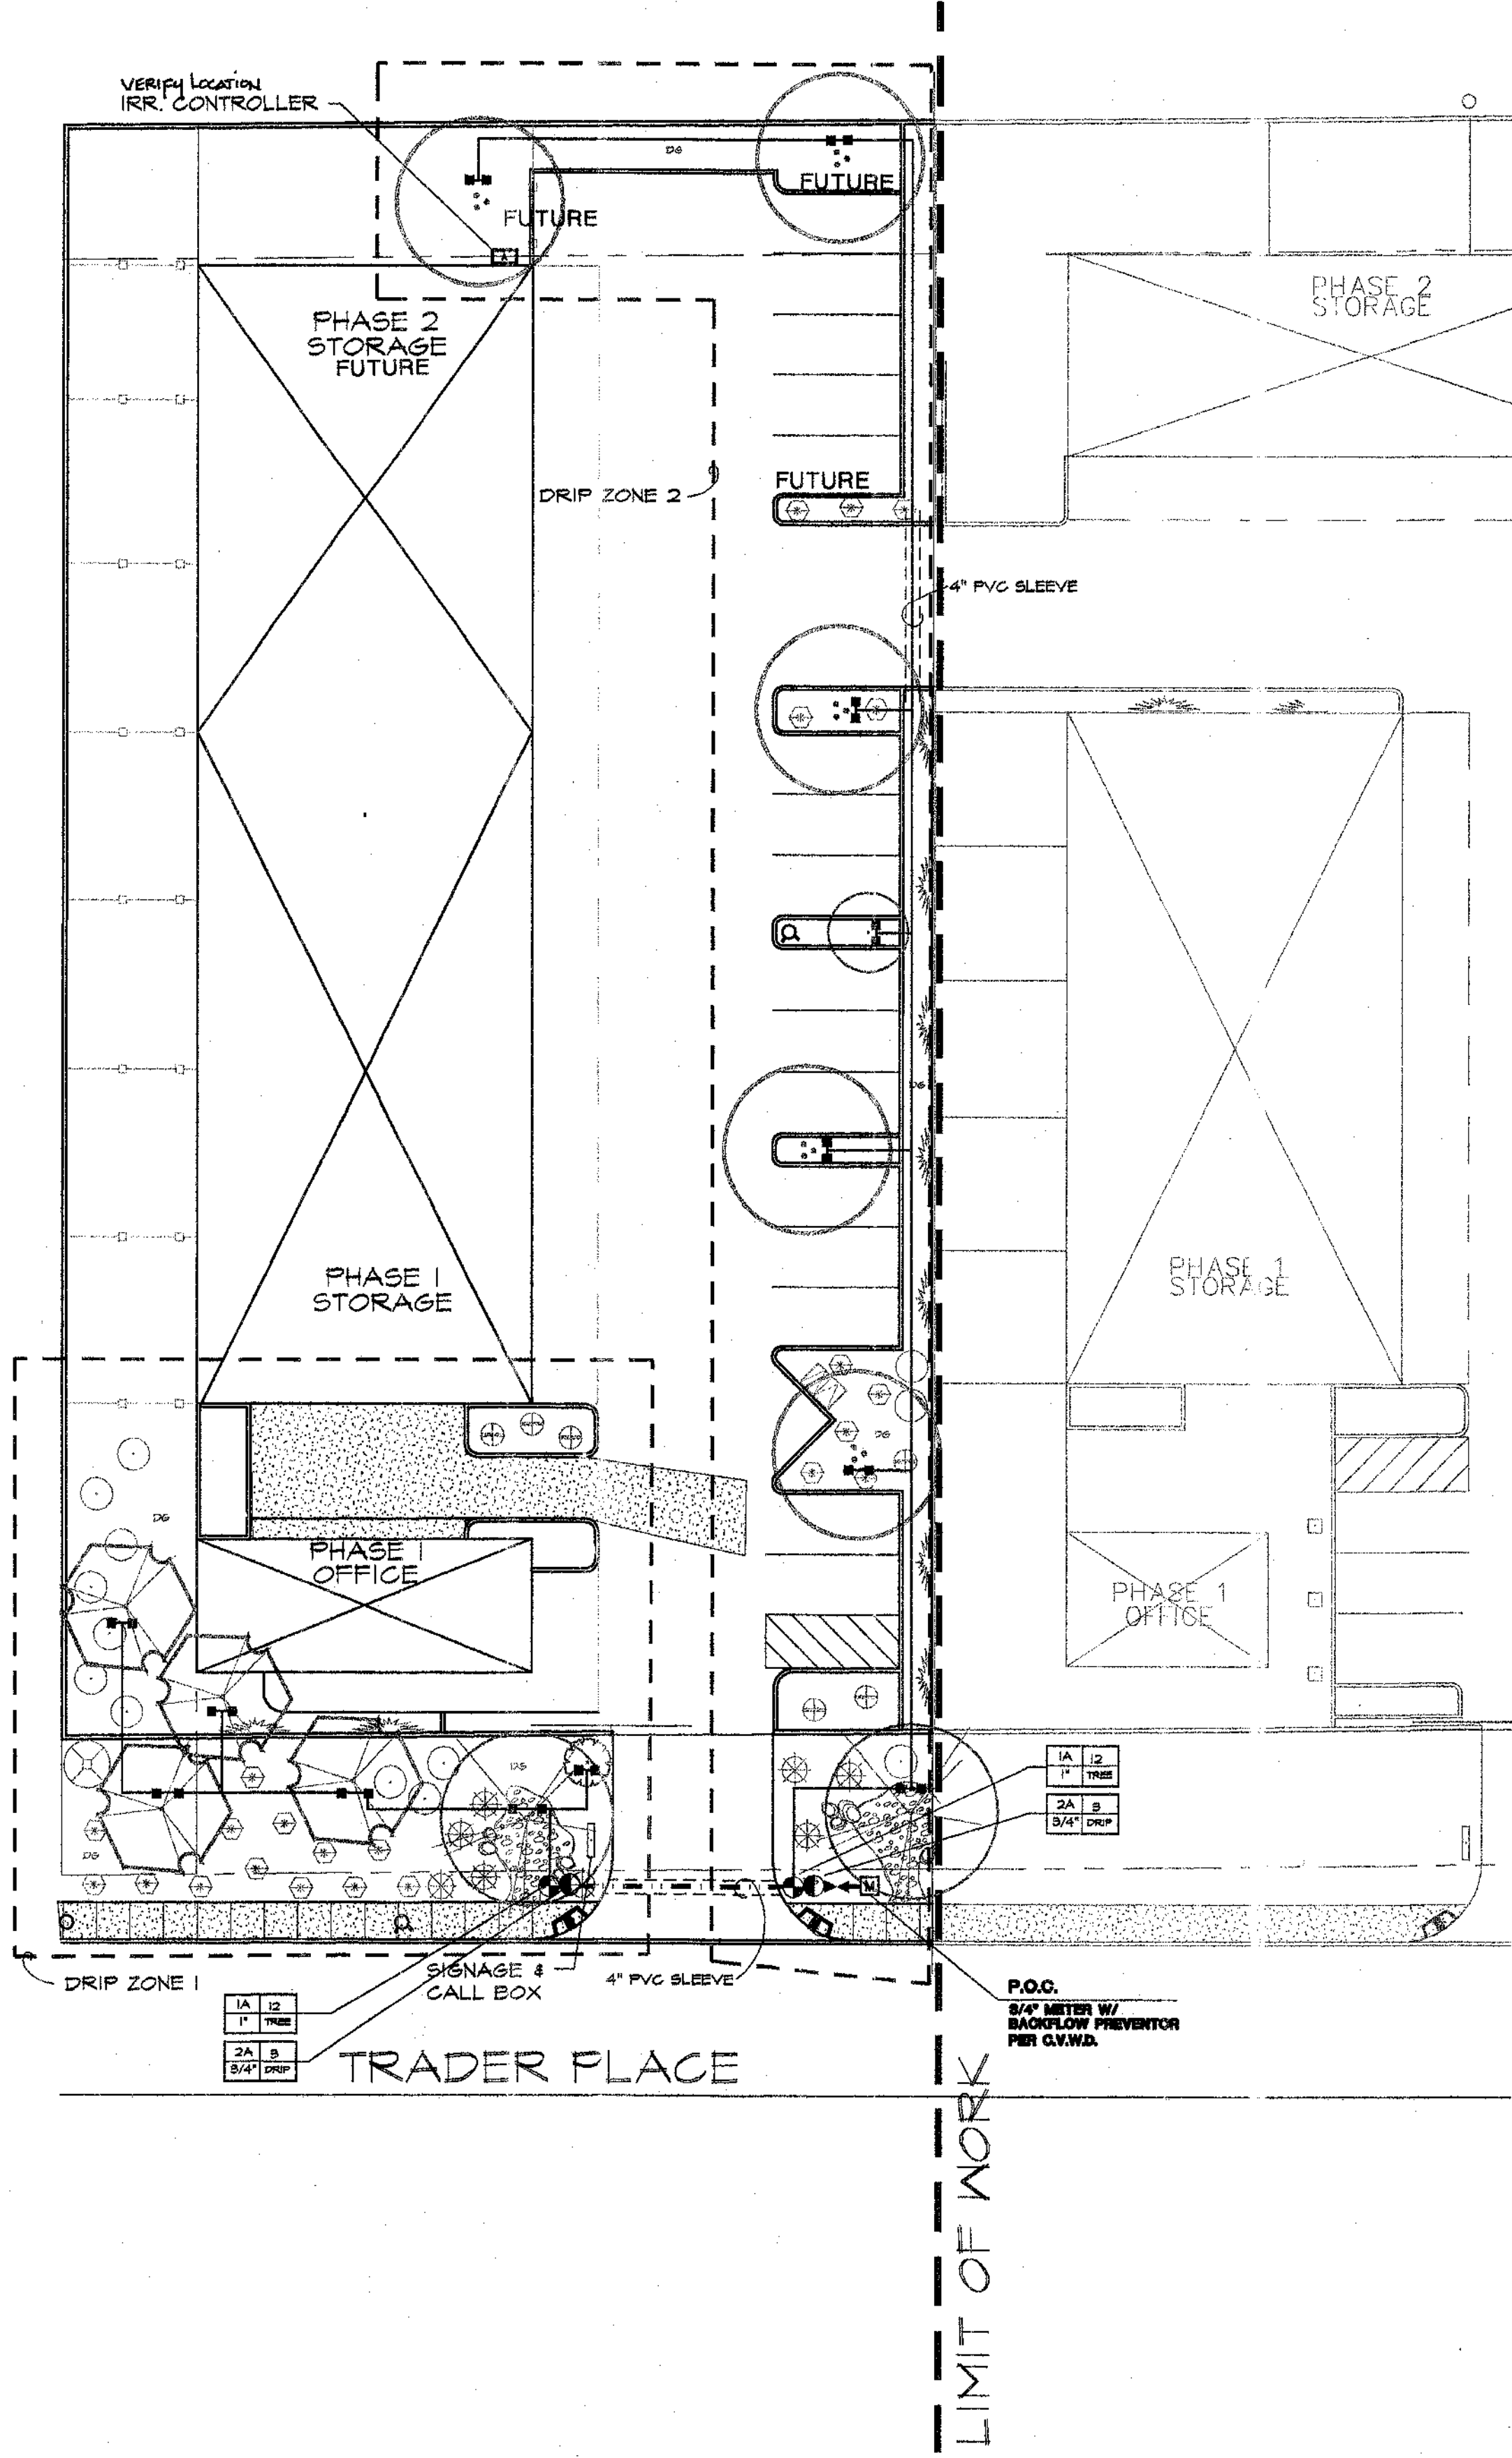

PLANT LEGEND

CANOPY TREES

SYM.	NAME	SIZE	QTY.	EMITTER
AA	Acacia aneura Melga	24" box	5	1404
ASH	Acacia small Weeping Acacia	24" BOX	5	1404
PF	Pithecellobium flexicaule Texas Ebony	24" BOX	1	1404
CPR	Cercidium praecox Sonoran Palo Verde	24" BOX	2	1404

SHRUBS

SYM.	NAME	WATER USAGE	SIZE	QTY.	EMITTER
⊙	Chamaerops humilis Mediterranean Fan Palm		24" box	1	1404

SHRUBS


SYM.	NAME	WATER USAGE	SIZE	QTY.	EMITTER
⊙	Bougainvillea 'Rosenita' Bougainvillea	(L/M)	5 gal.	0	XB-20
⊙	Caesalpinia pulcherrima Barbados Pride		5 gal.	1	XB-20
⊙	Cassia nemophila Green Cassia		5 gal.	13	XB-20
⊙	Lantana montevidensis 'New Gold' Yellow Trailing Lantana	(L/M)	1 gal.	23	XB-20
⊙	Muhlenbergia capillaris 'Regal mist' Regal Mist		1 gal.	4	XB-20

VINES


SYM.	NAME	WATER USAGE	SIZE	QTY.	EMITTER
⊙	Bougainvillea 'Barbara Karst' Bougainvillea		5 gal.	4	XB-20

DESERT ACCENTS


SYM.	NAME	WATER USAGE	SIZE	QTY.	EMITTER
⊙	Dasylistron wheeleri Desert Spoon	(L/M)	5 gal.	0	XB-20

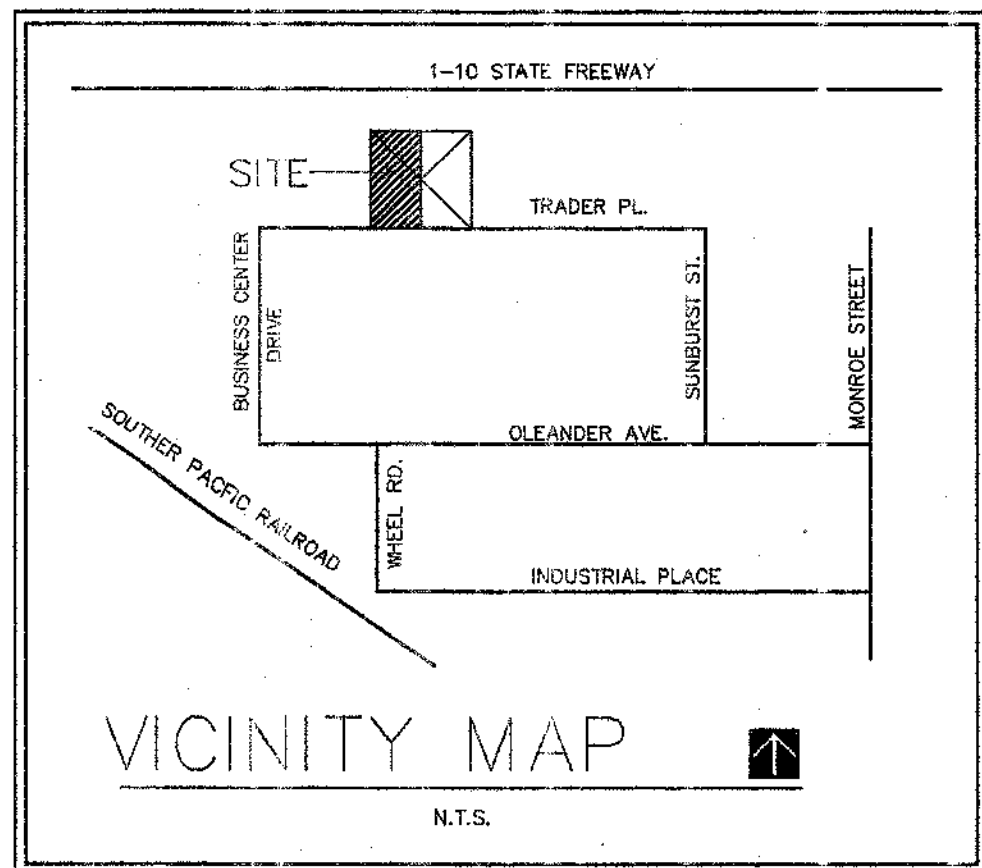


SEE SHEET I-2 FOR IRRIGATION DETAILS

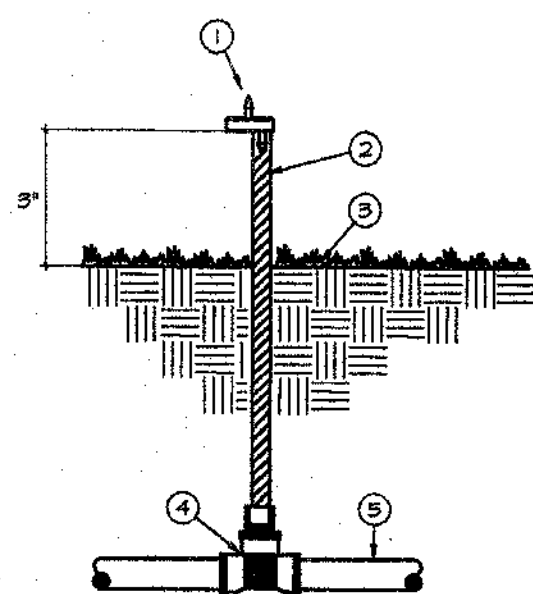


- LEGEND
- RAIN BIRD XB-20 EMITTER
 - BONSMITH POLYFLEX RISER (LENGTH AS REQUIRED)
 - FINISH GRADE
 - PVC FITTING (3/4 x 5/8 x 1/2" FIT)
 - PVC PIPE (DEPTH PER DETAIL)

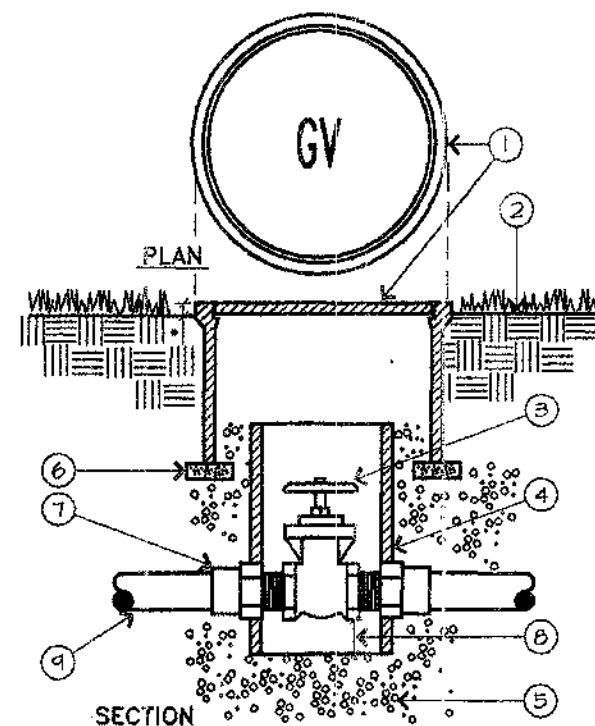

- LEGEND
- ROUND VALVE BOX WITH GREEN BOLT-DOWN COVER - HEAT BRAND "GV" ON VALVE BOX COVER IN 2" HIGH CHARACTERS.
 - FINISH GRADE
 - GATE VALVE WITH BRONZE WHEELHANDLE OR CROSSHANDLE
 - 6" DIA. SCH. 40 PVC PIPE EXTENSION - LENGTH AS REQUIRED
 - 3/4" CRUSHED ROCK - 6" DEPTH
 - COMMON BRICK (2 REQUIRED)
 - PVC MALE ADAPTER (TYPICAL)
 - 2" CLEARANCE
 - PVC MAIN LINE PIPE
- * 1" IN LAWN AREAS.
2" IN SHRUB AREAS.

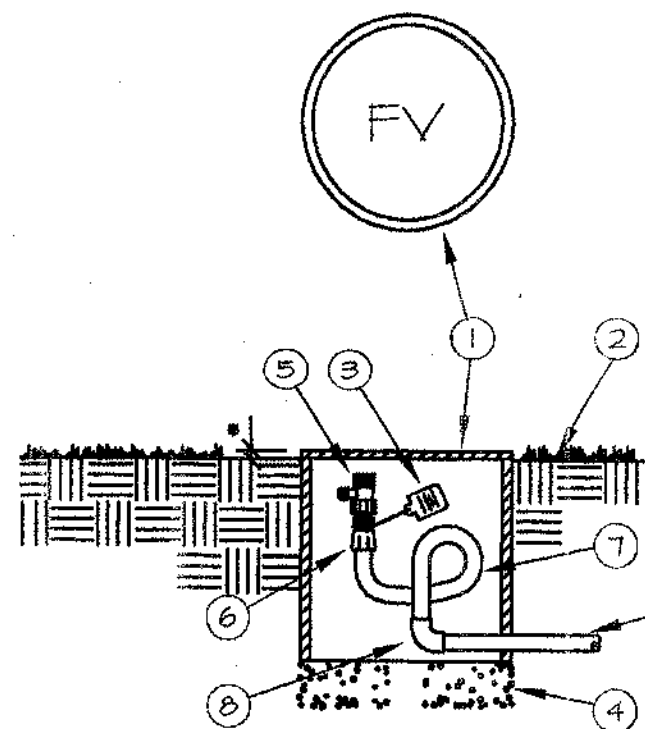


- LEGEND
- BROOKS #1000 10"x10" ROUND VALVE BOX, HEAT BRAND "FV" ON LID IN 2" HIGH CHARACTERS.
 - FINISH GRADE
 - CHRISTY'S I.D. TAG, (SEE NOTES)
 - 3/4" CRUSHED ROCK, 6" DEPTH
 - AS PRODUCTS 3/4"-B BALL VALVE
 - PVC SCH. 40 MALE ADAPTER
 - SALCO A/R FLEXIBLE P/C HOSE MINIMUM 3 FOOT LENGTH
 - SCH 40 - 90 DEGREE EL. 30K
 - RIGID PVC PIPE
- * 1" IN LAWN AREAS.
2" IN SHRUB AREAS.
- NOTE: USE TEFLON TAPE ON ALL MALE PIPE THREADS.

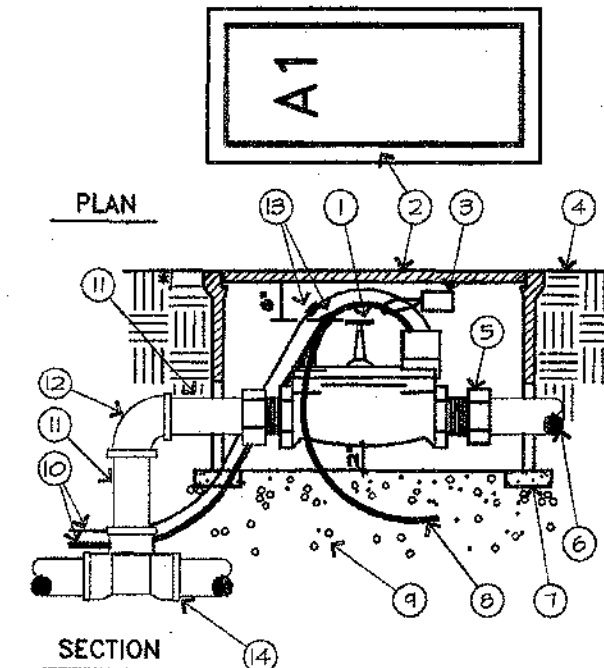


- LEGEND
- ELECTRIC CONTROL VALVE
 - RECTANGULAR VALVE BOX WITH GREEN BOLT-DOWN COVER, HEAT BRAND VALVE STATION NO. ON LID IN 2" HIGH CHARACTERS.
 - CHRISTY'S I.D. TAG - NUMBERED TO MATCH DRAWINGS
 - FINISH GRADE
 - PVC MALE ADAPTER (TYP)
 - PVC PIPE TO SYSTEM - ANGLE PIPE TO SPECIFIED DEPTH WITH 45 DEG. ELLS.
 - COMMON BRICK (4 REQUIRED)
 - COMMON WIRE TO OTHER VALVES ON SAME CONTROLLER
 - 3/4" CRUSHED ROCK, 6" DEEP
 - CONTROL/COMMON WIRES FROM CONTROLLER
 - PVC SCHEDULE 40 PIPE
 - PVC 90 DEG. ELL
 - WIRE CONNECTOR
 - MAIN LINE FITTING INSOLVENT WELD OUTLET
- * 1" IN SHRUB AREAS.
1" IN TURF AREAS.

I DRIP EMITTER ASSEMBLY N.T.S.


- LEGEND
- ELECTRIC BATTERY CONTROL VALVE ASSEMBLY
 - BACKSIPH LATERAL - PVC GLASS 200 PIPE
 - RUSH VALVE, SEE DETAIL C THIS SHEET
 - DRIP LATERAL - PVC GLASS 1/2" PIPE
 - BOUNDARY FOR DRIP VALVE ZONE
 - SHRUB EMITTER DETAIL (TYPICAL)
 - MAINLINE

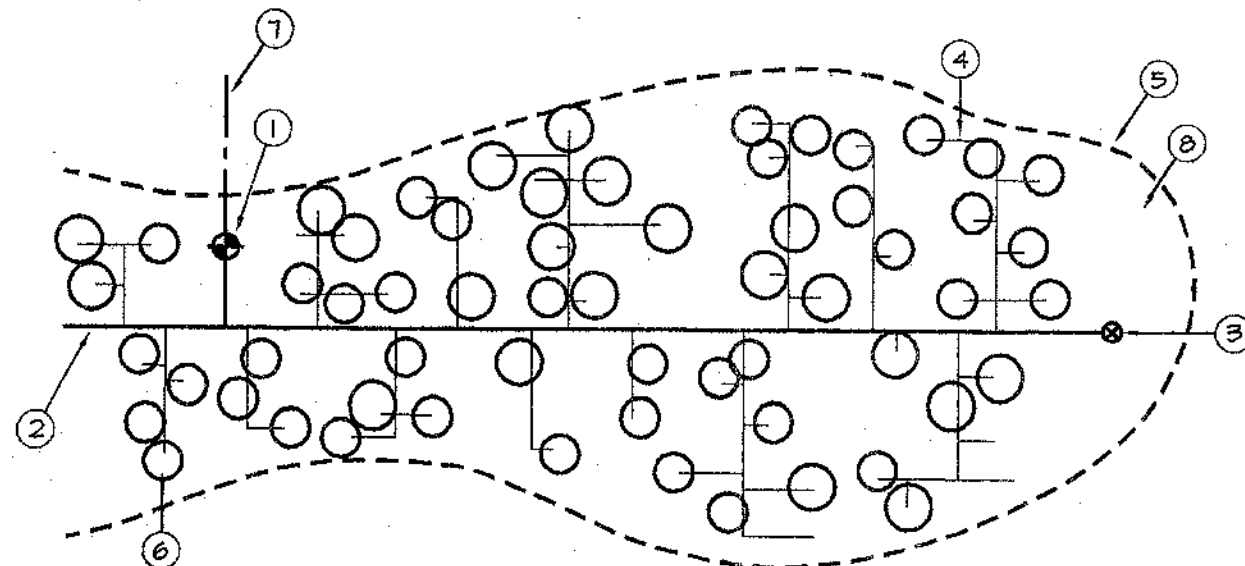


F GATE VALVE N.T.S.

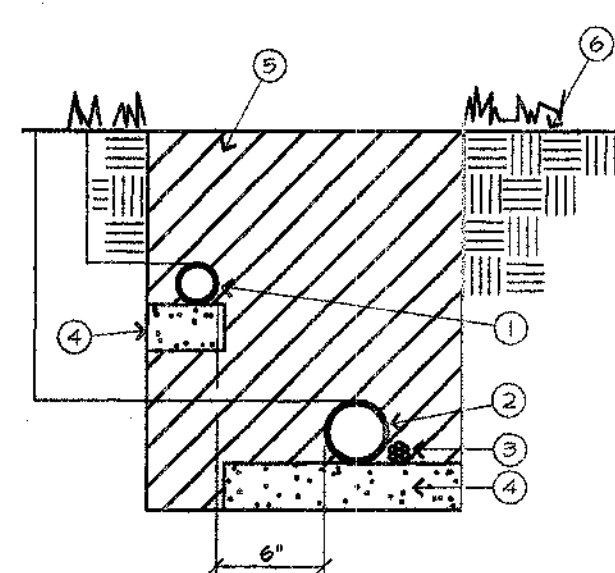

- LEGEND
- NON-PRESSURE LATERAL LINE PIPING
 - PRESSURE MAIN LINE PIPING
 - CONTROL WIRES - TAPE AND BUNDLE EVERY 10 FEET, INSTALL ADJACENT TO PRESSURE MAIN LINE
 - PROVIDE 2" DEPTH OF CLEAN BACKFILL
 - SEE IRRIGATION SPECIFICATIONS FOR BACKFILL AND COMPACTION REQUIREMENTS
 - FINISH GRADE
- * MINIMUM BACKFILL DEPTHS FROM FINISH GRADE TO TOP OF MAINLINE:
24" FOR PIPE SIZES 3" AND LARGER
18" FOR PIPE SIZES 2 1/2" AND SMALLER

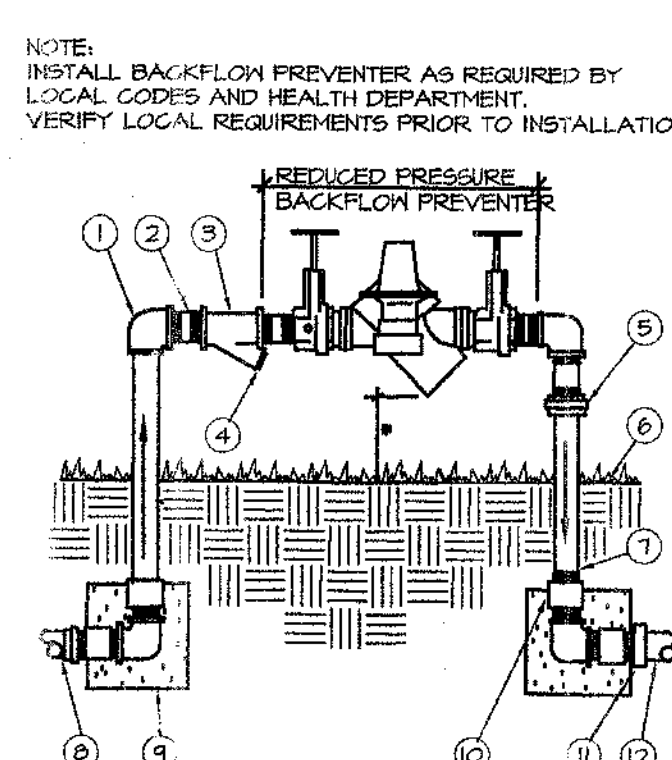


- LEGEND
- BRASS 90 DEG. ELL (TYP)
 - BRASS NIPPLE - 4" MIN. LBS 15TH (TYP)
 - BRASS NYE STRAINER WITH MESH MONEL SCREEN
 - BRASS PLUS
 - BRASS UNION
 - FINISH GRADE
 - BRASS NIPPLE (TYP)
 - FROM POINT OF CONNECTION ADAPT AS REQ'D
 - 12" x 12" x 12" CONCRETE 'CRUST BLOCK' (TYP)
 - BRASS COUPLING, SET FLUSH W/ CONCRETE (TYP)
 - PVC MALE ADAPTER
 - PVC MAINLINE
- * 12" MIN/24" MAX.

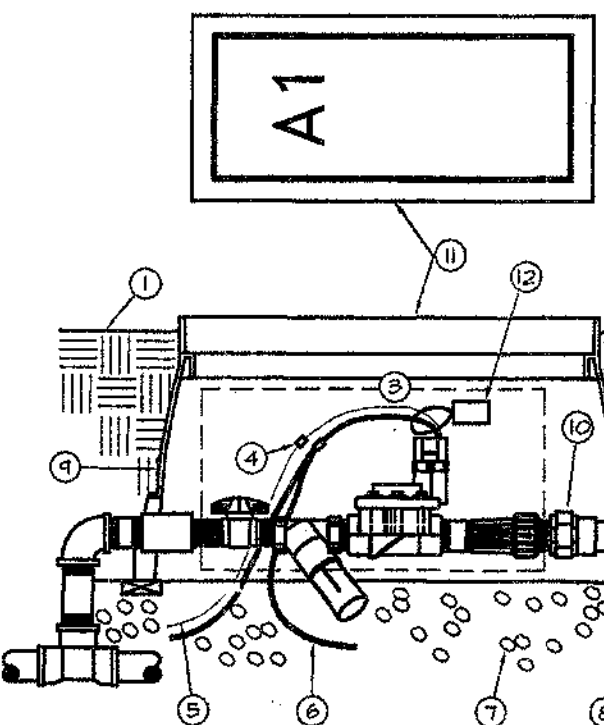


- LEGEND
- FINISH GRADE
 - PVC PIPE (DEPTH PER DETAIL)
 - RAIN BIRD MODEL # XZZ-OTS XERIGATION CONTROL ZONE ASSEMBLY
 - WIRE CONNECTOR
 - PILOT WIRE
 - COMMON WIRE
 - 3/4" CRUSHED ROCK
 - (4) 2" x 4" x 12" REDWOOD FOR SUPPORT
 - 12" x 10" RECTANGULAR VALVE BOX
 - PVC UNION FOR SERVICING ASSEMBLY
 - RECTANGULAR VALVE BOX WITH GREEN BOLT-DOWN COVER, HEAT BRAND VALVE STATION NO. ON LID IN 2" HIGH CHARACTERS
 - CHRISTY'S I.D. TAG - NUMBERED TO MATCH DRAWINGS

J DRIP LAYOUT N.T.S.

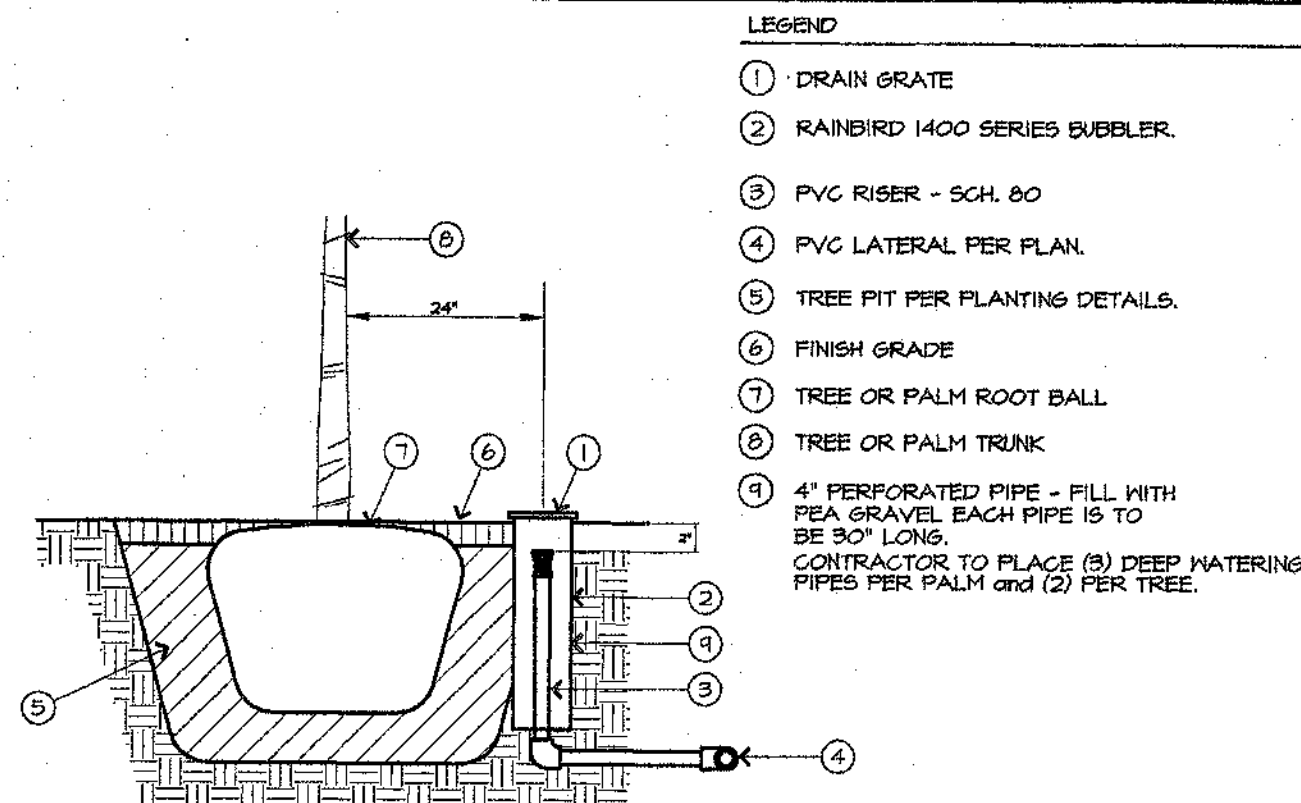


- LEGEND
- DRAIN GRATE
 - RAINBIRD 1400 SERIES BUBBLER
 - PVC RISER - SCH. 80
 - PVC LATERAL PER PLAN
 - TREE PIT PER PLANTING DETAILS
 - FINISH GRADE
 - TREE OR PALM ROOT BALL
 - TREE OR PALM TRUNK
 - 4" PERFORATED PIPE - FILL WITH PEA GRAVEL EACH PIPE IS TO BE 30" LONG. CONTRACTOR TO PLACE (8) DEEP WATERING PIPES PER PALM and (2) PER TREE.

G TRENCHING N.T.S.

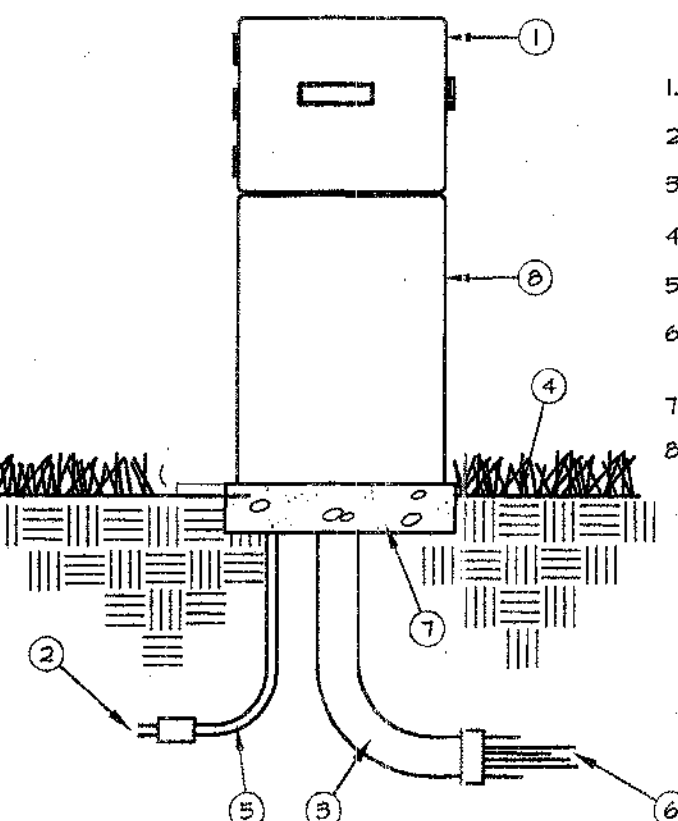

- LEGEND
- AUTOMATIC CONTROLLER (SEE LEGEND)
 - 120-VOLT POWER SUPPLY WIRES IN CONDUIT
 - PVC CONDUIT - 2 1/2"
 - FINISH GRADE
 - SWEET ELL - 2 1/2"
 - DIRECT BURIAL CONTROL WIRES TO CONTROL VALVES
 - 4" THICK CONCRETE FOOTINGS
 - STAINLESS STEEL PEDESTAL (SEE LEGEND)
- NOTE: INSTALL ALL WIRING PER LOCAL CODE.

D BACKFLOW PREVENTOR N.T.S.

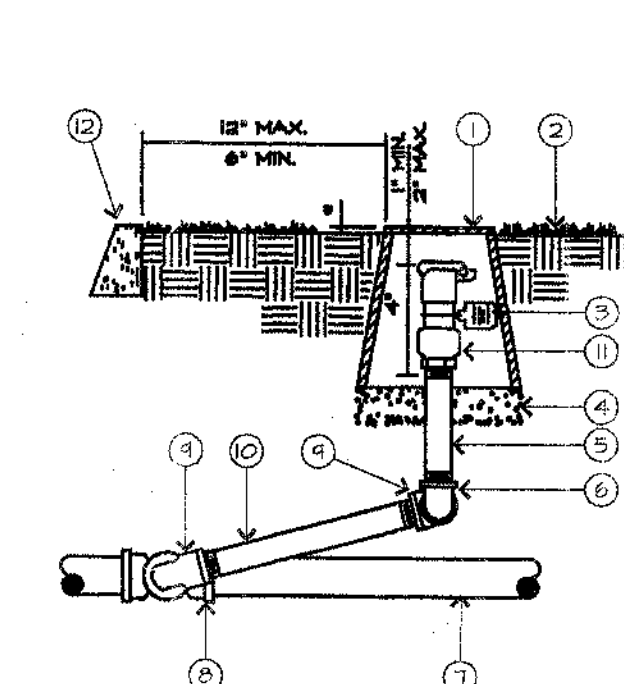

- LEGEND
- BROOKS ECONOMY VALVE BOX, HEAT BRAND "QCV" ON LID IN 2" HIGH CHARACTERS
 - FINISH GRADE
 - CHRISTY'S I.D. TAG
 - 3/4" CRUSHED ROCK, 6" DEPTH
 - BRASS NIPPLE
 - BRASS 40 DEG. ELL
 - MAIN LINE PIPING
 - MAIN LINE FITTING
 - BRASS 90 DEG. STREET EL
 - BRASS NIPPLE - 6" LONG
 - QUICK COUPLING VALVE
 - WALK OR CURB
- * 1" IN LAWN AREAS.
2" IN SHRUB AREAS.
- NOTE: USE TEFLON TAPE ON ALL MALE PIPE THREADS.

B XERIGATION CONTROL VALVE N.T.S.

GENERAL IRRIGATION NOTES

- ALL POP-UP TYPE SPRINKLER HEADS INSTALLED IN SHRUB OR GROUNDCOVER AREAS SHALL BE INSTALLED SO THAT THE TOP OF THE SPRINKLER HEAD IS 1" ABOVE FINISH GRADE.
- ALL POP-UP TYPE SPRINKLER HEADS INSTALLED IN LAWN AREAS SHALL BE INSTALLED SO THAT THE TOP OF THE SPRINKLER HEAD IS FLUSH WITH ADJACENT SIDEWALK OR CURB.
- IN OPEN SEEDED LAWN AREAS SET TOP OF POP-UP TYPE SPRINKLER HEADS 3" ABOVE FINISH GRADE UNTIL LAWN IS ESTABLISHED. LOWERING OF ALL LAWN HEADS BY THE IRRIGATION CONTRACTOR SO THAT THE TOP OF THE SPRINKLER HEAD IS 1/4" ABOVE FINISH GRADE, SHALL BE ACCOMPLISHED WITHIN TEN (10) DAYS AFTER NOTIFICATION BY THE OWNER'S AUTHORIZED REPRESENTATIVE.
- ALL SPRINKLER HEADS SHALL BE SET PERPENDICULAR TO FINISH GRADE OF THE AREA TO BE IRRIGATED UNLESS OTHERWISE DESIGNATED ON THE PLANS.
- THE SPRINKLER SYSTEM DESIGN IS BASED ON THE MINIMUM OPERATING PRESSURE AND THE MAXIMUM FLOW DEMAND SHOWN ON THE IRRIGATION DRAWINGS AT THE METER OR POINT OF CONNECTION. THE IRRIGATION CONTRACTOR SHALL VERIFY WATER PRESSURE PRIOR TO CONSTRUCTION. REPORT ANY DIFFERENCE BETWEEN THE WATER PRESSURE INDICATED ON THE DRAWINGS AND THE ACTUAL PRESSURE EXISTING AT THE IRRIGATION POINT OF CONNECTION TO THE OWNER'S AUTHORIZED REPRESENTATIVE. IN THE EVENT PRESSURE DIFFERENCES ARE NOT REPORTED PRIOR TO START OF CONSTRUCTION, THE IRRIGATION CONTRACTOR SHALL ASSUME FULL RESPONSIBILITY FOR ANY REVISIONS NECESSARY.
- 120 VOLT ELECTRICAL POWER OUTLET AT THE AUTOMATIC CONTROLLER LOCATION SHALL BE PROVIDED BY OTHERS. IT SHALL BE THE RESPONSIBILITY OF THE IRRIGATION CONTRACTOR TO MAKE THE FINAL HOOK-UP FROM THE ELECTRICAL OUTLET TO THE AUTOMATIC CONTROLLER.
- THIS DESIGN IS DIAGNOSTIC. ALL PIPING, VALVES, ETC. SHOWN WITHIN PAVED AREAS IS FOR DESIGN CLARIFICATION ONLY AND SHALL BE INSTALLED IN PLANTING AREAS. AVOID ANY CONFLICTS BETWEEN THE SPRINKLER SYSTEM, PLANTING AND ARCHITECTURAL FEATURES.
- THE IRRIGATION CONTRACTOR SHALL FLUSH AND ADJUST ALL SPRINKLER HEADS FOR OPTIMUM PERFORMANCE AND TO ALLOW FOR NO OVERSPRAY ONTO WALKS, ROADWAYS AND/OR BUILDINGS. THIS SHALL INCLUDE SELECTING THE BEST DEGREE OF ARC TO FIT THE EXISTING SITE CONDITIONS AND TO THROTTLE THE FLOW CONTROL, AT EACH VALVE TO OBTAIN THE OPTIMUM OPERATING PRESSURE FOR EACH SYSTEM.
- DO NOT WILLFULLY INSTALL THE SPRINKLER SYSTEM AS SHOWN ON THE DRAWINGS WHEN IT IS OBVIOUS IN THE FIELD THAT OBSTRUCTIONS, GRADE DIFFERENCES OR DIFFERENCES IN THE AREA DIMENSIONS EXIST THAT MIGHT NOT HAVE BEEN CONSIDERED IN THE ENGINEERING. SUCH OBSTRUCTIONS OR DIFFERENCES SHOULD BE BROUGHT TO THE ATTENTION OF THE OWNER'S AUTHORIZED REPRESENTATIVE. IN THE EVENT THIS NOTIFICATION IS NOT PERFORMED, THE IRRIGATION CONTRACTOR SHALL ASSUME FULL RESPONSIBILITY FOR ANY REVISIONS NECESSARY.
- INSTALL ALL PIPE MATERIALS AND EQUIPMENT AS SHOWN IN DETAILS. USE TEFLON TAPE OR TEFLON PIPE DOPE ON ALL PVC MALE PIPE THREADS ON ALL SPRINKLER SWING JOINT AND VALVE ASSEMBLIES.
- IT IS THE RESPONSIBILITY OF THE IRRIGATION CONTRACTOR TO FAMILIARIZE HIMSELF WITH ALL GRADE DIFFERENCES, LOCATION OF WALLS, RETAINING WALLS, ETC. HE SHALL COORDINATE HIS WORK WITH THE GENERAL CONTRACTOR AND OTHER SUB-CONTRACTORS FOR THE LOCATION AND THE INSTALLATION OF PIPE SLEEVES THROUGH WALLS, UNDER ROADWAYS, WALKS, STRUCTURES, ETC.
- IN ADDITION TO THE CONTROL WIRE SLEEVES SHOWN ON THE DRAWINGS, THE IRRIGATION CONTRACTOR SHALL BE RESPONSIBLE FOR THE INSTALLATION OF CONTROL WIRE SLEEVES OF SUFFICIENT SIZE UNDER ALL OTHER PAVED AREAS.

DRAINAGE NOTE

DRAINAGE OF IRRIGATION WATER THROUGH SPRINKLER HEADS WILL NOT BE ALLOWED. SOME PORTIONS OF THE IRRIGATION SYSTEM WILL REQUIRE THE INSTALLATION OF RAINBIRD 1804-SAM, 1806-SAM, AND 1812-SAM IN LIEU OF RAINBIRD 1804, 1806, AND 1812 SPRINKLER HEADS TO PREVENT DRAINAGE. DURING THE COURSE OF CONSTRUCTION, THE CONTRACTOR SHALL INSTALL RAINBIRD POP-UP SPRINKLER HEADS WITH "SAM" FEATURE AS REQUIRED AT ANY SPRINKLER HEAD SHOWING SIGNS OF DRAINAGE AFTER THE IRRIGATION SYSTEM HAS OPERATED FROM AN ON TO OFF POSITION. INSTALLATION OF "SAM" FEATURE SHALL BE INCLUDED IN THE BID PRICE WITHOUT ADDITIONAL COST TO THE OWNER.

K TREE/PALM IRRIGATION N.T.S.

H CONTROLLER CLOCK N.T.S.

E QUICK COUPLER N.T.S.

IRRIGATION DETAILS

HANOUSEK BUILDING
INDIO, CALIFORNIA

Scale:
1"= 20'-0"

Date:
6-23-03

Sheet No.